

CONDENSING UNIT
 MAX. SIZE = 37-3/4" L X 28-1/4" W X 17-1/4" H
 MAX. WEIGHT = 211 Lbs.

WALK-IN COOLER & FREEZER

THE STRUCTURE CAN BE FIXED TO AN ENGINEERED CEMENT PAD WITH ANCHOR BOLTS.

THIS PRODUCT HAS BEEN DESIGNED AND TESTED TO COMPLY WITH THE REQUIREMENTS OF THE 2018 INTERNATIONAL RESIDENTIAL CODE (IRC) AND 2018 INTERNATIONAL BUILDING CODE (IBC).

THIS PRODUCT CONTROL APPROVAL IS FOR THE WALK-IN AS SHOWN ON THESE APPROVED DRAWINGS. UPLIFT, OVERTURNING, FOUNDATIONS, FLOOR SLAB AND OTHER ELEMENTS SHALL BE DESIGNED BY A REGISTERED PROFESSIONAL ENGINEER AND REVIEWED BY THE STRUCTURAL PLANS EXAMINER OF THE CORRESPONDING BUILDING DEPARTMENT.

ALL ELECTRICAL, MECHANICAL DETAILS AND FIRE RATING PROVISIONS ARE NOT PART OF THIS APPROVAL AND SHALL BE PREPARED BY A REGISTERED PROFESSIONAL ENGINEER AND REVIEWED BY CORRESPONDING BUILDING DEPARTMENT.

STRUCTURAL STEEL SHALL CONFORM TO ASTM DESIGNATION A-36. PANEL OUTER SURFACES ARE 26 GA. G60 STEEL PAINTED WITH VALSPAR PHMA-6063-B BLANCO 15 WHITE. PANEL INNER SURFACES ARE 23 GA. EMBOSSED ALUMINUM. COOLER FLOOR IS 14 GA. FLAT ALUMINUM. RIGID XPS FOAM (EXTRUDED POLYSTYRENE) MAX. FLAME SPREAD RATING < 25 AS PER ASTM E-84 SMOKE DEVELOPED INDEX < 185 SPONTANEOUS-IGNITION TEMPERATURE: 600-800F

MATERIALS INCLUDING BUT NOT LIMITED TO STEEL/METAL SCREWS, THAT COME INTO CONTACT WITH OTHER DISSIMILAR MATERIALS SHALL MEET THE REQUIREMENTS OF THE 2018 IRC/IBC.

DESIGN IS BASED ON TESTING IN ACCORDANCE WITH THE 2018 IRC/IBC AND 2020 FLORIDA BUILDING CODE. LARGE MISSILE IMPACT TEST, TAS 201-94. CYCLIC WIND PRESSURE TEST, TAS 203-94. STATIC AIR PRESSURE TEST, TAS 202. ASTM E72 FOR COMPONENT RACKING 24 HOUR GRAVITY LOAD TEST (AIR AND WATER INFILTRATION WERE NOT TESTED)

THIS PRODUCT APPROVAL DOCUMENT IS GENERIC AND DOES NOT PROVIDE INFORMATION FOR A SITE SPECIFIC PROJECT.

WALK-IN TO BE INSTALLED AS PER MANUFACTURER'S INSTALLATION INSTRUCTIONS.

INSTALLATION ANCHORS
 SEE NOTE BELOW

TYPICAL ELEVATION

INSTALLATION ANCHORS:

DIRECTLY INTO CONCRETE (3000 PSI MIN.)
 1/2" DIA. KWIK BOLT-3 EXPANSION ANCHOR
 3-1/2" MIN. EMBED INTO CONCRETE.
 6" MIN. EDGE DIST.


INTO A36 STEEL STRUCTURES (3/8" MIN. THICKNESS)
 1/2" DIA. MACHINE SCREWS (GRADE 5 CRS)
 (Fu = 120,000 PSI & Fy = 23,004 PSI)
 (3) THREADS TO EXTEND BEYOND METAL THICKNESS
 1" MIN. EDGE DISTANCE

NOTE:
 ANCHOR TORQUED AND OTHERWISE INSTALLED AS PER MANUFACTURER SPECIFICATIONS.

MAXIMUM DESIGN LOAD RATING = + 70.0 PSF
 FOR SIZES SHOWN ABOVE OR SMALLER - 65.0 PSF

MAX. RACKING LOAD (ROOF PANELS) = 332 Lbs./LIN. FT. OF PANEL LENGTH
 MAX. RACKING LOAD (WALL PANELS) = 465 Lbs./LIN. FT. OF PANEL LENGTH


Sealed: 5/27/2021

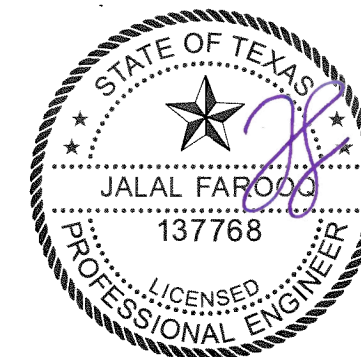

af c
AL-FAROOQ CORPORATION
 ENGINEERS & PRODUCT DEVELOPMENT
 9360 SUNSET DRIVE, SUITE 220 (C.A.N. 3538)
 MIAMI, FLORIDA 33173
 TEL. (305) 264-8100 FAX. (305) 262-6978
 COOLER\20-95T-BUS

WALK-IN COOLER & FREEZER
Barcel USA LLC.
 301 Northpoint Drive, Suite 100
 Coppell, TX 75019
 Phone: (972) 591-2493 Fax: (214) 441-9757

revisions:	no.	date	by	description
date:	11-20-20	scale:	-	dr. by:
				chk. by:
drawing no.	20-95T			
sheet	1 of 47			

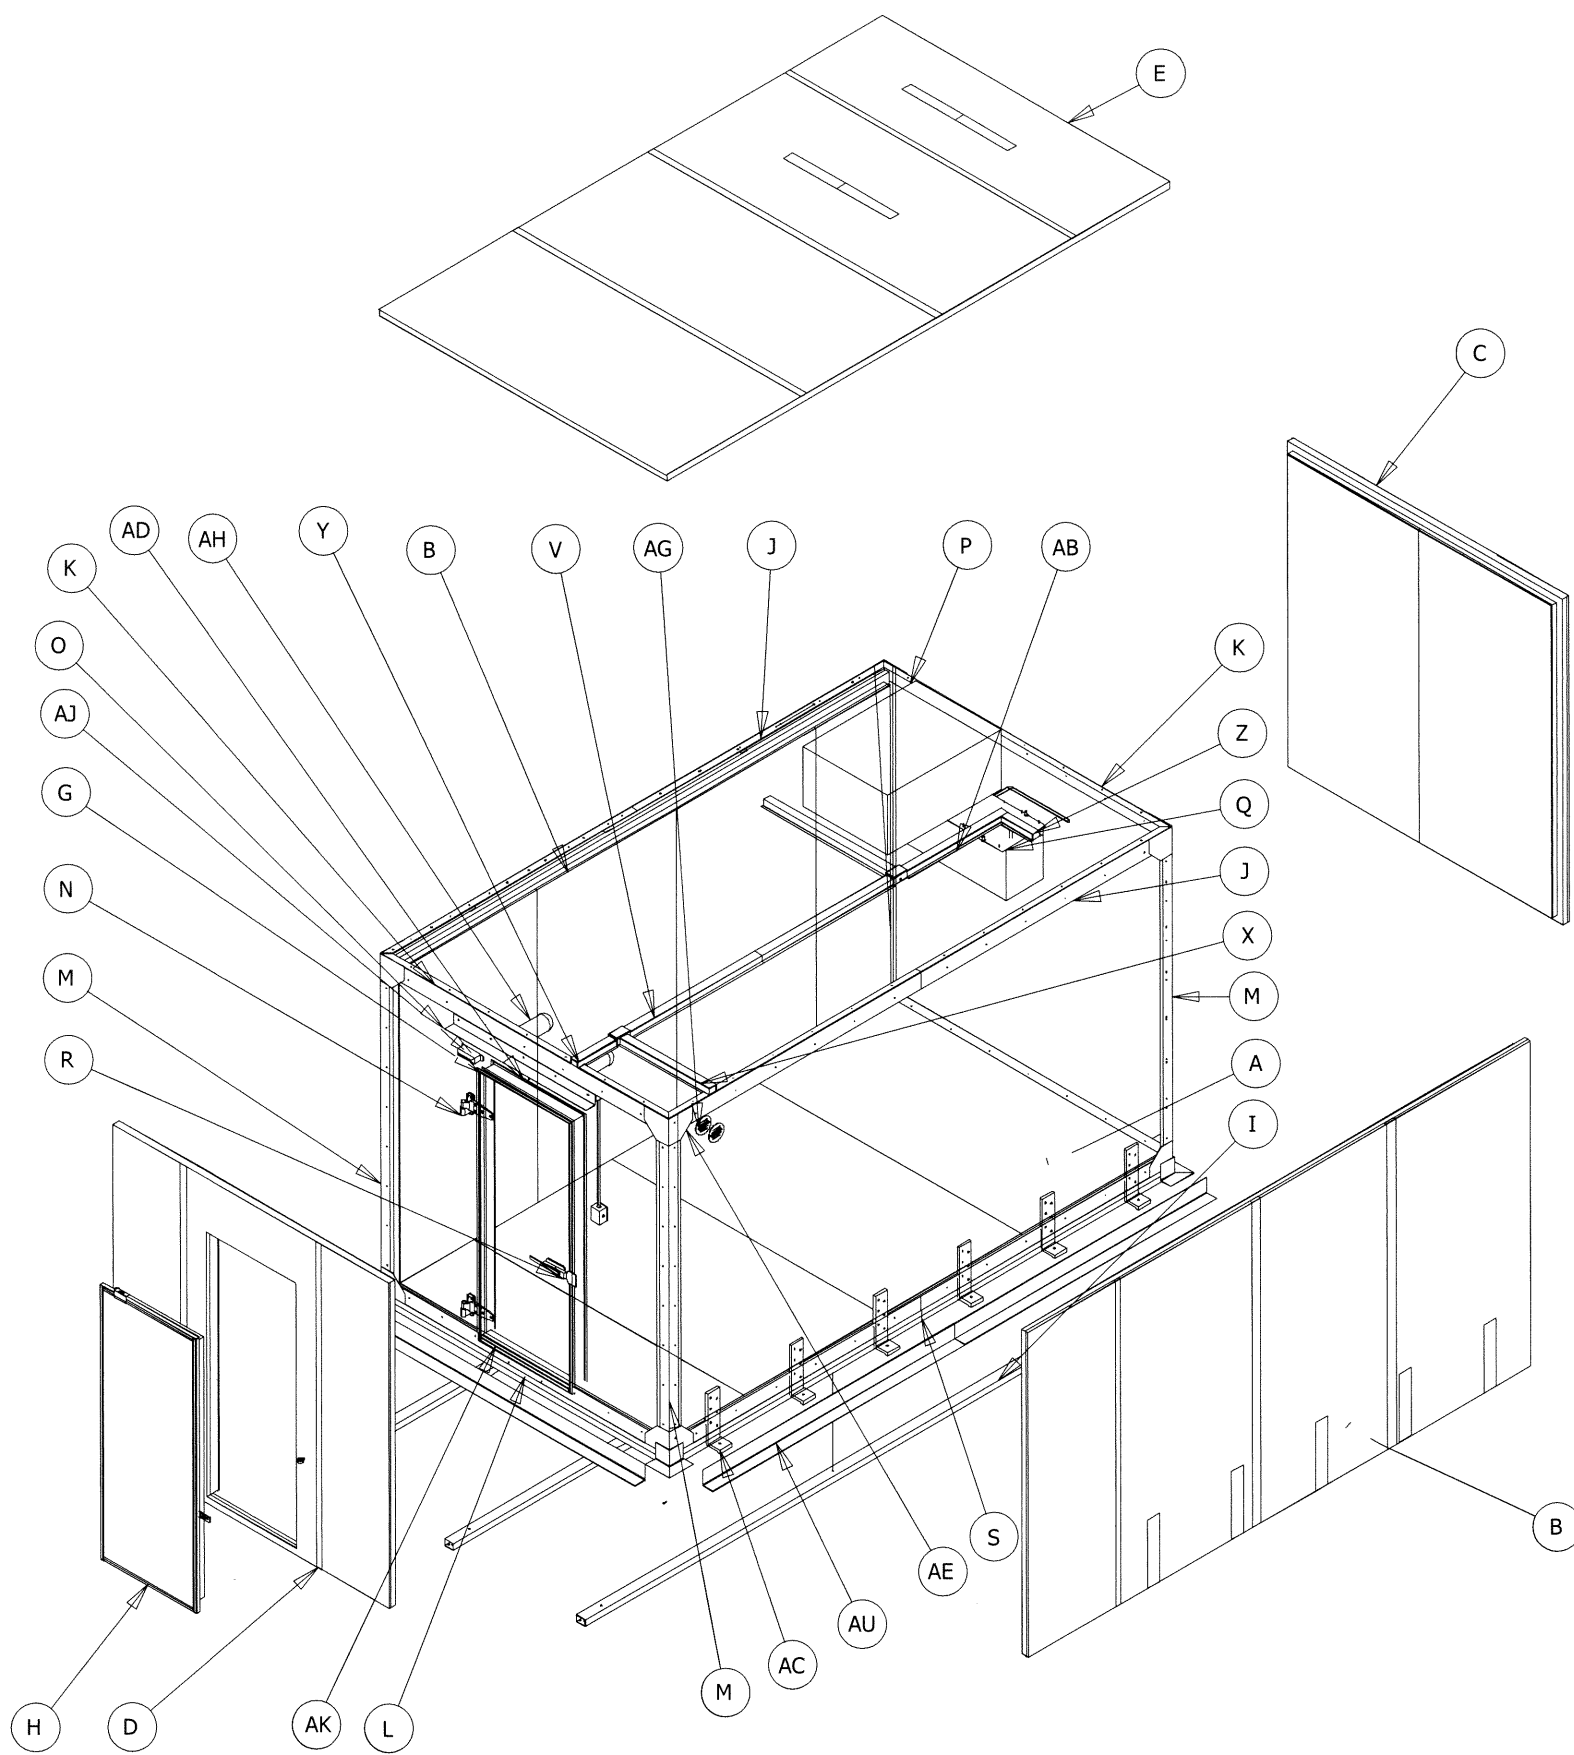


PARTS LIST			
ITEM	QTY	PART NUMBER	DESCRIPTION
A	1	FLOOR	SEE DRAWING
B	2	SIDE WALL PANEL	SEE DRAWING
C	1	REAR ANEL	SEE DRAWING
D	1	FRONT PANEL	SEE DRAWING
E	1	CEILING PANEL	SEE DRAWING
G	1	DOOR FRAME	SEE DRAWING
H	1	DOOR	SEE DRAWING
I	3	FLOOR SUPPORT	SEE DRAWING
J	8	LARGE HORIZONTAL CORNER	GALVANIZED STEEL SHEET GAUGE 18
K	3	SHORT HORIZONTAL CORNER	GALVANIZED STEEL SHEET GAUGE 18
L	1	DOOR LOWER CORNER	GALVANIZED STEEL SHEET GAUGE 18
M	4	VERTICAL CORNER	GALVANIZED STEEL SHEET GAUGE 18
N	2	HINGES	REVERSIBLE CAM-RISE HINGES KASON MODEL 1245
O	1	WATER DEFLECTOR	ALUMINUM SHEET GAUGE 14
P	1	CONDENSING UNIT	CONDENSING UNTIL HEATCRAFT-BOHN 1.5HP LOW TEMP MODEL:BHT019L6B
Q	1	UNIT COOLER (EVAPORATOR)	EVAPORATOR BOHN-HEATCRAFT MODEL LET 120BK
R	1	SAFEGUARD LATCH AND ROLLER STRIKE	KASON MODEL 56
S	4	LOWER HORIZONTAL CORNER	GALVANIZED STEEL SHEET GAUGE 14
T	2	LOWER SUPPORT	GALVANIZED STEEL SHEET GAUGE 14
V	1	OMEGA SHAPE COVER TYPE B1	GALVANIZED STEEL SHEET GAUGE 18
W	1	OMEGA SHAPE COVER TYPE 1300	SEE DRAWING
X	1	OMEGA SHAPE COVER TYPE 600	GALVANIZED STEEL SHEET GAUGE 18
Y	1	OMEGA SHAPE COVER TYPE B2	GALVANIZED STEEL SHEET GAUGE 18
Z	1	OMEGA SHAPE COVER TYPE C	GALVANIZED STEEL SHEET GAUGE 18
AA	1	PIPE COVER TYPE A	GALVANIZED STEEL SHEET GAUGE 18
AB	1	OMEGA SHAPE COVER TYPE D	GALVANIZED STEEL SHEET GAUGE 18
AE	8	CORNER	GALVANIZED STEEL SHEET GAUGE 18
AG	1	PRESSURE RELIEF PORT	KASON MODEL 1830
AH	2	COMPACT FLOURECENT LIGHTING	LITHONIA LIGHTNING MODEL VC150IM12
AJ	1	DOOR CLOSER	PHILLIPS MODEL 1404
AK	1	DOOR THRESHOLD	, 40"X4" MOLDED ALUMINUM
AL	1	PIPE COVER TYPE A	GALVANIZED STEEL SHEET GAUGE 18
AM	1	PIPE COVER TYPE B	SEE DRAWING
AC	12	ANCHOR	SEE DRAWING
AU	4	ANCHOR ANGLES	GALVANIZED STEEL SHEET GAUGE 18

af c
AL-FAROOQ CORPORATION
 ENGINEERS & PRODUCT DEVELOPMENT
 9360 SUNSET DRIVE, SUITE 220 (C.A.N. 3538)
 MIAMI, FLORIDA 33173
 TEL. (305) 264-8100 FAX. (305) 262-6978
 COOLER 20-95T-BUS






WALK-IN COOLER & FREEZER
Barcel USA LLC.
 301 Northpoint Drive, Suite 100
 Coppell, TX 75019
 Phone: (972) 591-2493 Fax: (214) 441-9757

revisions:	no	date	by	description

date: 11-20-20
 scale: -
 dr. by: -
 chk. by:

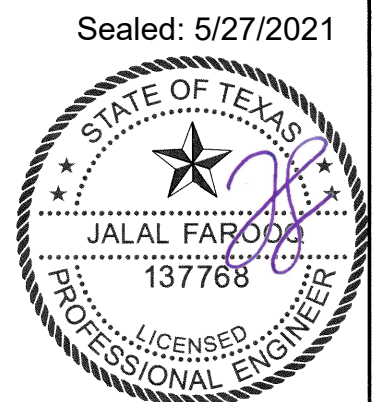

drawing no.
20-95T
 sheet 2 of 47

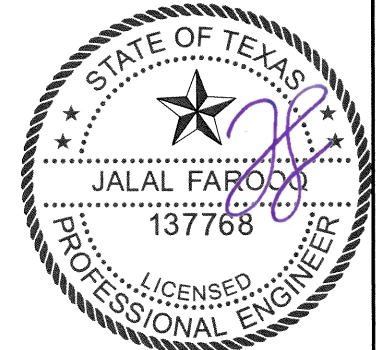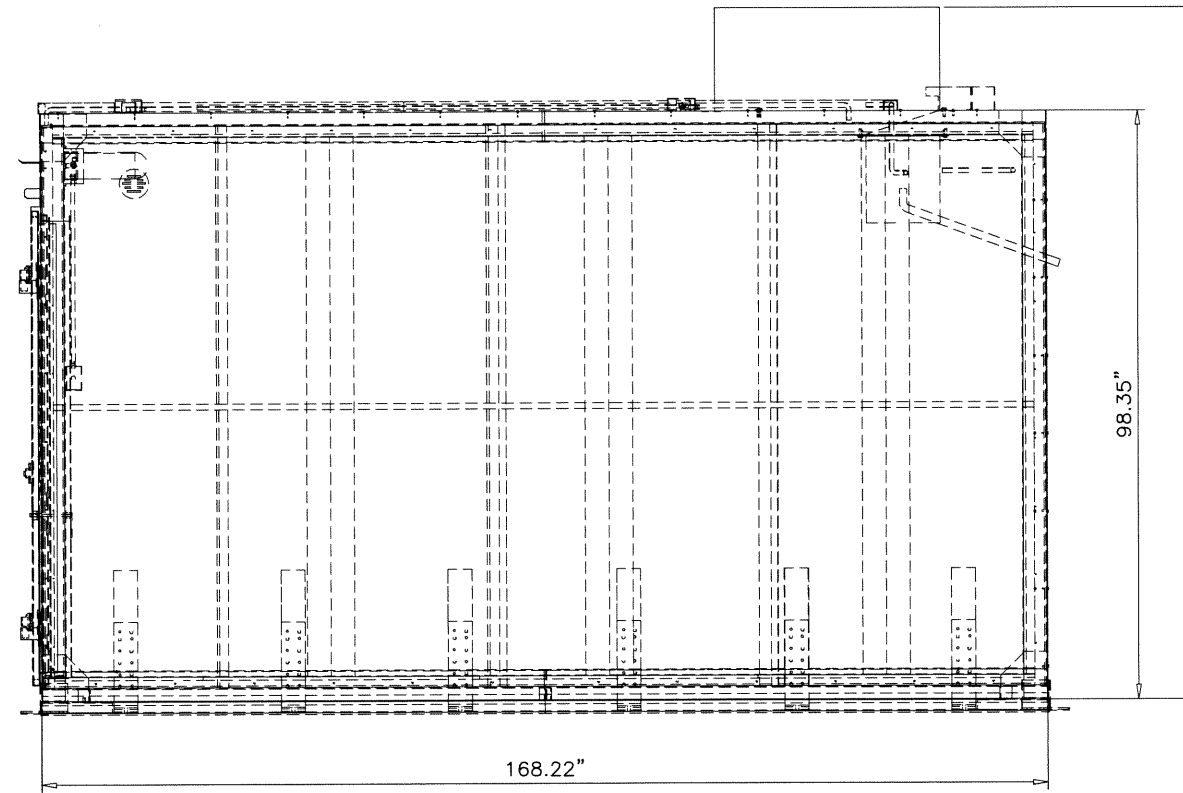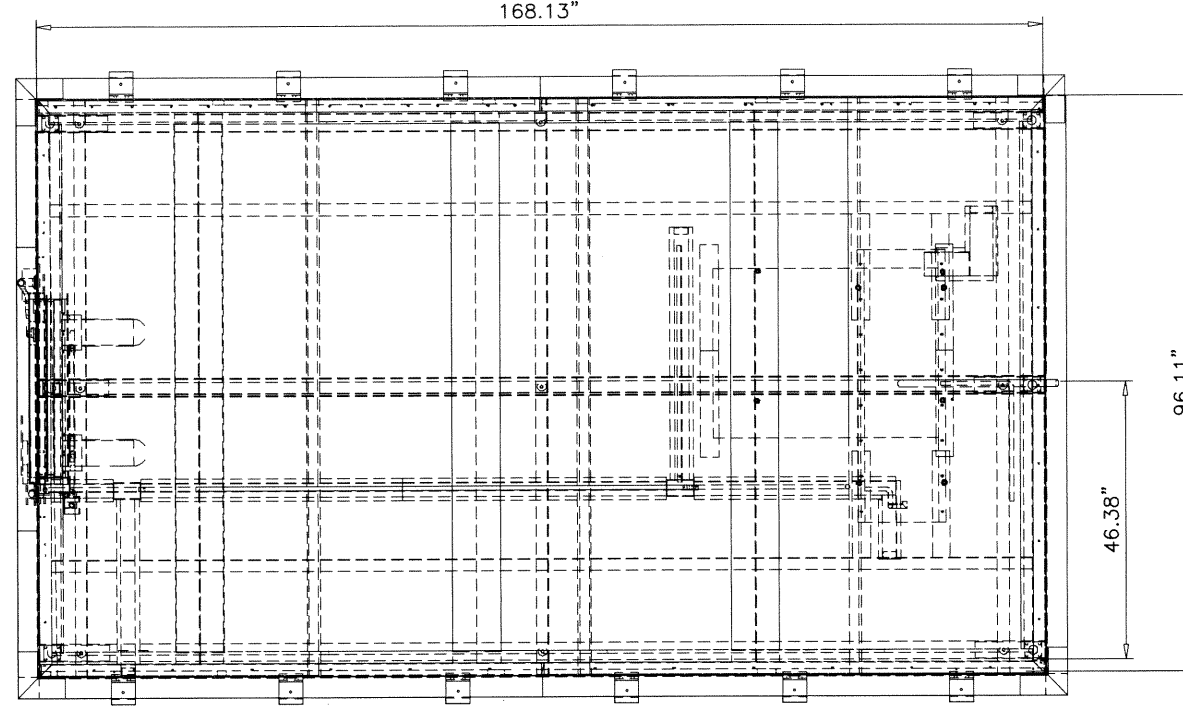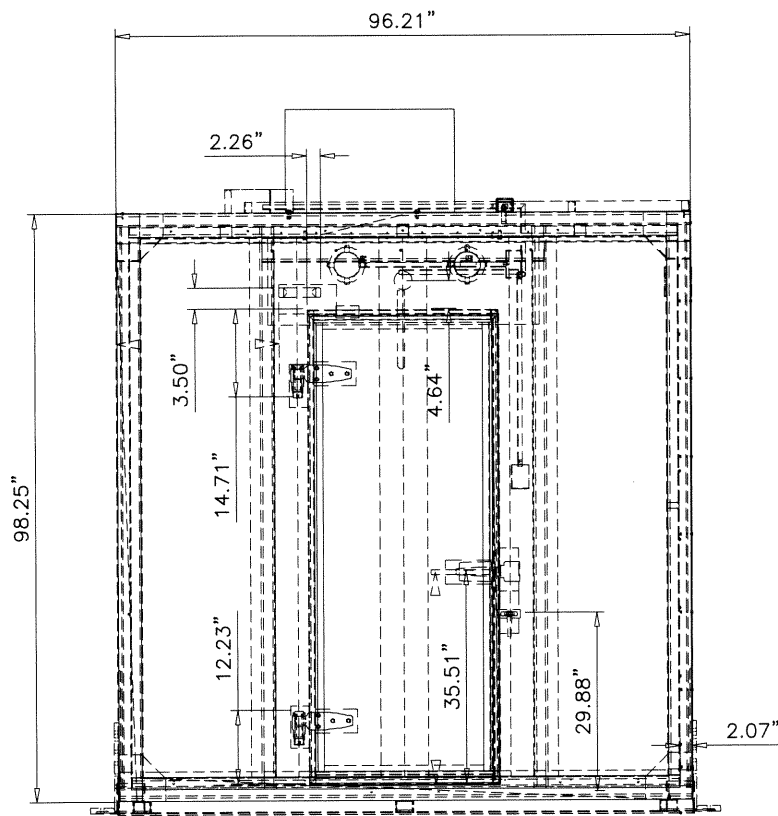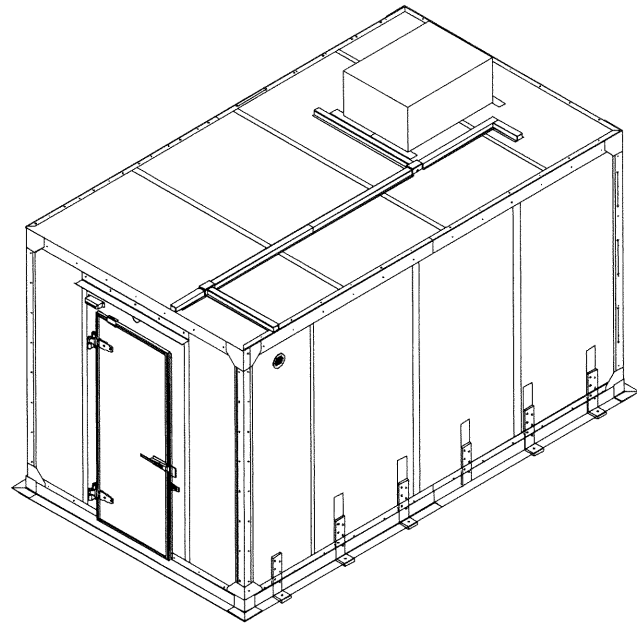

Sealed: 5/27/2021


revisions:	
no	date by description

date: 11-20-20
 scale: 3/8"=1'-0"
 dr. by: -
 chk. by:


WALK-IN COOLER & FREEZER
Barcel USA LLC.
 301 Northpoint Drive, Suite 100
 Coppell, TX 75019
 Phone: (972) 591-2493 Fax: (214) 441-9757

AL-FAROOQ CORPORATION
 ENGINEERS & PRODUCT DEVELOPMENT
 9360 SUNSET DRIVE, SUITE 220
 MIAMI, FLORIDA 33173 (C.A.N. 3538)
 TEL. (305) 264-8100 FAX. (305) 262-6978
 COOLER\20-95T-BUS


drawing no.
20-95T
 sheet 3 of 47

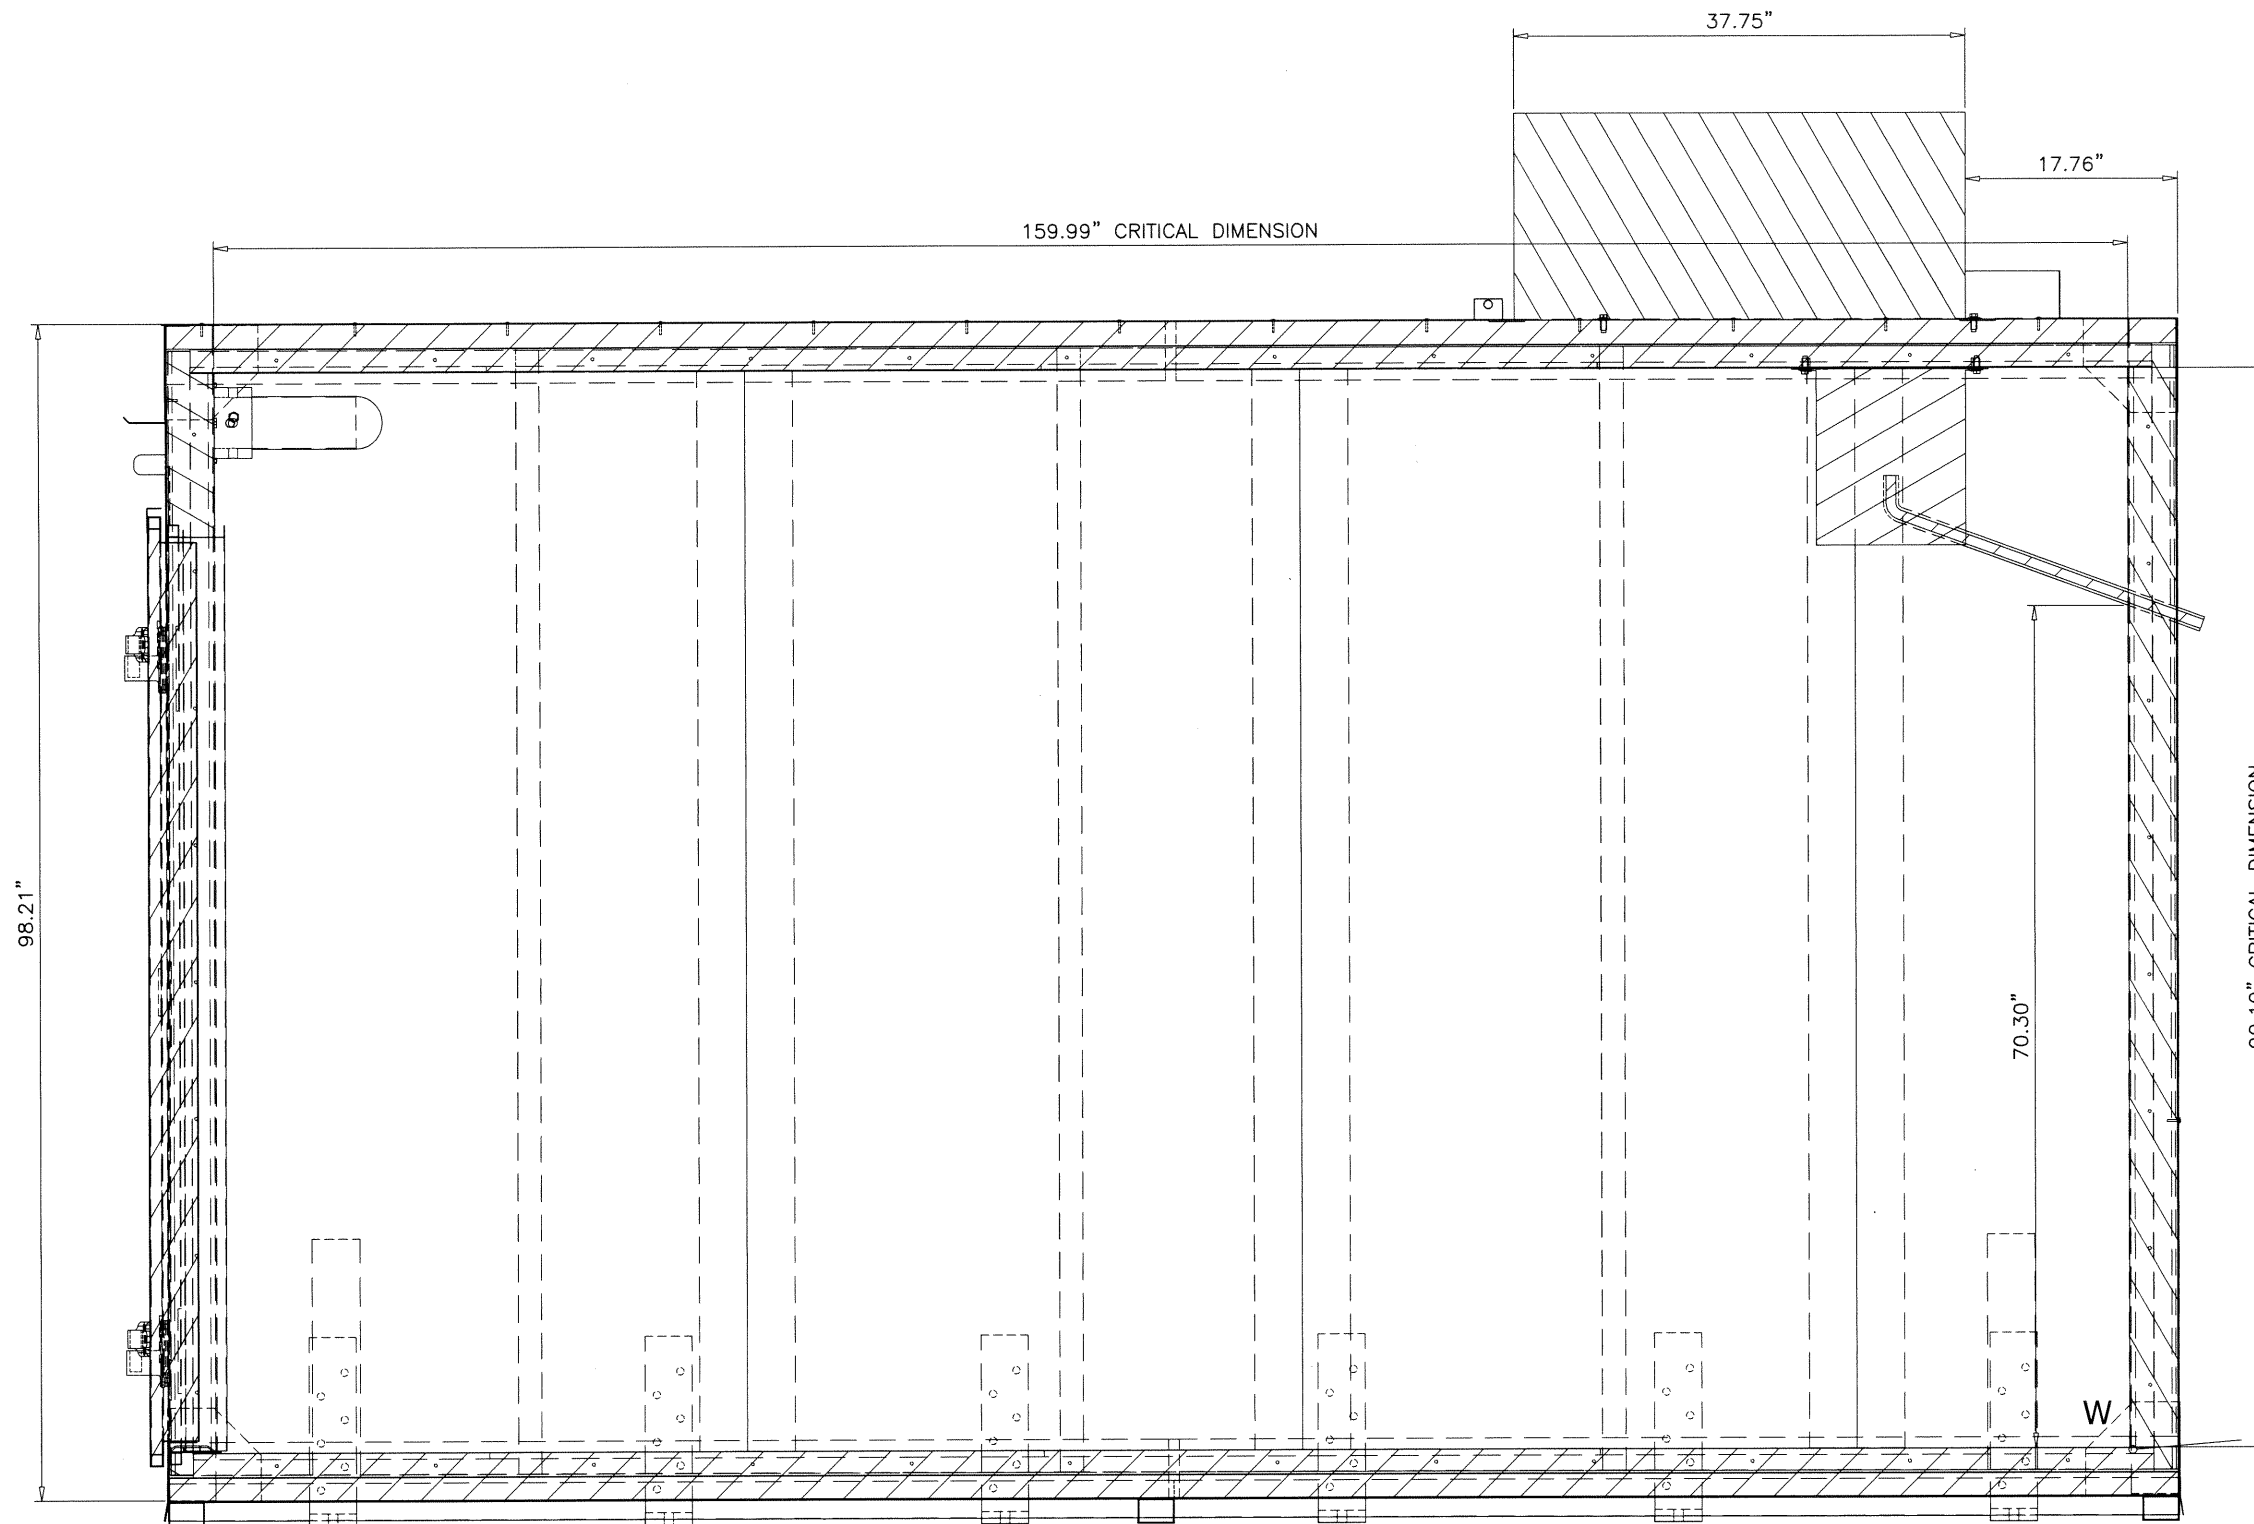

DETAIL W
UNION OF PANEL TO 90°

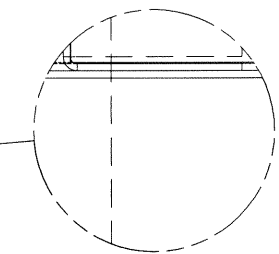



Sealed: 5/27/2021

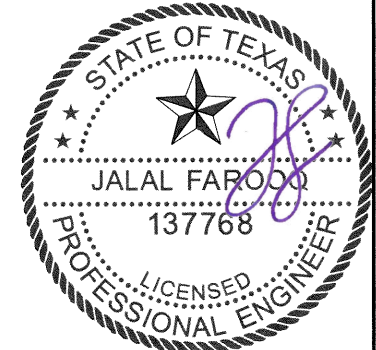


af c AL-FAROOQ CORPORATION ENGINEERS & PRODUCT DEVELOPMENT 9360 SUNSET DRIVE, SUITE 220 MIAMI, FLORIDA 33173 (C.A.N. 3538) TEL. (305) 264-8100 FAX. (305) 262-6978 COOLER\20-95T-BUS	WALK-IN COOLER & FREEZER Barcel USA LLC. 301 Northpoint Drive, Suite 100 Coppell, TX 75019 Phone: (972) 591-2493 Fax: (214) 441-9757	date: 11-20-20 scale: 3/4"=1'-0" dr. by: - chk. by:	revisions: <table border="1" style="width: 100%; border-collapse: collapse;"> <thead> <tr> <th style="width: 5%;">no</th> <th style="width: 15%;">date</th> <th style="width: 80%;">description</th> </tr> </thead> <tbody> <tr><td> </td><td> </td><td> </td></tr> <tr><td> </td><td> </td><td> </td></tr> <tr><td> </td><td> </td><td> </td></tr> <tr><td> </td><td> </td><td> </td></tr> </tbody> </table>	no	date	description													drawing no. 20-95T sheet 4 of 47
no	date	description																	

RIGID XPS FOAM (EXTRUDED POLYSTYRENE)
 OF 30 KG/M³ DENSITY,
 WITH COMPRESSION STRENGTH OF 25 LBS/IN.

EXTERIOR FINISH:
 WHITE PAINTED (PINTRO)
 GALV. STEEL SHEET

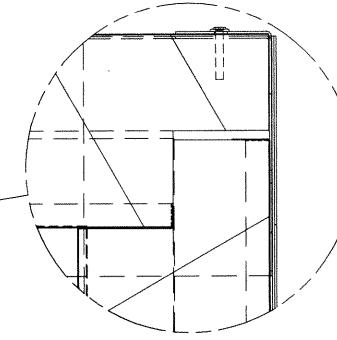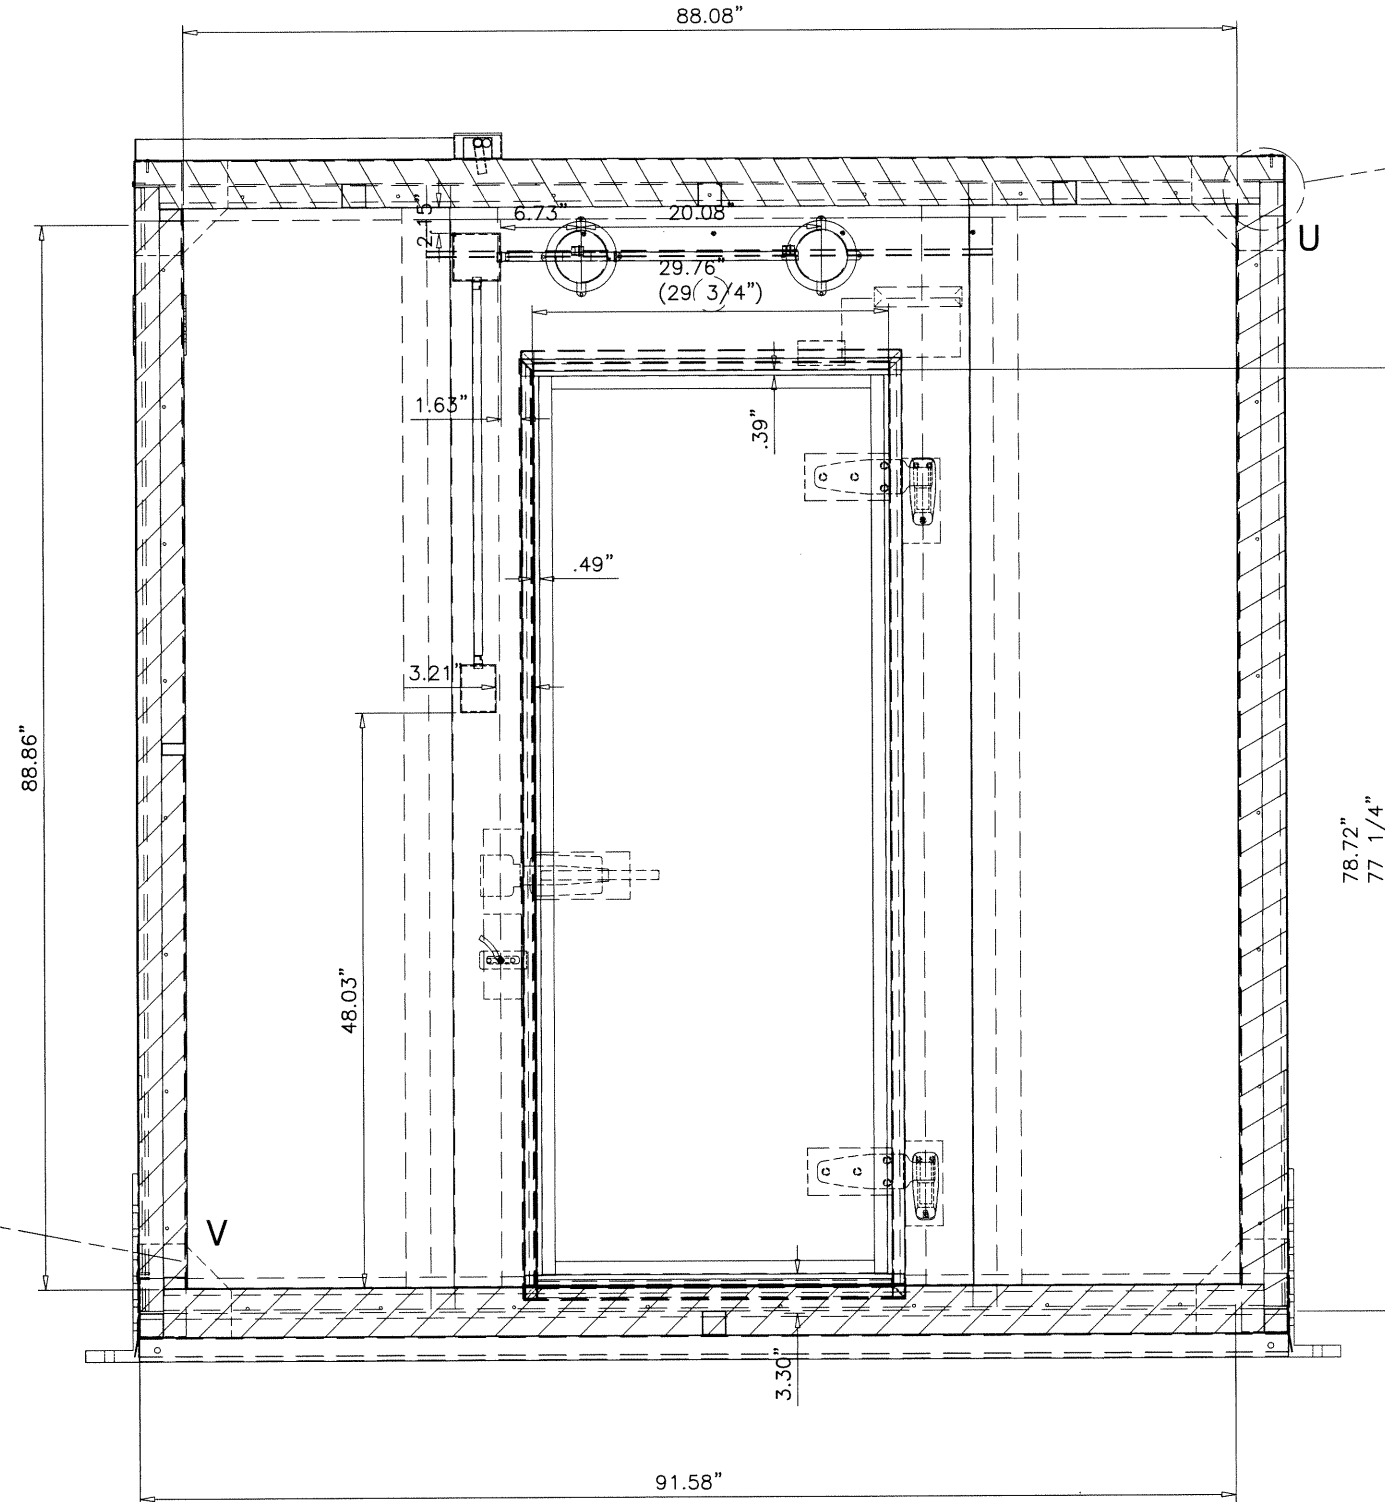


DETAIL U

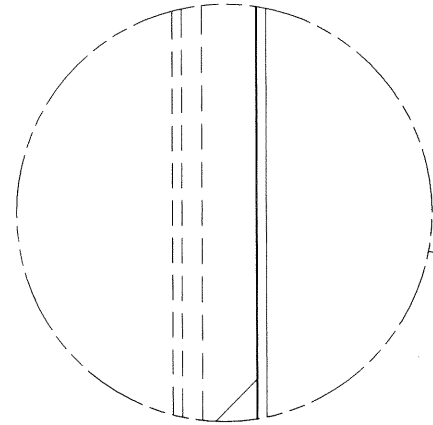

DETAIL V
 UNION OF PANEL
 TO 90°

Sealed: 5/27/2021

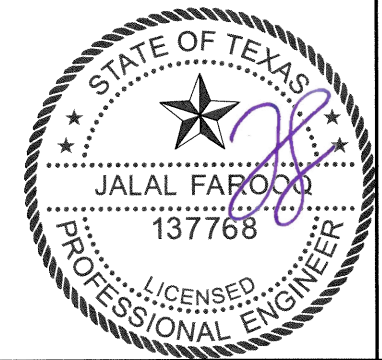

no	date	by	description

date: 11-20-20
 scale: 3/4"=1'-0"
 dr. by: -
 chk. by: -

drawing no.
20-95T

sheet **5** of **47**


WALK-IN COOLER & FREEZER

Barcel USA LLC.
 301 Northpoint Drive, Suite 100
 Coppell, TX 75019
 Phone: (972) 591-2493 Fax: (214) 441-9757

AL-FAROOQ CORPORATION
 ENGINEERS & PRODUCT DEVELOPMENT
 9360 SUNSET DRIVE, SUITE 220
 MIAMI, FLORIDA 33173 (C.A.N. 3538)
 TEL. (305) 264-8100 FAX. (305) 262-6978

afc
 COOLER\20-95T-BUS

PARTS LIST		
ITEM QTY	PART NUMBER	DESCRIPTION
A	1	FLOOR
A1	1	FLOOR PANEL FOAM CORE XPS CORE WITH A THICKNESS OF 4", AND 30 KG/M3 DENSITY
A2	3	INTERIOR FLOOR SHEET ALUMINUM (3003) SHEET GAUGE 14
A3	1	EXTERIOR FLOOR SHEET WHITE PAINTED GALVANIZED GAUGE 26 TERNIUM ZINTRO G60
A4	3	INNER FLOOR REINFORCEMENT 2" X 2" CARBON STEEL TUBE GAUGE 18
A5	3	INNER SUPPORT SHEET GALVANIZED STEEL SHEET GAGE 26
A6	1	SHORT INNER FLOOR SHEET ALUMINUM (3003) SHEET GAUGE 14
A7	1	SHORT EXTERIOR FLOOR SHEET WHITE PAINTED GALVANIZED STEEL SHEET GAUGE 26 TERNIUM ZINTRO G60

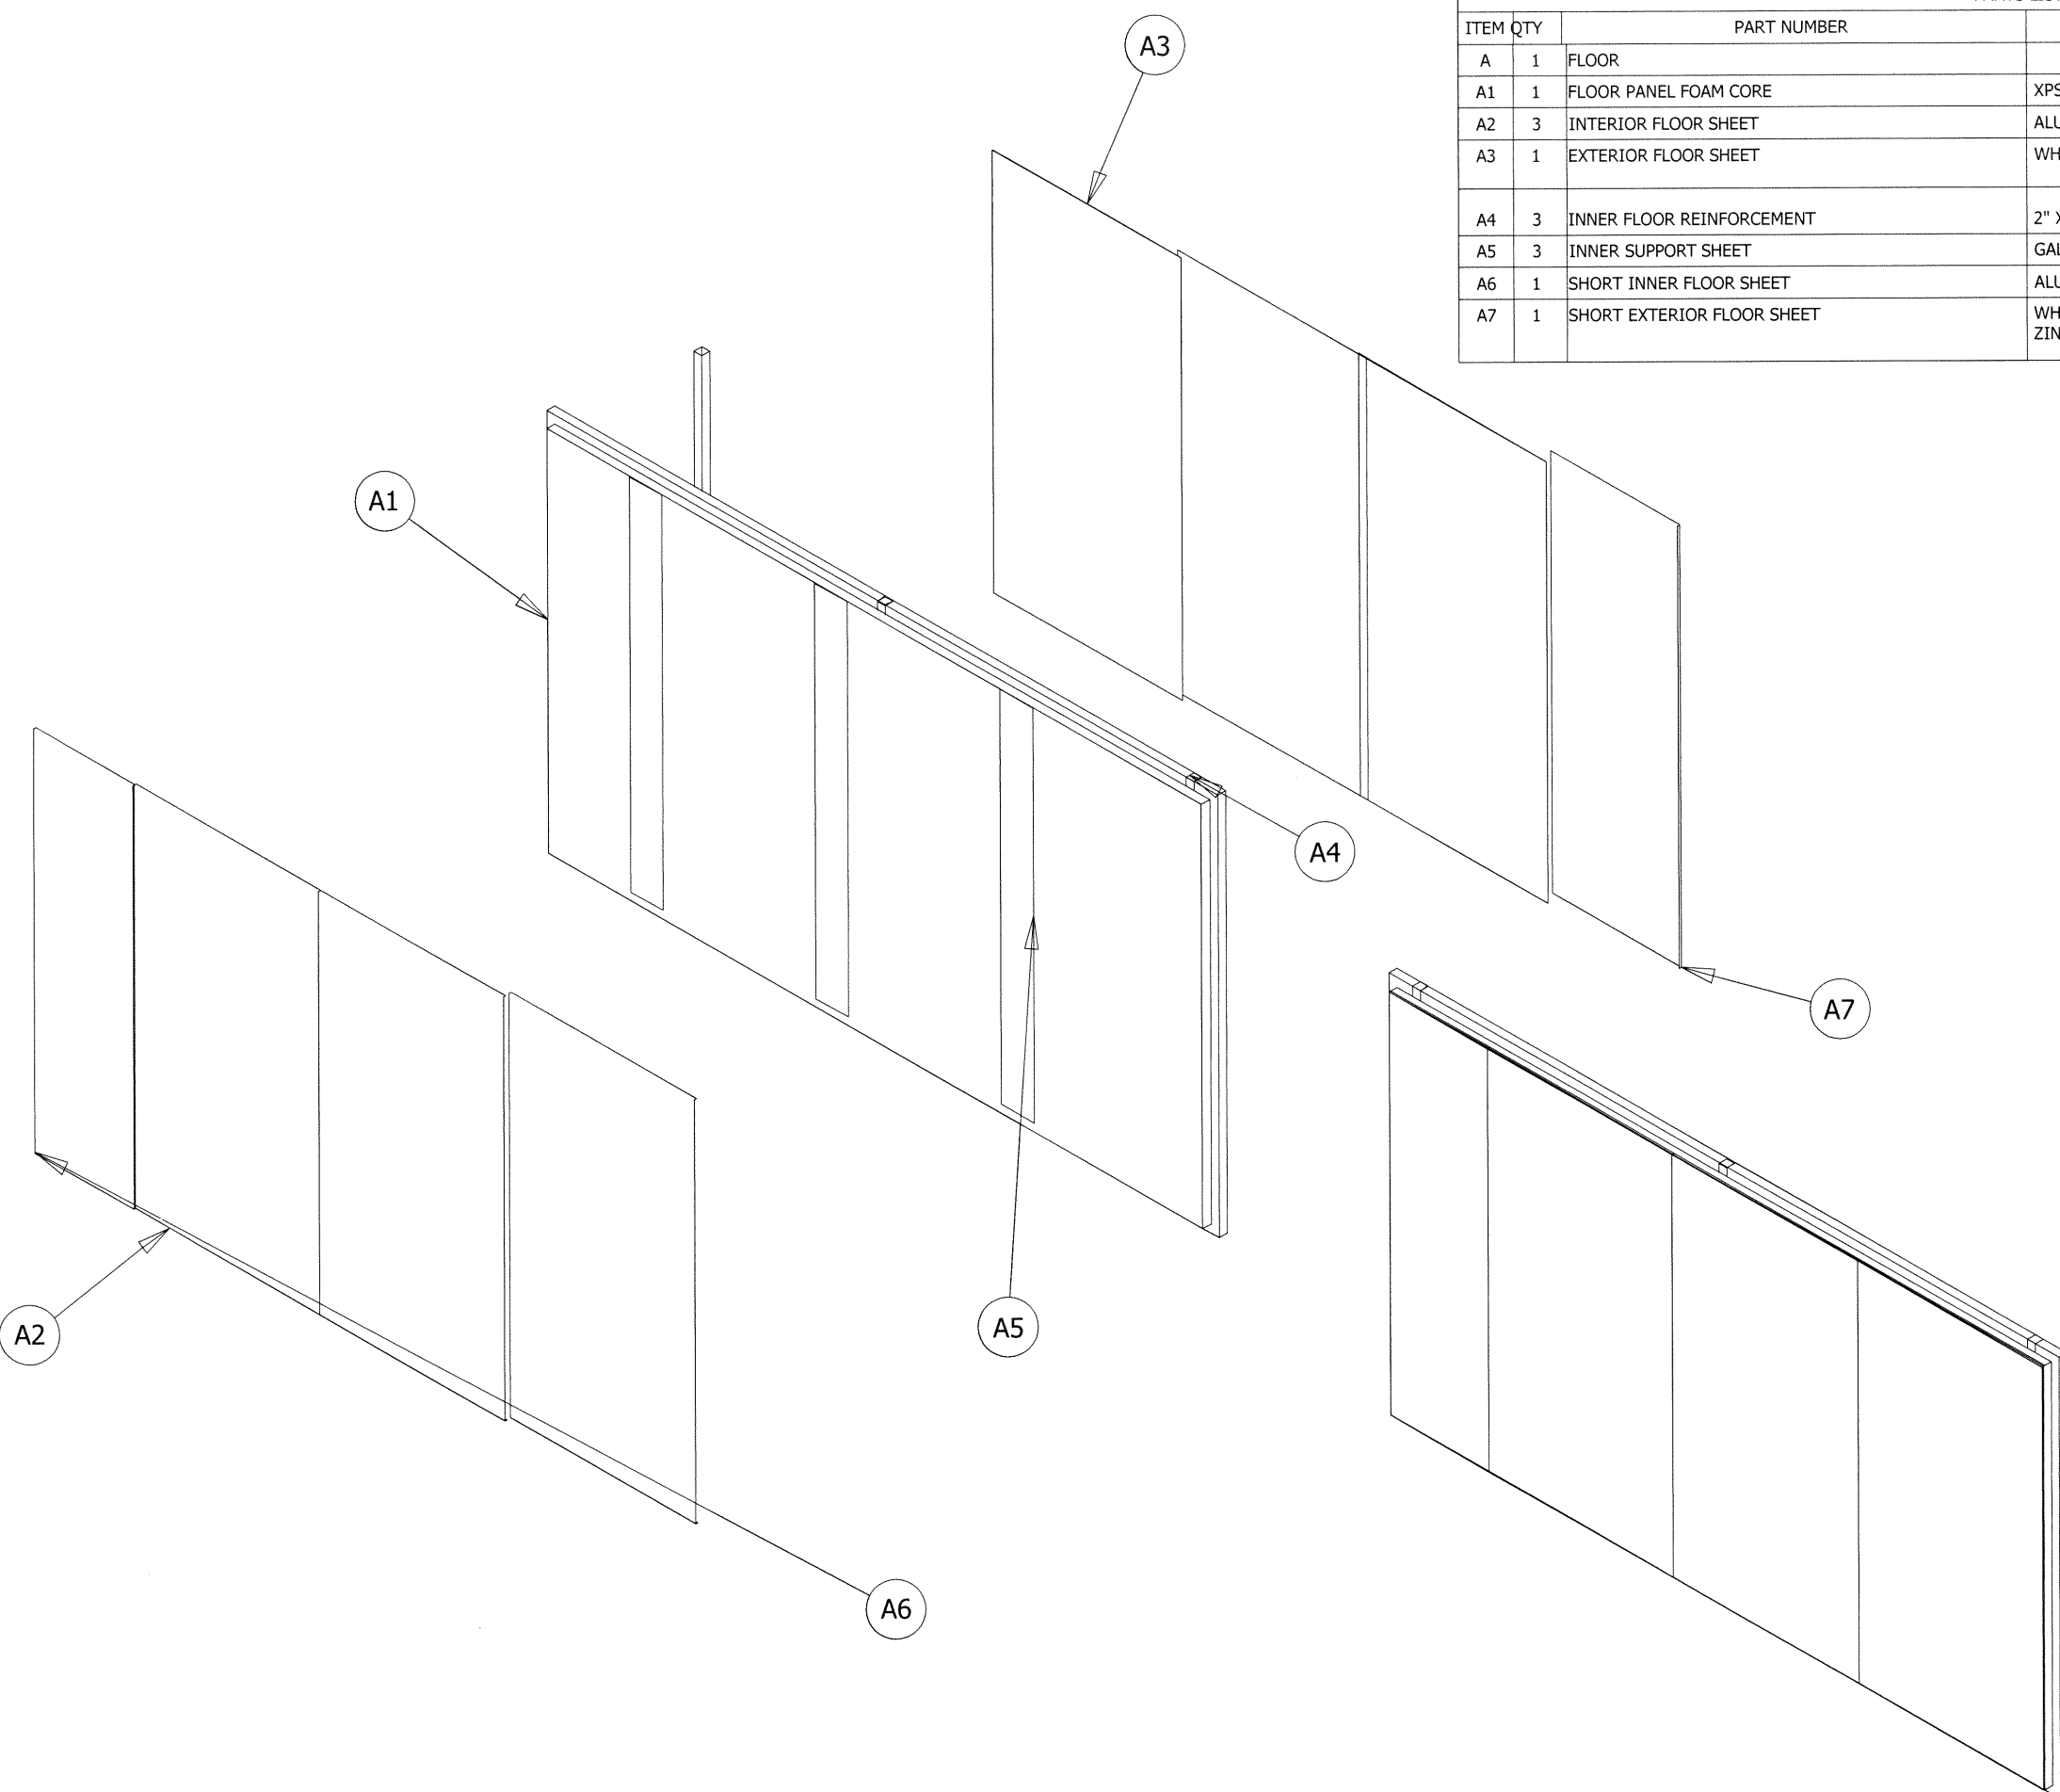

RIGID XPS FOAM (EXTRUDED POLYSTYRENE)
OF 30 KG/M³ DENSITY,
WITH COMPRESSION STRENGTH OF 25 LBS/IN.


EXTERIOR FINISH:
WHITE PAINTED (PINTRO)
GALV. STEEL SHEET

afc
AL-FAROOQ CORPORATION
ENGINEERS & PRODUCT DEVELOPMENT
9360 SUNSET DRIVE, SUITE 220 (C.A.N. 3538)
MIAMI, FLORIDA 33173
TEL. (305) 264-8100 FAX. (305) 262-6978
COOLER\20-95T-BUS


WALK-IN COOLER & FREEZER
Barcel USA LLC.
301 Northpoint Drive, Suite 100
Coppell, TX 75019
Phone: (972) 591-2493 Fax: (214) 441-9757

revisions:	no	date	by	description


date: 11-20-20
scale: -
dr. by: -
chk. by: -

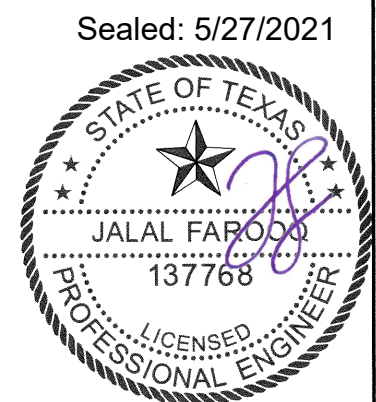

drawing no.
20-95T
sheet **6** of **47**

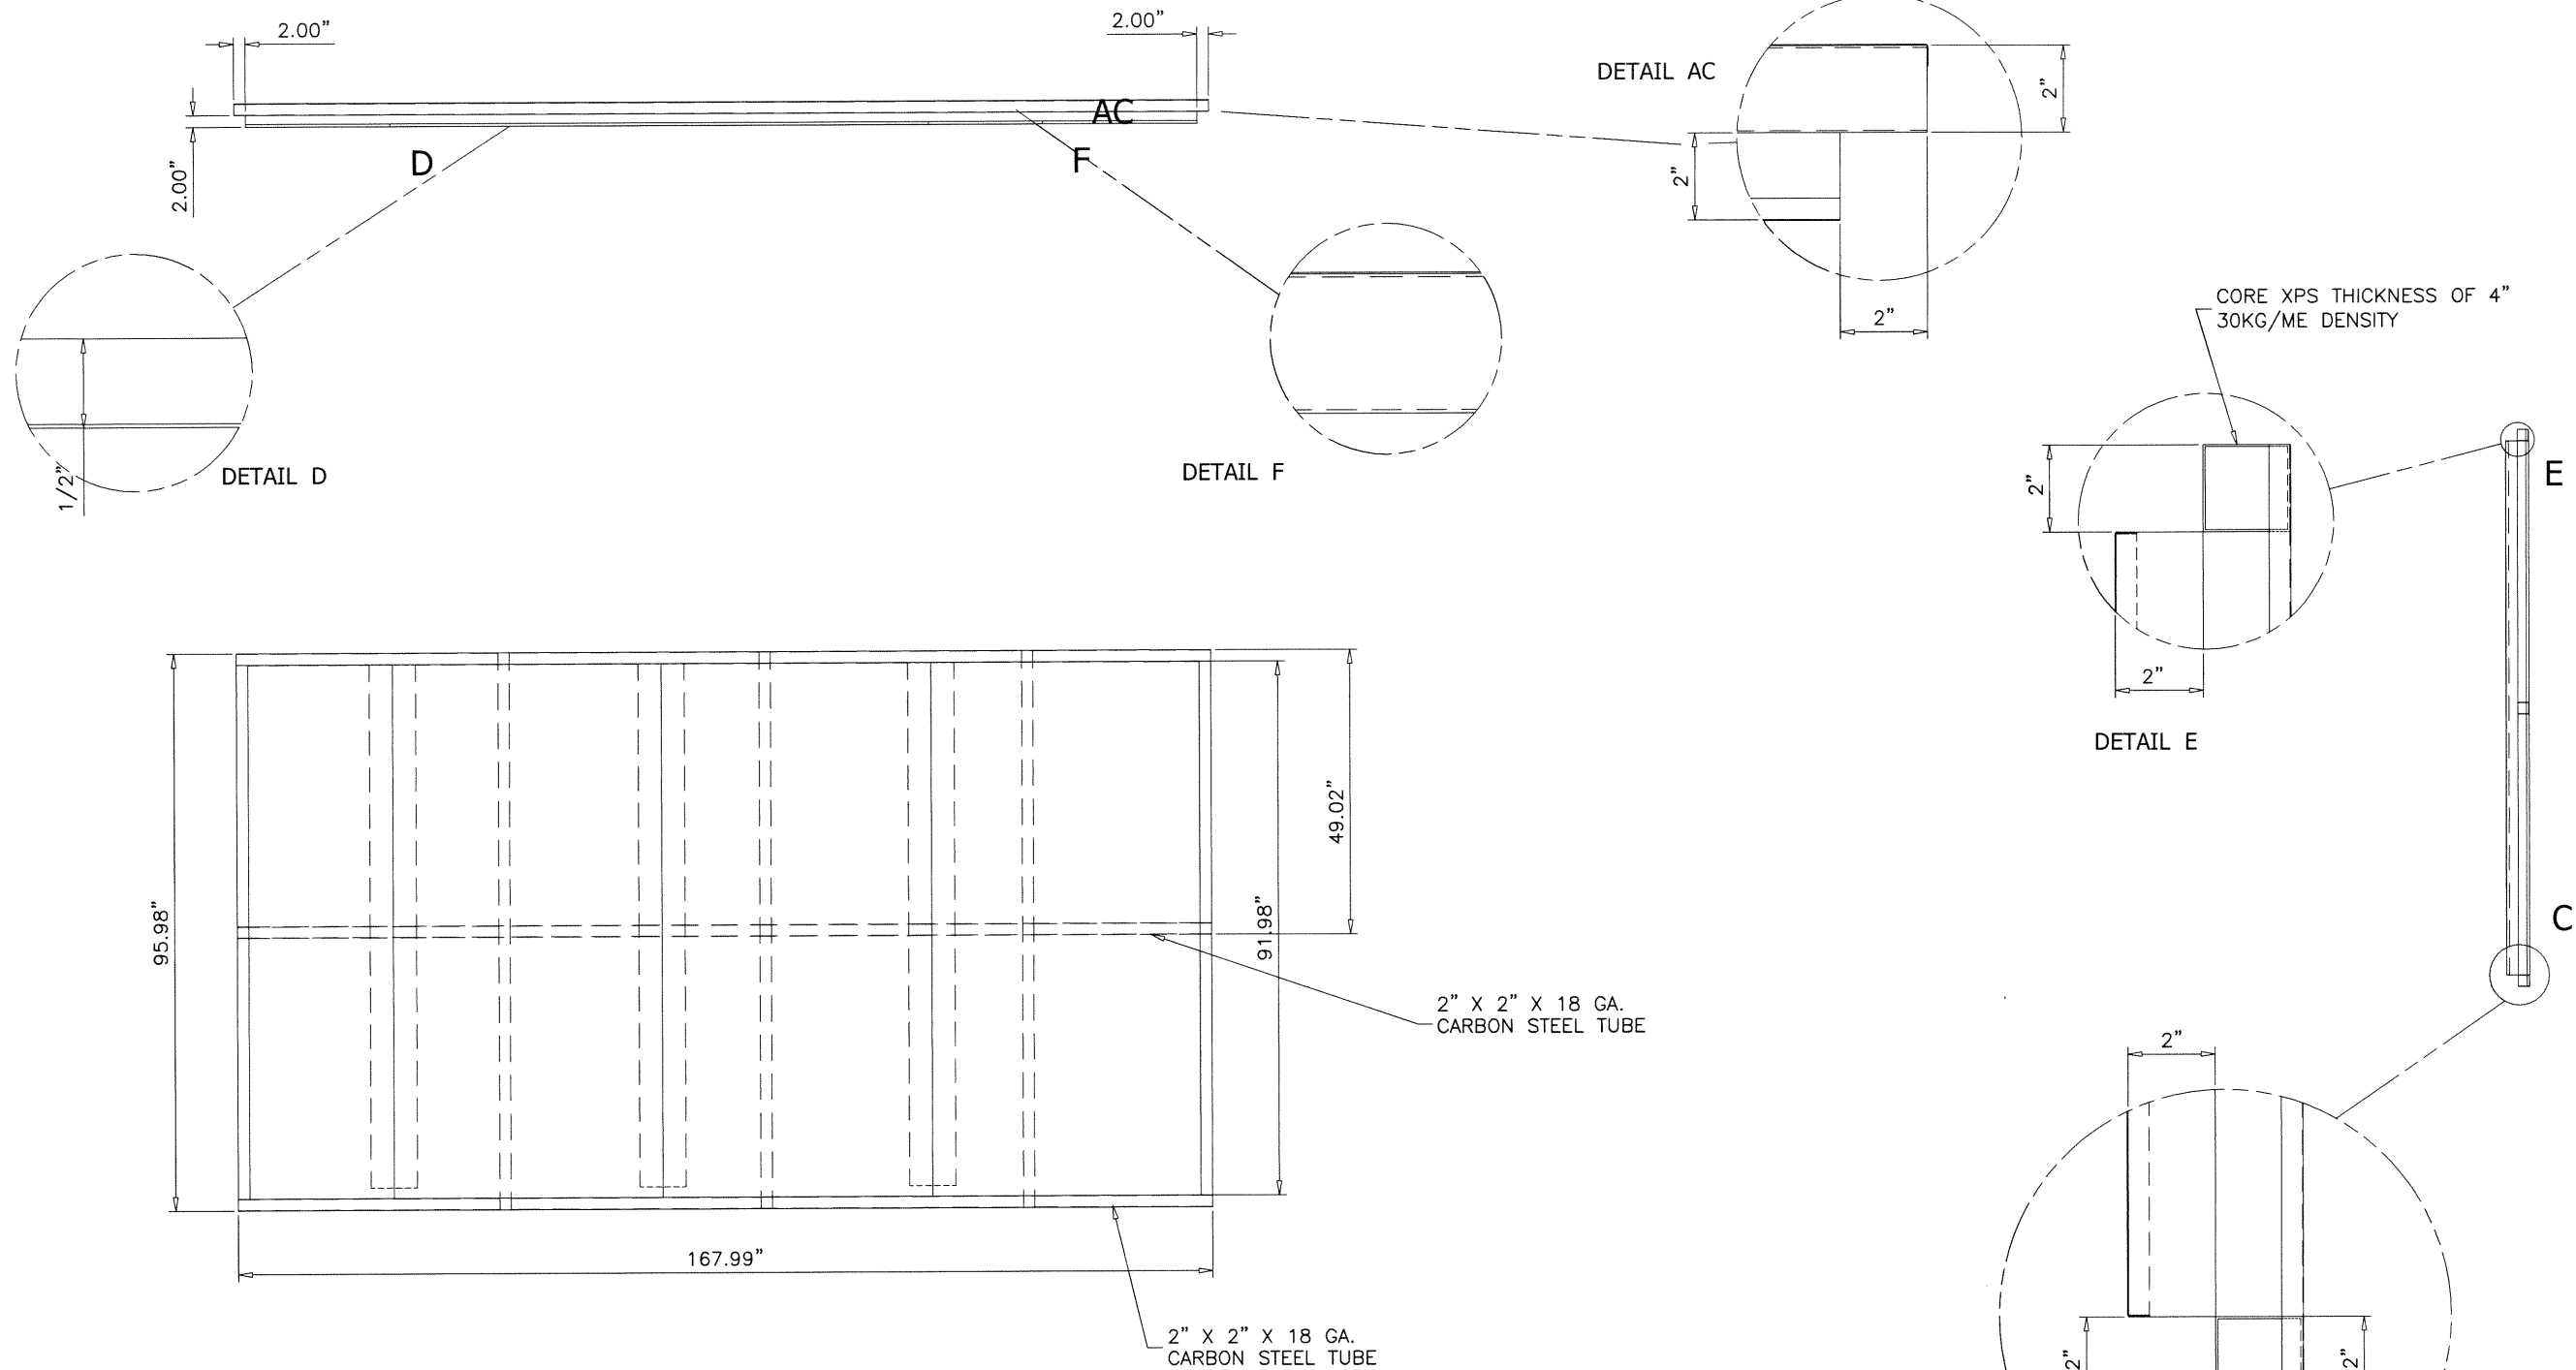


PARTS LIST			
ITEM	QTY	PART NUMBER	DESCRIPTION
A1	1	FLOOR PANEL FOAM CORE	XPS CORE WITH A THICKNESS OF 4", AND 30 KG/M3 DENSITY
A2	3	INTERIOR FLOOR SHEET	ALUMINUM (3003) SHEET GAUGE 14
A3	1	EXTERIOR FLOOR SHEET	WHITE PAINTED GALVANIZED STEEL SHEET GAUGE 26 TERNIUM ZINTRO G60
A4	3	INNER FLOOR REINFORCEMENT	2" X 2" CARBON STEEL TUBE GAUGE 18
A5	3	INNER SUPPORT SHEET	GALVANIZED STEEL SHEET GAGE 26
A6	1	SHORT INNER FLOOR SHEET	ALUMINUM (3003) SHEET GAUGE 14
A7	1	SHORT EXTERIOR FLOOR SHEET	WHITE PAINTED GALVANIZED STEEL SHEET GAUGE 26 TERNIUM ZINTRO G60

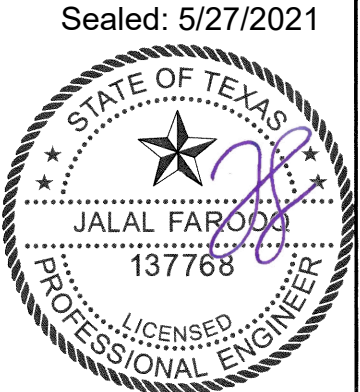


a f c
AL-FAROOQ CORPORATION
 ENGINEERS & PRODUCT DEVELOPMENT
 9360 SUNSET DRIVE, SUITE 220
 MIAMI, FLORIDA 33173 (C.A.N. 3538)
 TEL. (305) 264-8100 FAX. (305) 262-6978
 COOLER\20-95T-BUS

WALK-IN COOLER & FREEZER
Barcel USA LLC.
 301 Northpoint Drive, Suite 100
 Coppell, TX 75019
 Phone: (972) 591-2493 Fax: (214) 441-9757


revisions:	no	date	by	description
date:	11-20-20	scale:	3/8"=1'-0"	
dr. by:		chk. by:		
drawing no.	20-95T			
sheet	7 of 47			

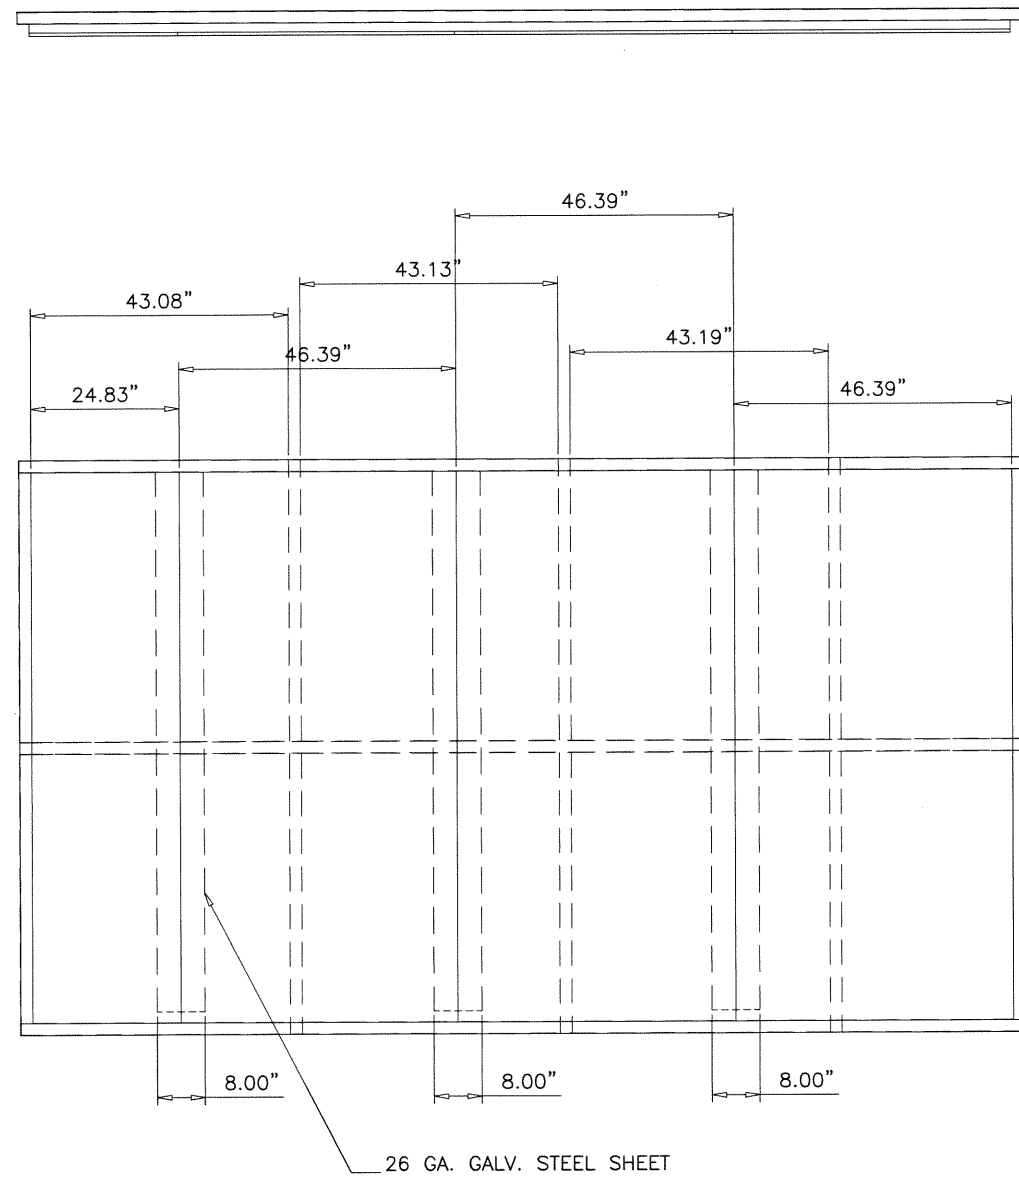

INTERIOR PART WITH
INNER SUPPORT SHEET
7.99" WIDTH

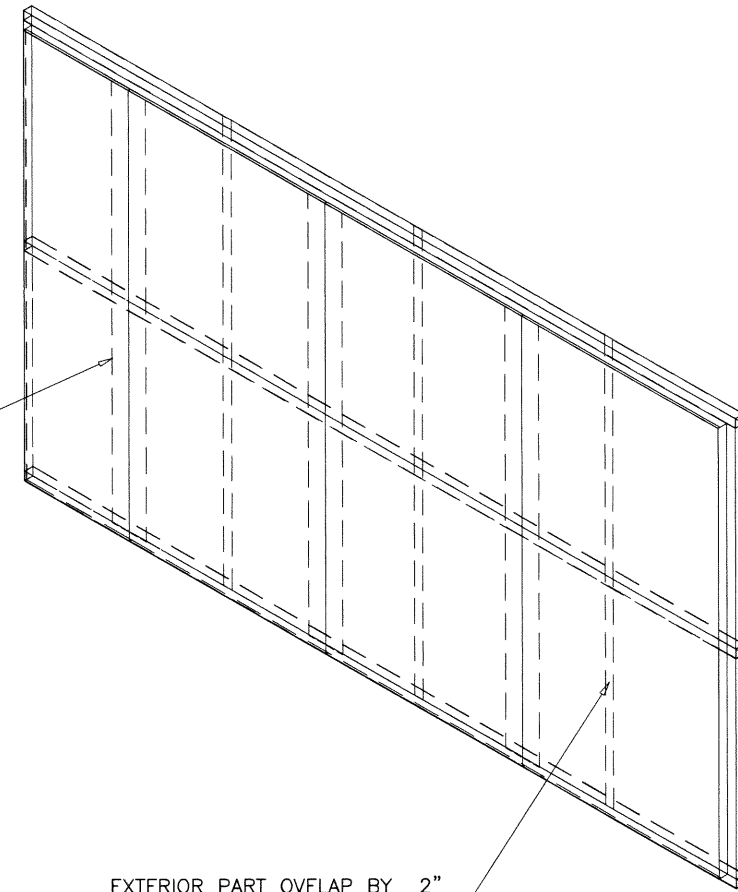

Sealed: 5/27/2021

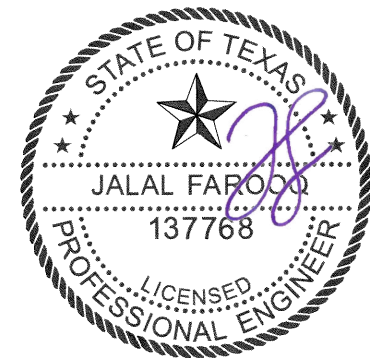

date: 11-20-20	scale: 3/8"=1'-0"	dr. by: -	chk. by:
revisions:	no	date	description

WALK-IN COOLER & FREEZER

Barcel USA LLC.
301 Northpoint Drive, Suite 100
Coppell, TX 75019
Phone: (972) 591-2493 Fax: (214) 441-9757


AL-FAROOQ CORPORATION
ENGINEERS & PRODUCT DEVELOPMENT
9360 SUNSET DRIVE, SUITE 220
MIAMI, FLORIDA 33173 (C.A.N. 3538)
TEL. (305) 264-8100 FAX. (305) 262-6978

af c


COOLER\20-95T-BUS

drawing no.
20-95T
sheet **8** of **47**


PARTS LIST			
ITEM	QTY	PART NUMBER	DESCRIPTION
A2	3	INTERIOR FLOOR SHEET	14 GA. ALUMINUM

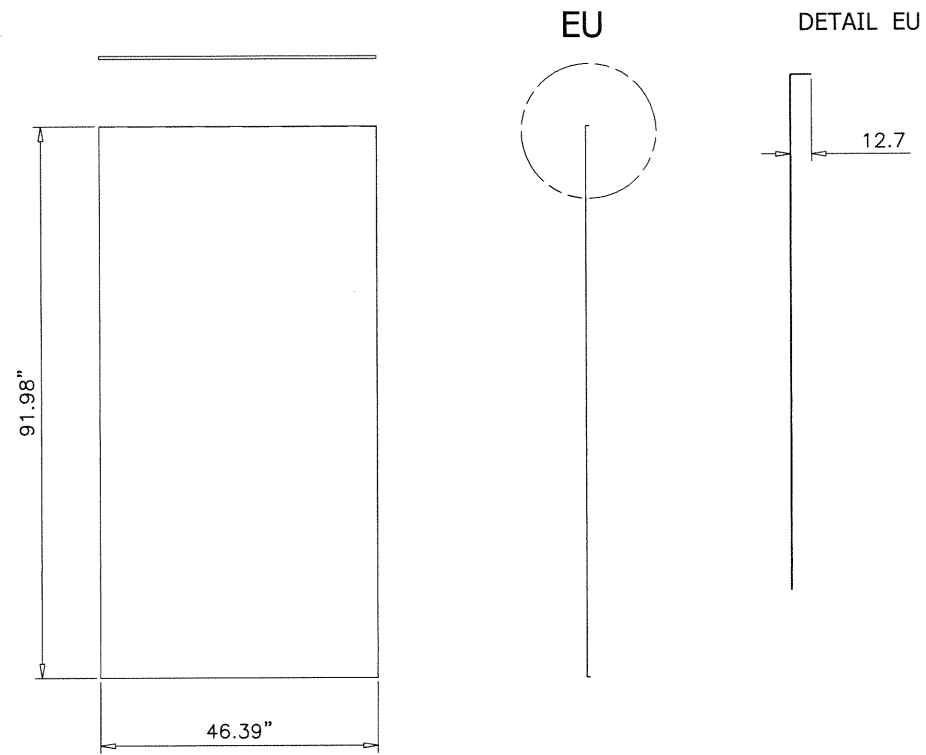



PARTS LIST			
ITEM	QTY	PART NUMBER	DESCRIPTION
A3	3	EXTERIOR FLOOR SHEET	26 GA. WHITE PAINTED GALV. STEEL

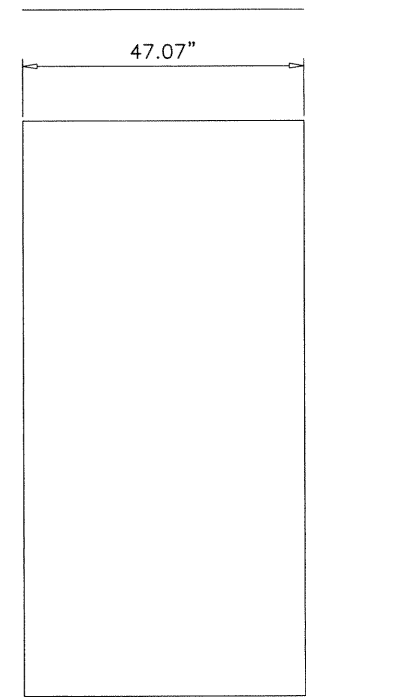

PARTS LIST			
ITEM	QTY	PART NUMBER	DESCRIPTION
A4	3	INTERIOR FLOOR REINFORCEMENT	18 GA. CARBON STEEL TUBE

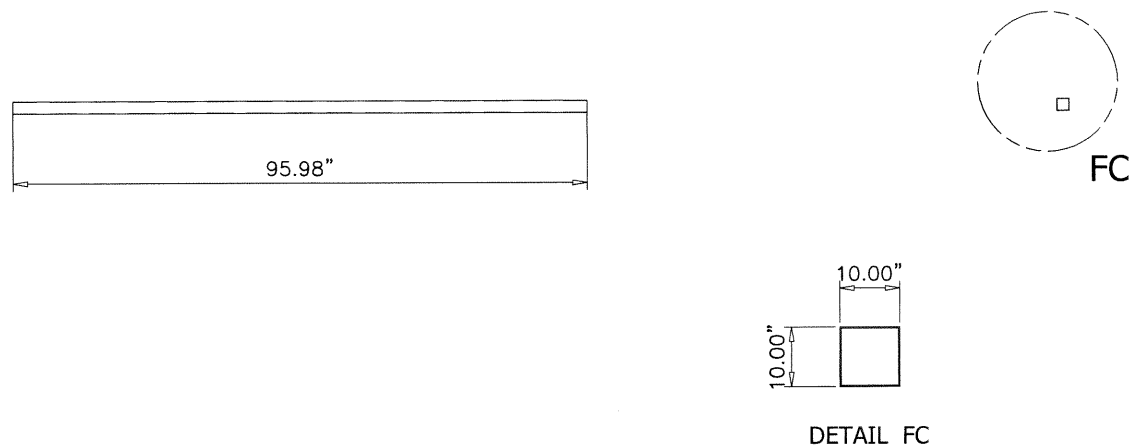

PARTS LIST			
ITEM	QTY	PART NUMBER	DESCRIPTION
A5,B5,C4	3	INNER SUPPORT SHEET	26 GA. GALV. STEEL

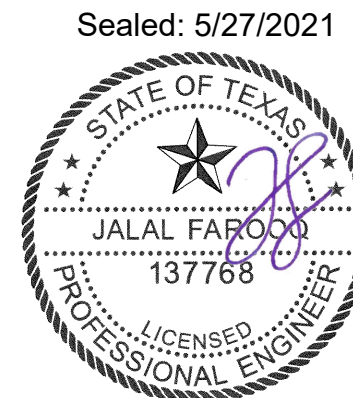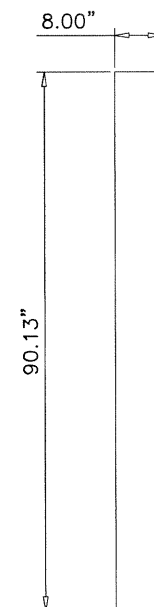

af c
AL-FAROOQ CORPORATION
 ENGINEERS & PRODUCT DEVELOPMENT
 9360 SUNSET DRIVE, SUITE 220 (C.A.N. 3538)
 MIAMI, FLORIDA 33173
 TEL. (305) 264-8100 FAX. (305) 262-6978
 COOLER\20-95T-BUS

WALK-IN COOLER & FREEZER
Barcel USA LLC.
 301 Northpoint Drive, Suite 100
 Coppell, TX 75019
 Phone: (972) 591-2493 Fax: (214) 441-9757

revisions:		date		by description	
no	date	no	date	no	description

date: 11-20-20
 scale: 3/8"=1'-0"
 dr. by: -
 chk. by: -

drawing no.
20-95T



sheet **9** of **47**

PARTS LIST			
ITEM	QTY	PART NUMBER	DESCRIPTION
A6	1	SHORT INNER FLOOR SHEET	14 GA. ALUMINUM SHEET


PARTS LIST			
ITEM	QTY	PART NUMBER	DESCRIPTION
A7	1	SHORT FLOOR EXTERIOR SHEET	26 GA. WHITE PAINTED GALV. STEEL



DETAIL EY

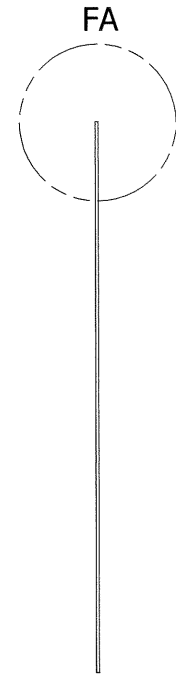
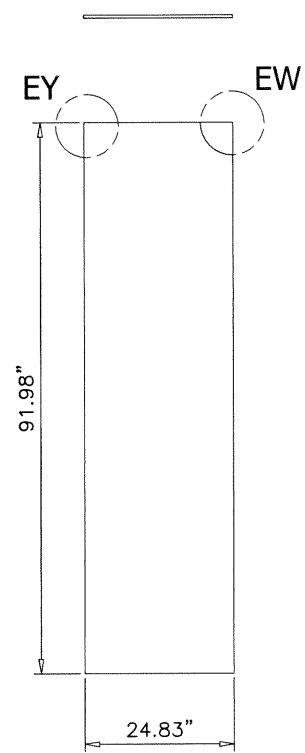


DETAIL EW

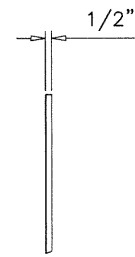


DETAIL FA

NOTE: DO NOT MAKE FOLDINGS ON THE OVERLAP

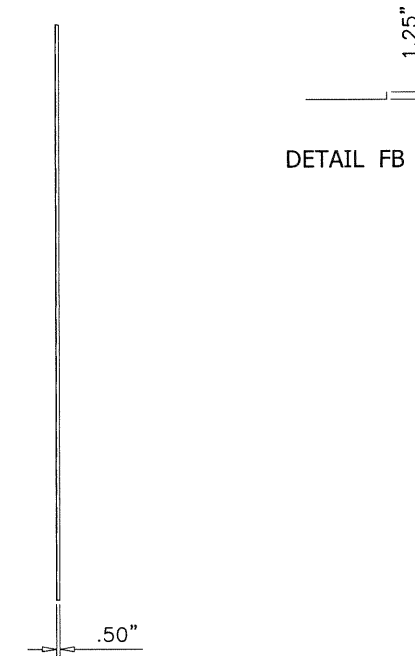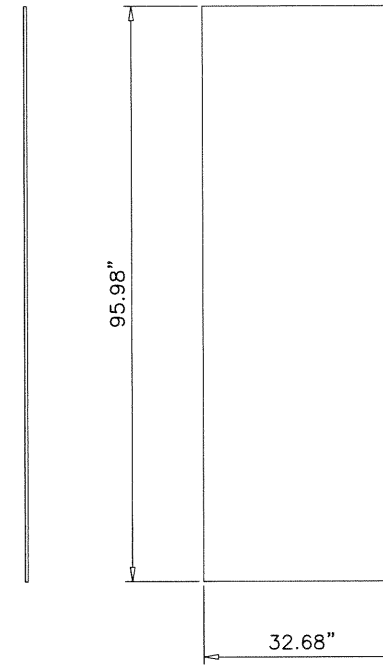

DETAIL FB

NOTE: DO NOT MAKE FOLDINGS ON THE OVERLAP

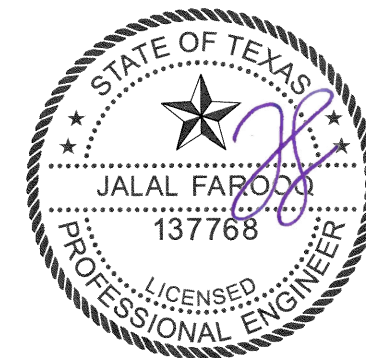

Sealed: 5/27/2021

af c
AL-FAROOQ CORPORATION
 ENGINEERS & PRODUCT DEVELOPMENT
 9360 SUNSET DRIVE, SUITE 220 (C.A.N. 3538)
 MIAMI, FLORIDA 33173 FAX: (305) 262-6978
 TEL: (305) 264-8100

WALK-IN COOLER & FREEZER
Barcel USA LLC.
 301 Northpoint Drive, Suite 100
 Coppell, TX 75019
 Phone: (972) 591-2493 Fax: (214) 441-9757

revisions:	
no	date by description



date: 11-20-20	scale: 3/8"=1'-0"	dr. by: -	chk. by:
drawing no. 20-95T			
sheet 10 of 47			

COOLER 20-95T-BUS

PARTS LIST			
ITEM	QTY	PART NUMBER	DESCRIPTION
B1	2	SIDE PANEL FOAM CORE	XPS CORE WITH A THICKNESS OF 4", AND 30 KG/M3 DENSITY
B2	4	SIDE WALL PANEL INTERIOR SHEET	EMBOZED STUCCO ALUMINUM SHEET GAUGE 23
B3	4	SIDE WALL PANEL EXTERIOR SHEET	WHITE PAINTED GALVANIZED STEEL SHEET GAUGE 26 TERNIUM ZINTRO G60
B4	6	INNER ANCHOR SUPPORT PLATE	1/4" X 4" CARBON STEEL PLATE
B5	3	INNER SUPPORT SHEET	GALVANIZED STEEL SHEET GAUGE 26
B6	3	WALL INNER REINFORCEMENT	CARBON STEEL TUBE 1" X 2" GAUGE 18

RIGID XPS FOAM (EXTRUDED POLYSTYRENE) OF 30 KG/M³ DENSITY, WITH COMPRESSION STRENGTH OF 25 LBS/IN.

EXTERIOR FINISH:
WHITE PAINTED (PINTRO)
GALV. STEEL SHEET

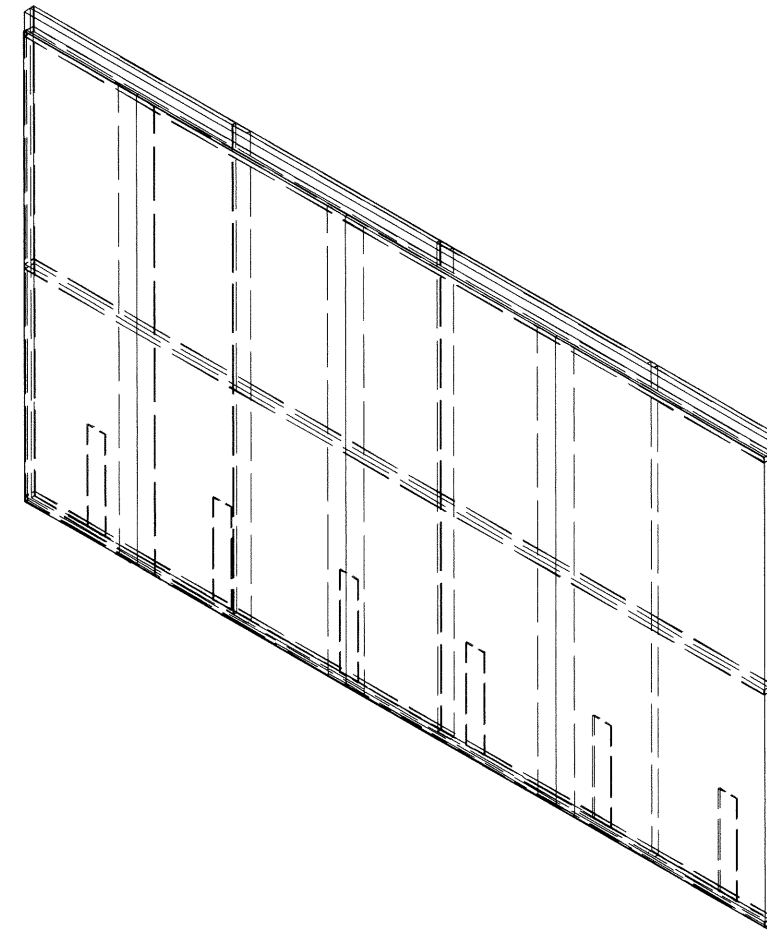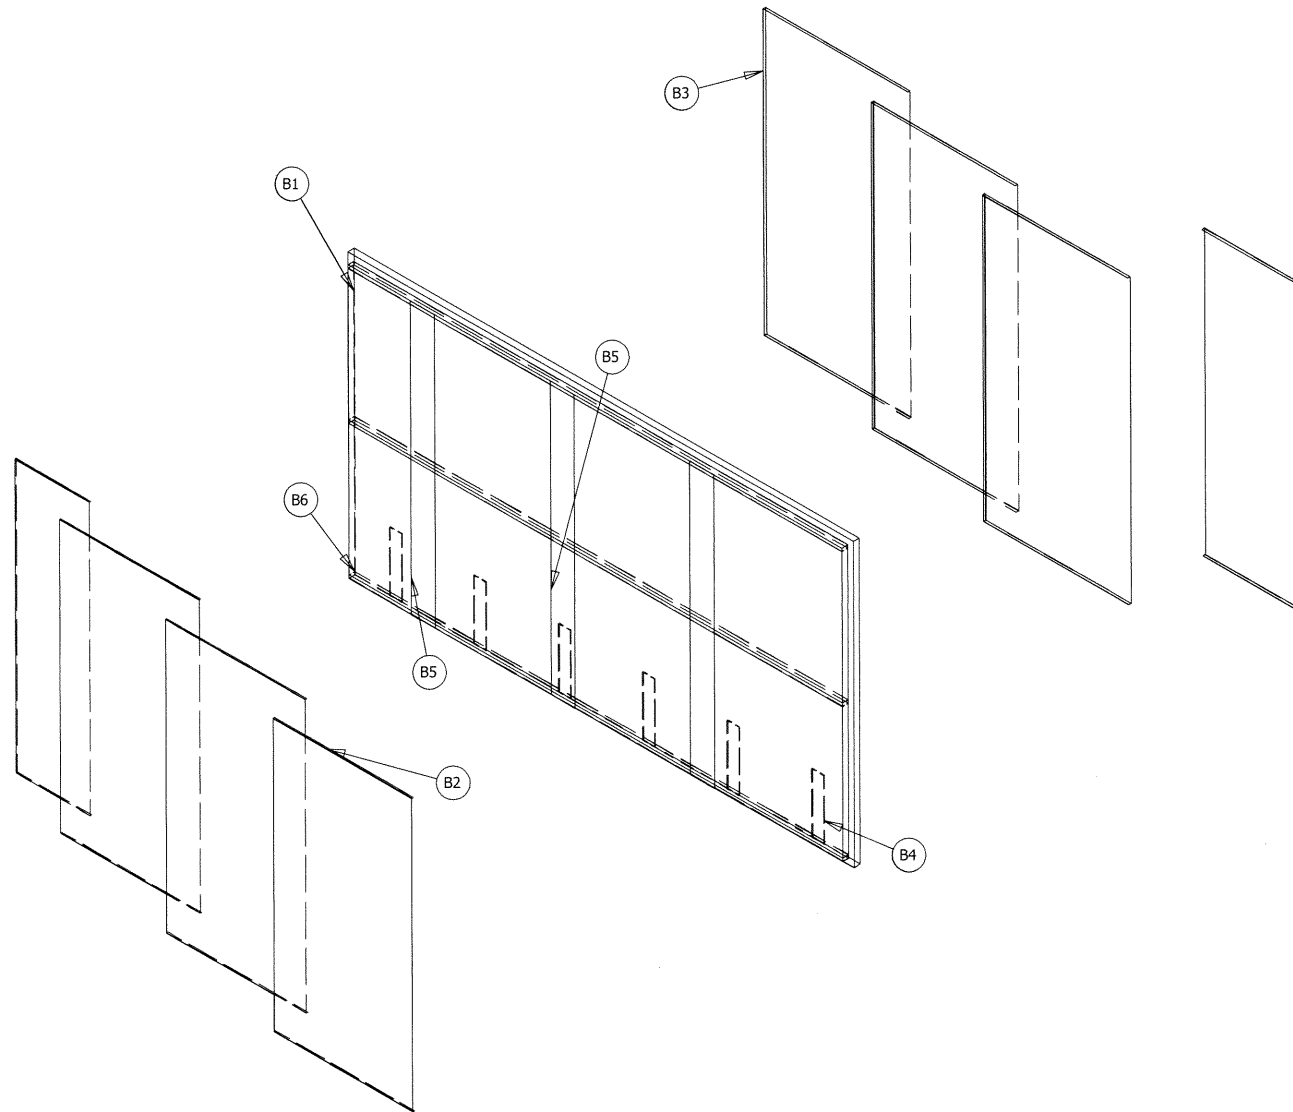

NOTE: CONSIDER THIS DRAWING FOR THE LEFT AND RIGHT SIDE WALL PANELS

afc
AL-FAROOQ CORPORATION
ENGINEERS & PRODUCT DEVELOPMENT
9360 SUNSET DRIVE, SUITE 220 (C.A.N. 3538)
MIAMI, FLORIDA 33173
TEL. (305) 264-8100 FAX. (305) 262-6978
COOLER\20-95T-BUS


WALK-IN COOLER & FREEZER

Barcel USA LLC.


301 Northpoint Drive, Suite 100
Coppell, TX 75019
Phone: (972) 591-2493 Fax: (214) 441-9757

revisions:	
no	date by description





date: 11-20-20	scale: -	dr. by: -	chk. by:
----------------	----------	-----------	----------

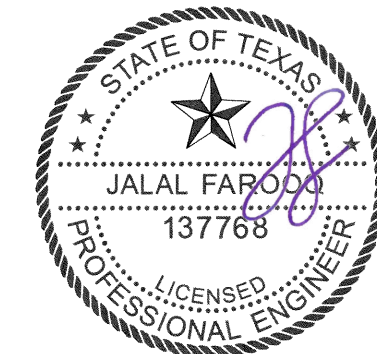

drawing no.
20-95T
sheet 11 of 47

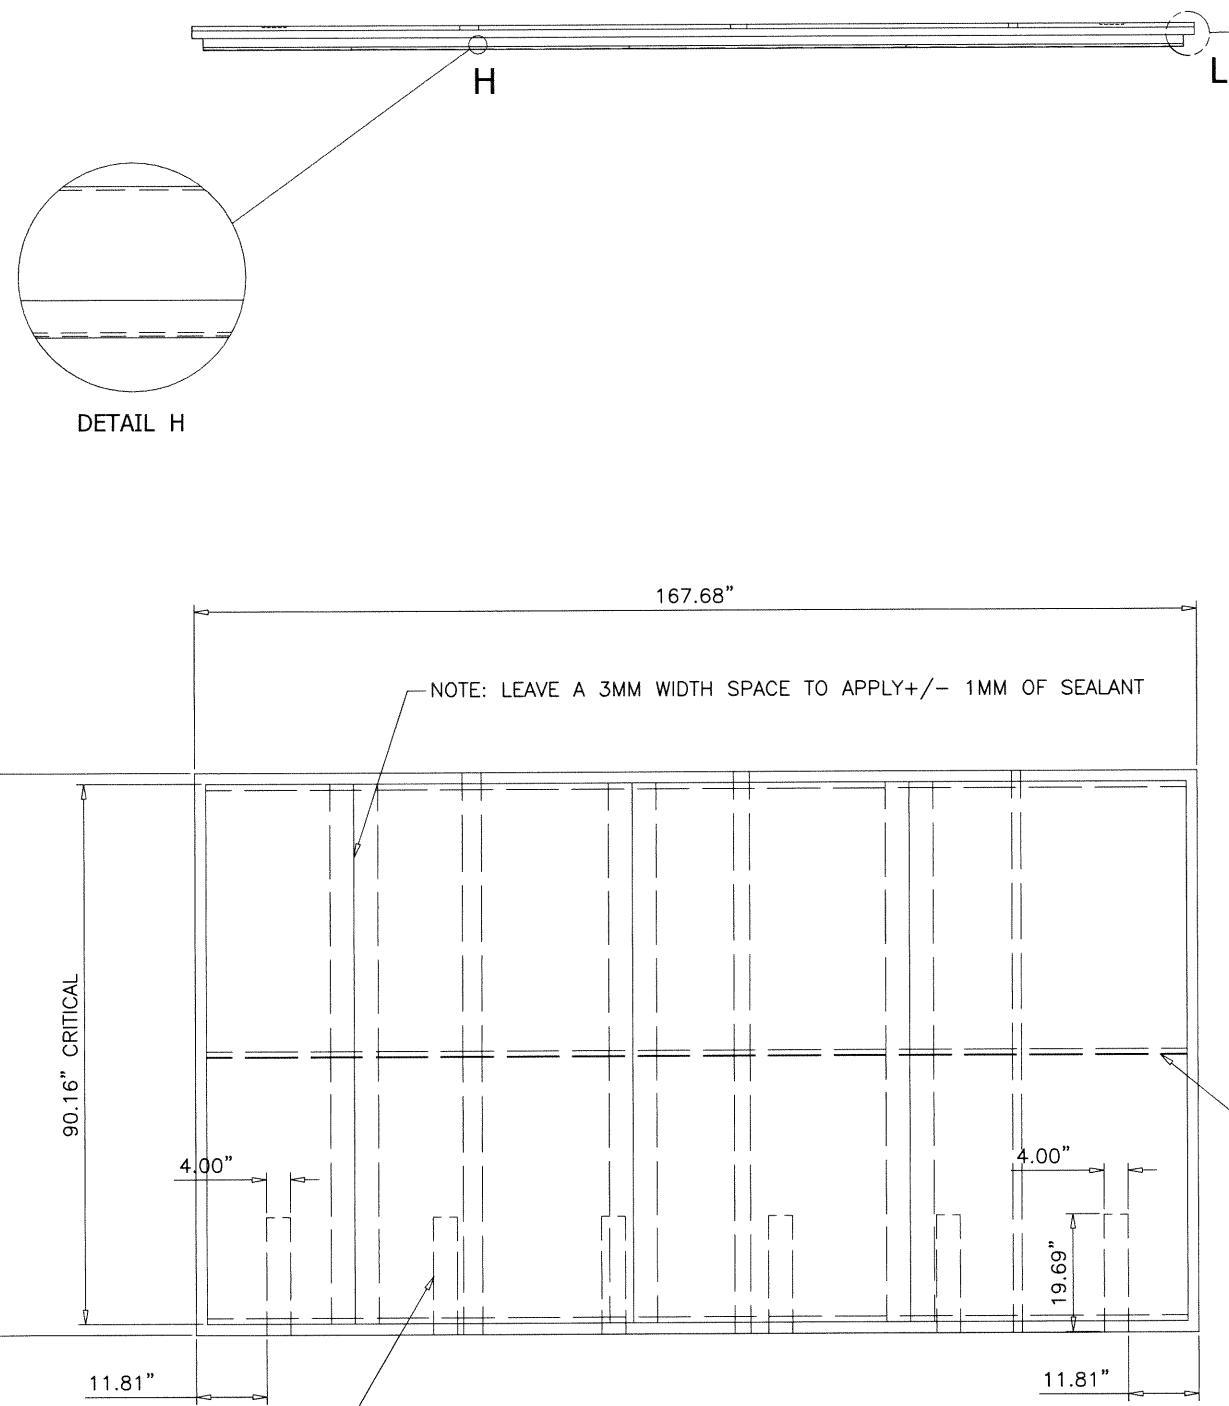

NOTE:
THE ANCHOR'S PLATE MUST BE PLACED ON THE LOWER PART OF THE PANEL, FACING THE EXTERIOR SIDE. THEY ARE MADE OF 1/4" X 4" CARBON STEEL PLATE.

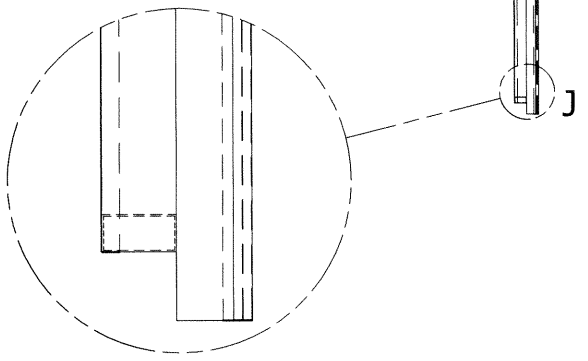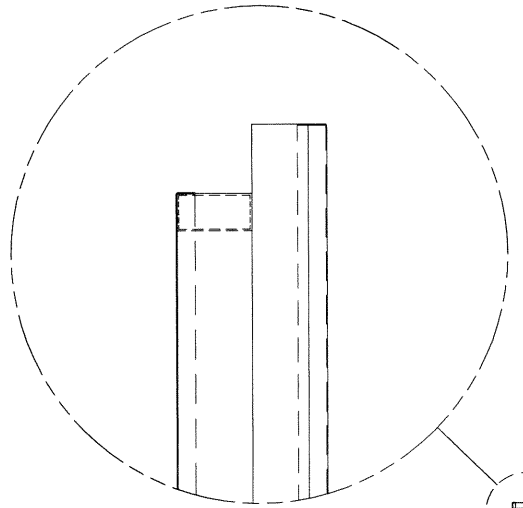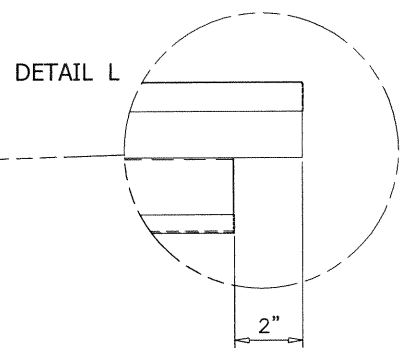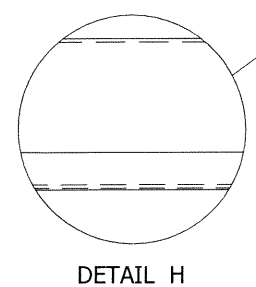

PARTS LIST			
ITEM	QTY	PART NUMBER	DESCRIPTION
B1	2	SIDE PANEL FOAM CORE	XPS CORE WITH A THICKNESS OF 4", AND 30 KG/M3 DENSITY
B2	4	SIDE WALL PANEL INTERIOR SHEET	EMBOZED STUCCO ALUMINUM SHEET GAUGE 23
B3	4	SIDE WALL PANEL EXTERIOR SHEET	WHITE PAINTED GALVANIZED STEEL SHEET GAUGE 26 TERNIUM ZINTRO G60
B4	6	INNER ANCHOR SUPPORT PLATE	1/4" X 4" CARBON STEEL PLATE
B5	3	INNER SUPPORT SHEET	GALVANIZED STEEL SHEET GAUGE 26
B6	3	WALL INNER REINFORCEMENT	CARBON STEEL TUBE 1" X 2" GAUGE 18

Sealed: 5/27/2021

STATE OF TEXAS
JALAL FAROOQ
137768
LICENSED PROFESSIONAL ENGINEER

af c
AL-FAROOQ CORPORATION
 ENGINEERS & PRODUCT DEVELOPMENT
 9360 SUNSET DRIVE, SUITE 220 (C.A.N. 3538)
 MIAMI, FLORIDA 33173 FAX. (305) 262-6978
 TEL. (305) 264-8100

WALK-IN COOLER & FREEZER
Barcel USA LLC.
 301 Northpoint Drive, Suite 100
 Coppell, TX 75019
 Phone: (972) 591-2493 Fax: (214) 441-9757

revisions:	
no	date by description

date: 11-20-20 scale: 3/8"=1'-0" dr. by: - chk. by: -

drawing no. **20-95T**

sheet 12 of 47

COOLER 20-95T-BUS

afc

AL-FAROOQ CORPORATION
ENGINEERS & PRODUCT DEVELOPMENT
9360 SUNSET DRIVE, SUITE 220
MIAMI, FLORIDA 33173 (C.A.N. 3538)
TEL. (305) 264-8100 FAX. (305) 262-6978

COOLER\20-95T-BUS

WALK-IN COOLER & FREEZER


Barcel USA LLC.
301 Northpoint Drive, Suite 100
Coppell, TX 75019
Phone: (972) 591-2493 Fax: (214) 441-9757

revisions:
no. date by description




date: 11-20-20
scale: 3/8"=1'-0"
dr. by: -
chk. by:

drawing no.
20-95T


sheet 13 of 47

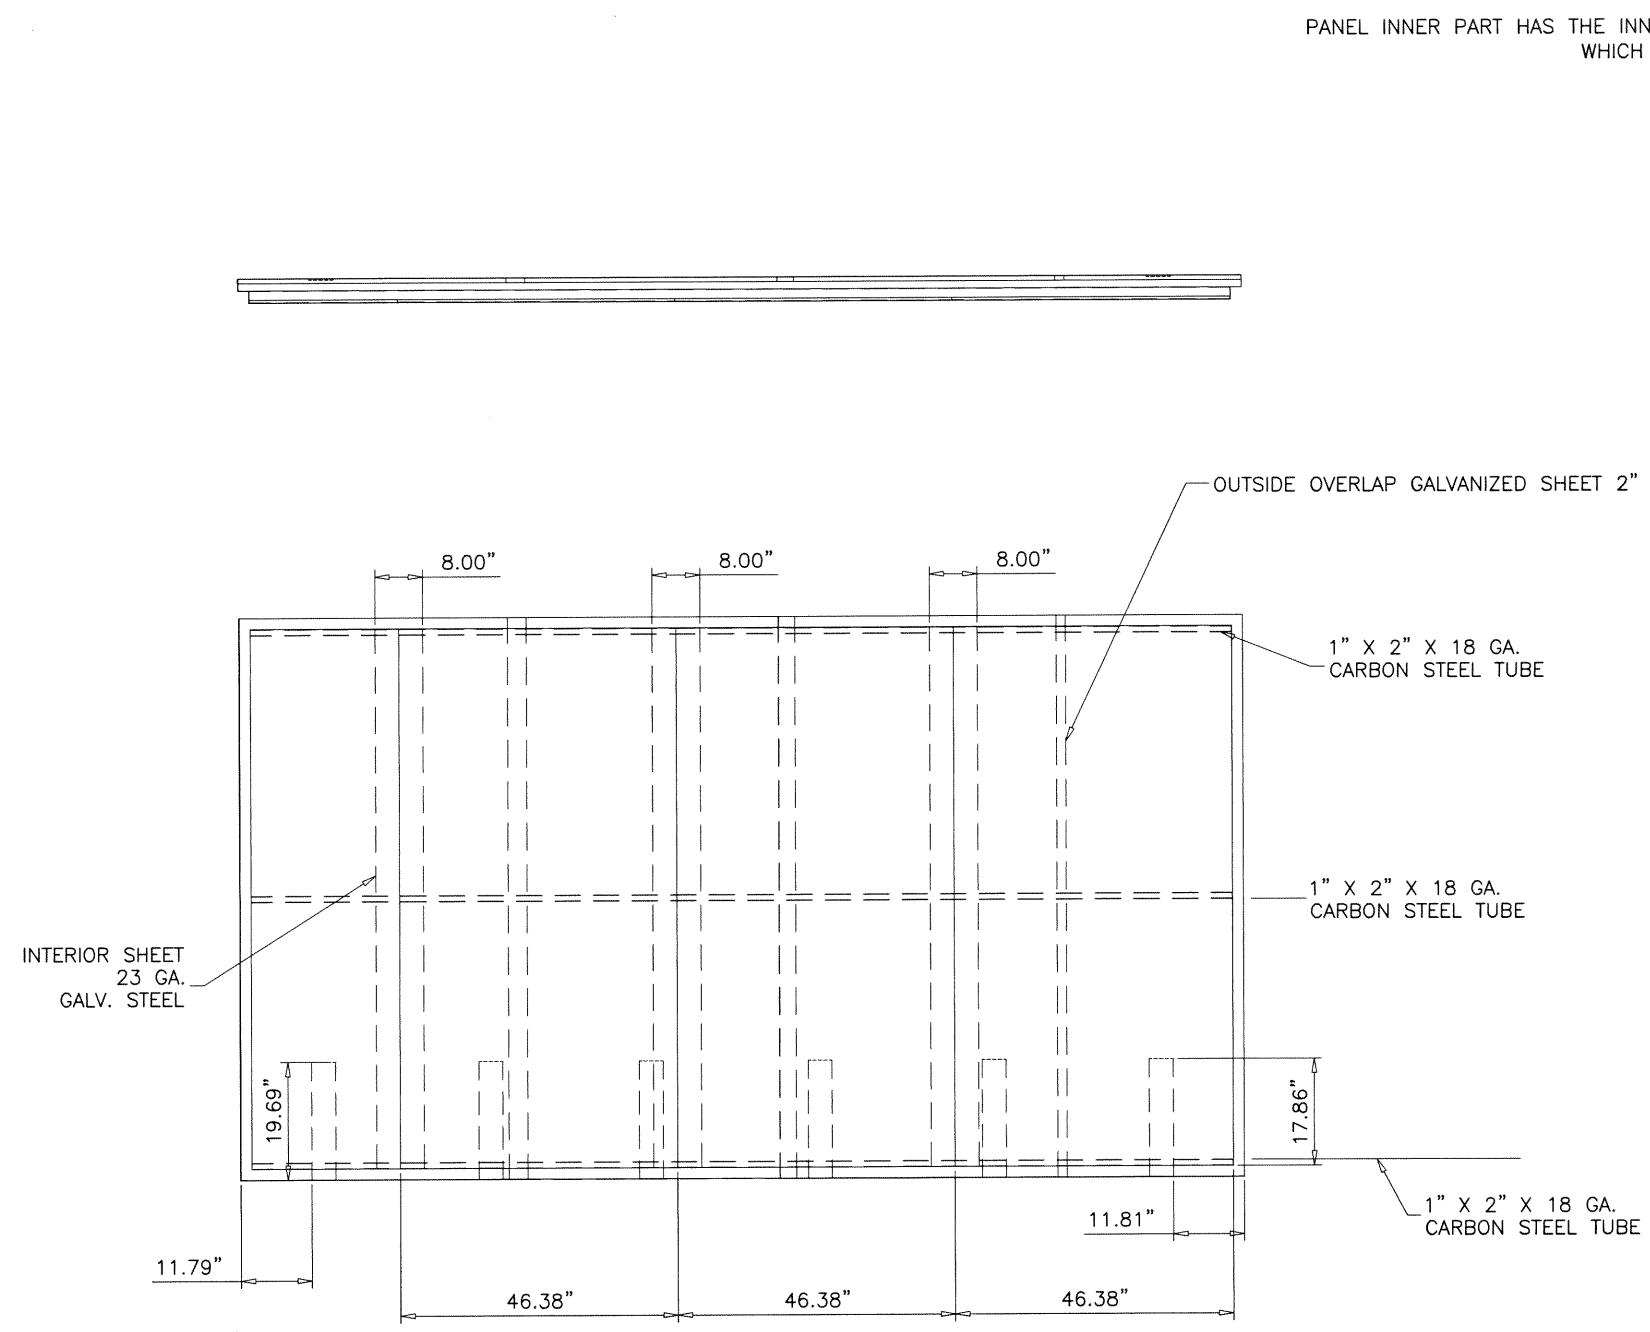


PANEL INNER PART HAS THE INNER SUPPORT SHEET WHICH HAS A 7.99" WIDTH

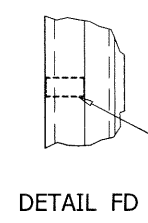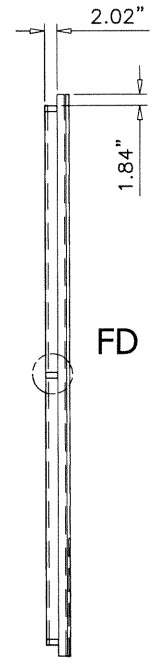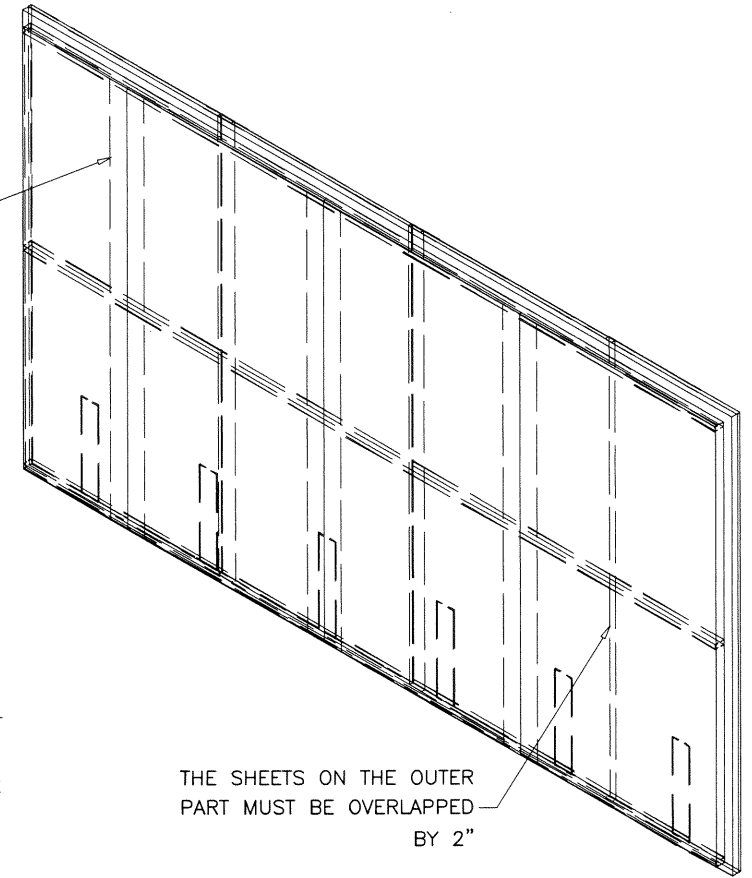


Sealed: 5/27/2021

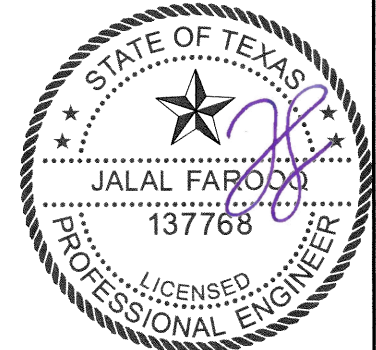


PARTS LIST			
ITEM	QTY	PART NUMBER	DESCRIPTION
B1	1	SIDE PANEL FOAM CORE	XPS CORE WITH A THICKNESS OF 4", AND 31 KG/M3 DENSITY

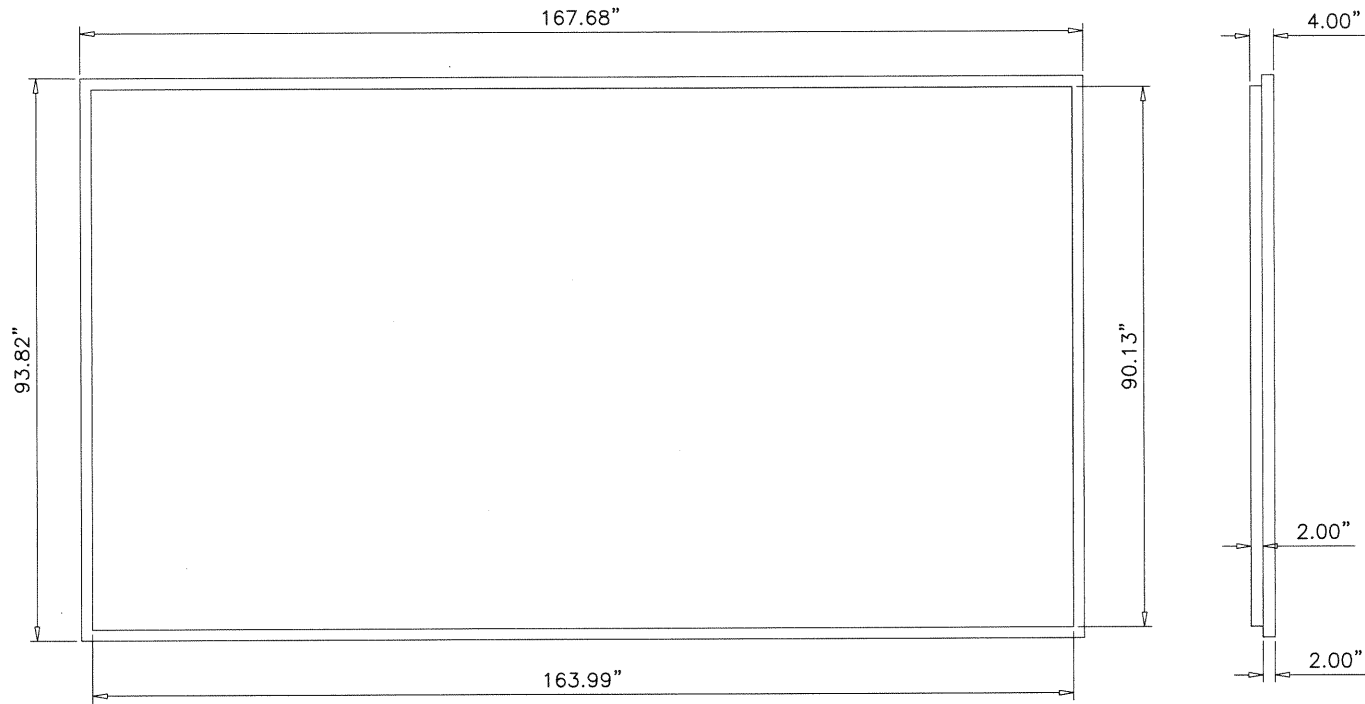


PARTS LIST			
ITEM	QTY	PART NUMBER	DESCRIPTION
B2	4	SIDE WALL PANEL INTERIOR SHEET	EMBOZED STUCCO ALUMINUM SHEET GAUGE 21

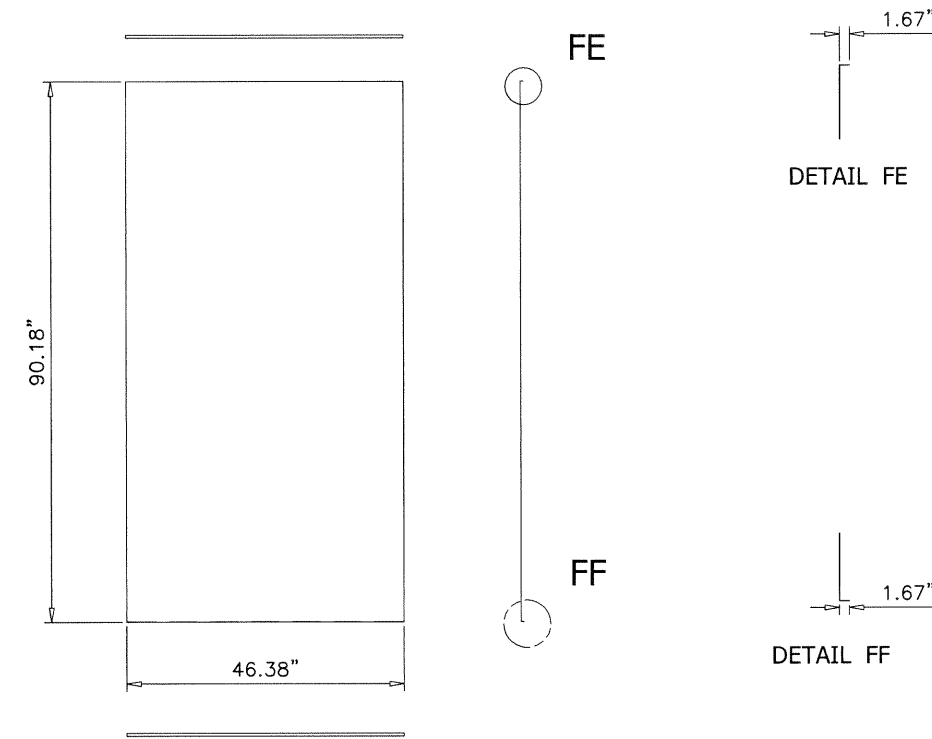


PARTS LIST			
ITEM	QTY	PART NUMBER	DESCRIPTION
B3	3	SIDE WALL PANEL EXTERIOR SHEET	WHITE PAINTED GALVANIZED STEEL SHEET GAUGE 26 TERNIUM ZINTRO G60

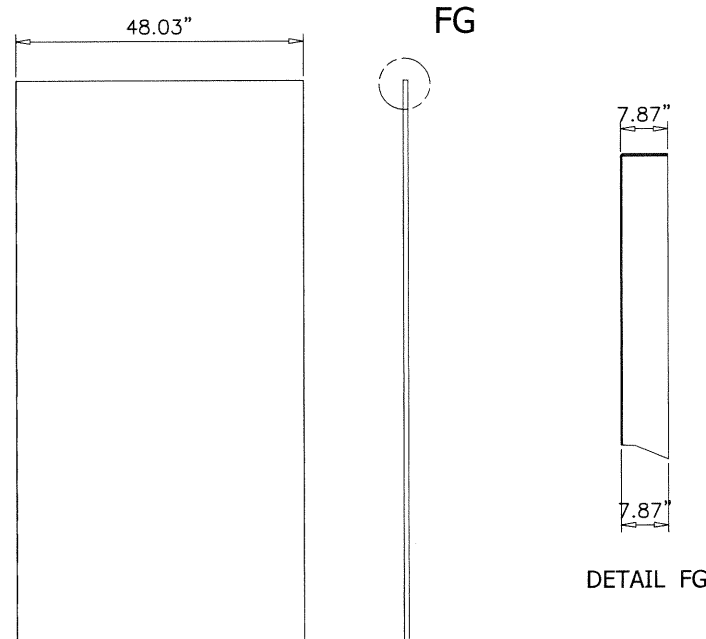

PARTS LIST			
ITEM	QTY	PART NUMBER	DESCRIPTION
B4	2	INNER ANCHOR SUPPORT PLATE	CARBON STEEL

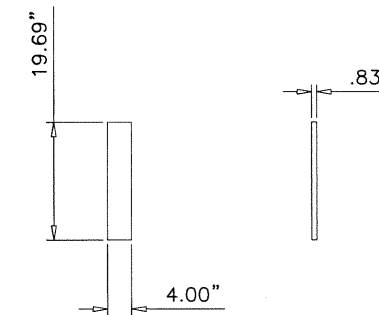

NOTE:
 (1) PANEL WITH (3) 1/2" FOLDS
 (2) PANELS WITH FOLDS ON THE UPPER PART
 THERE ARE NO FOLDS ON THE CENTER PANEL

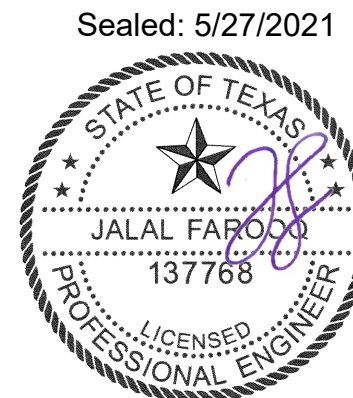




af c
AL-FAROOQ CORPORATION
 ENGINEERS & PRODUCT DEVELOPMENT
 9360 SUNSET DRIVE, SUITE 220 (C.A.N. 3538)
 MIAMI, FLORIDA 33173
 TEL. (305) 264-8100 FAX. (305) 262-6978
 COOLER\20-95T-BUS

WALK-IN COOLER & FREEZER
Barcel USA LLC.
 301 Northpoint Drive, Suite 100
 Coppell, TX 75019
 Phone: (972) 591-2493 Fax: (214) 441-9757

revisions:		no	date	by	description
date:	11-20-20	scale:	3/8"=1'-0"	dr. by:	-
chk. by:		drawing no.:	20-95T	sheet	14 of 47



PARTS LIST			
ITEM	QTY	PART NUMBER	DESCRIPTION
A5,B5,C4	3	INNER SUPPORT SHEET	GALVANIZED STEEL SHEET GAUGE 26

PARTS LIST			
ITEM	QTY	PART NUMBER	DESCRIPTION
B6	3	WALL INNER REINFORCEMENT	CARBON STEEL TUBE 1" X 2" GAUGE 18

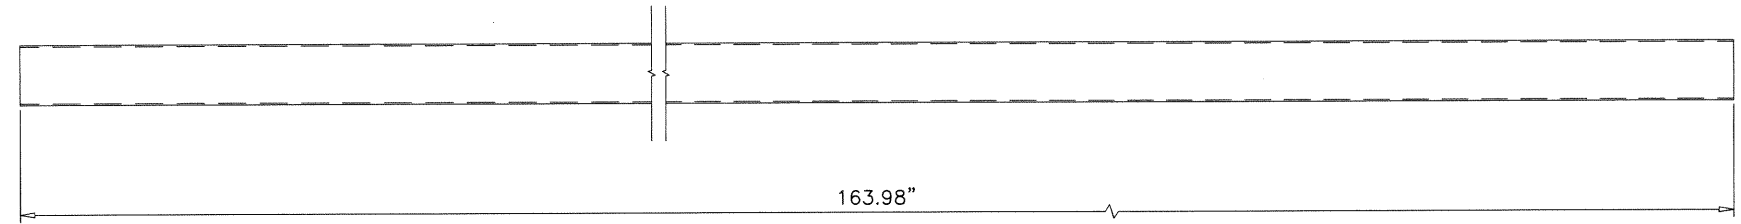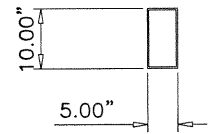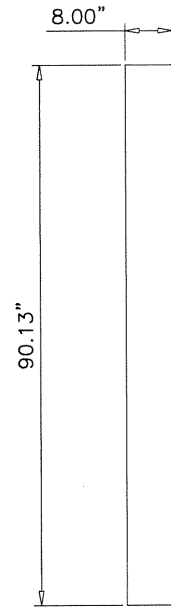

PARTS LIST			
ITEM	QTY	PART NUMBER	DESCRIPTION
C	1	REAR PANEL	
C1	1	REAR PANEL FOAM CORE	XPS CORE WITH A THICKNESS OF 4", AND 30 KG/M3 DENSITY
C2	2	INTERIOR REAR PANEL ALUMINUM SHEET	EMBOZED STUCCO ALUMINUM SHEET GAUGE 23
C3	1	REAR PANEL EXTERIOR SHEET	WHITE PAINTED GALVANIZED STEEL SHEET GAUGE 26 TERNIUM ZINTRO G60
C4	1	INNER SUPPORT SHEET	GALVANIZED STEEL SHEET GAUGE 26
C5	2	SHORT EXTERIOR REAR PANEL SHEET	WHITE PAINTED GALVANIZED STEEL SHEET GAUGE 26 TERNIUM ZINTRO G60

PANEL MADE OF EXTRUDED POLYSTYRENE FOAM (XPS) WITH A 30 KG/M³ DENSITY AND COMPRESSION RESISTANCE OF 25 LBS/IN. OUTER FINISH IS GALVANIZED STEEL SHEET GAUGE 26 AND INNER FINISH IS ALUMINUM SHEET GAUGE 23 EXCEPT FOR THE FLOOR WHICH IS GAUGE 14.

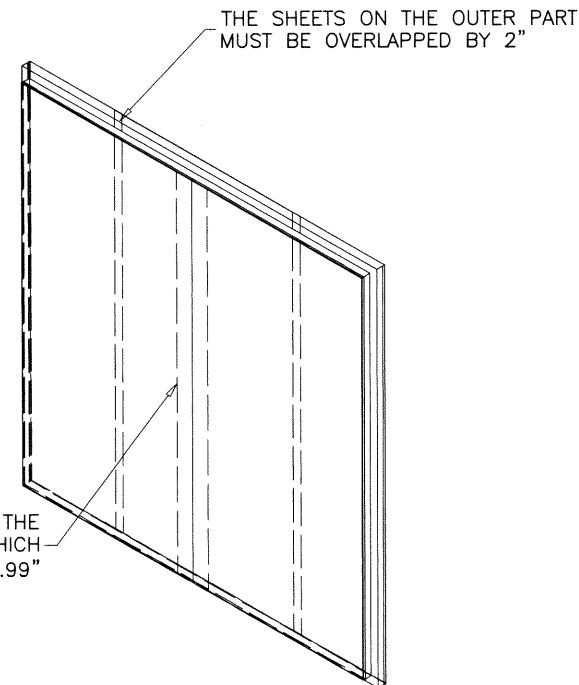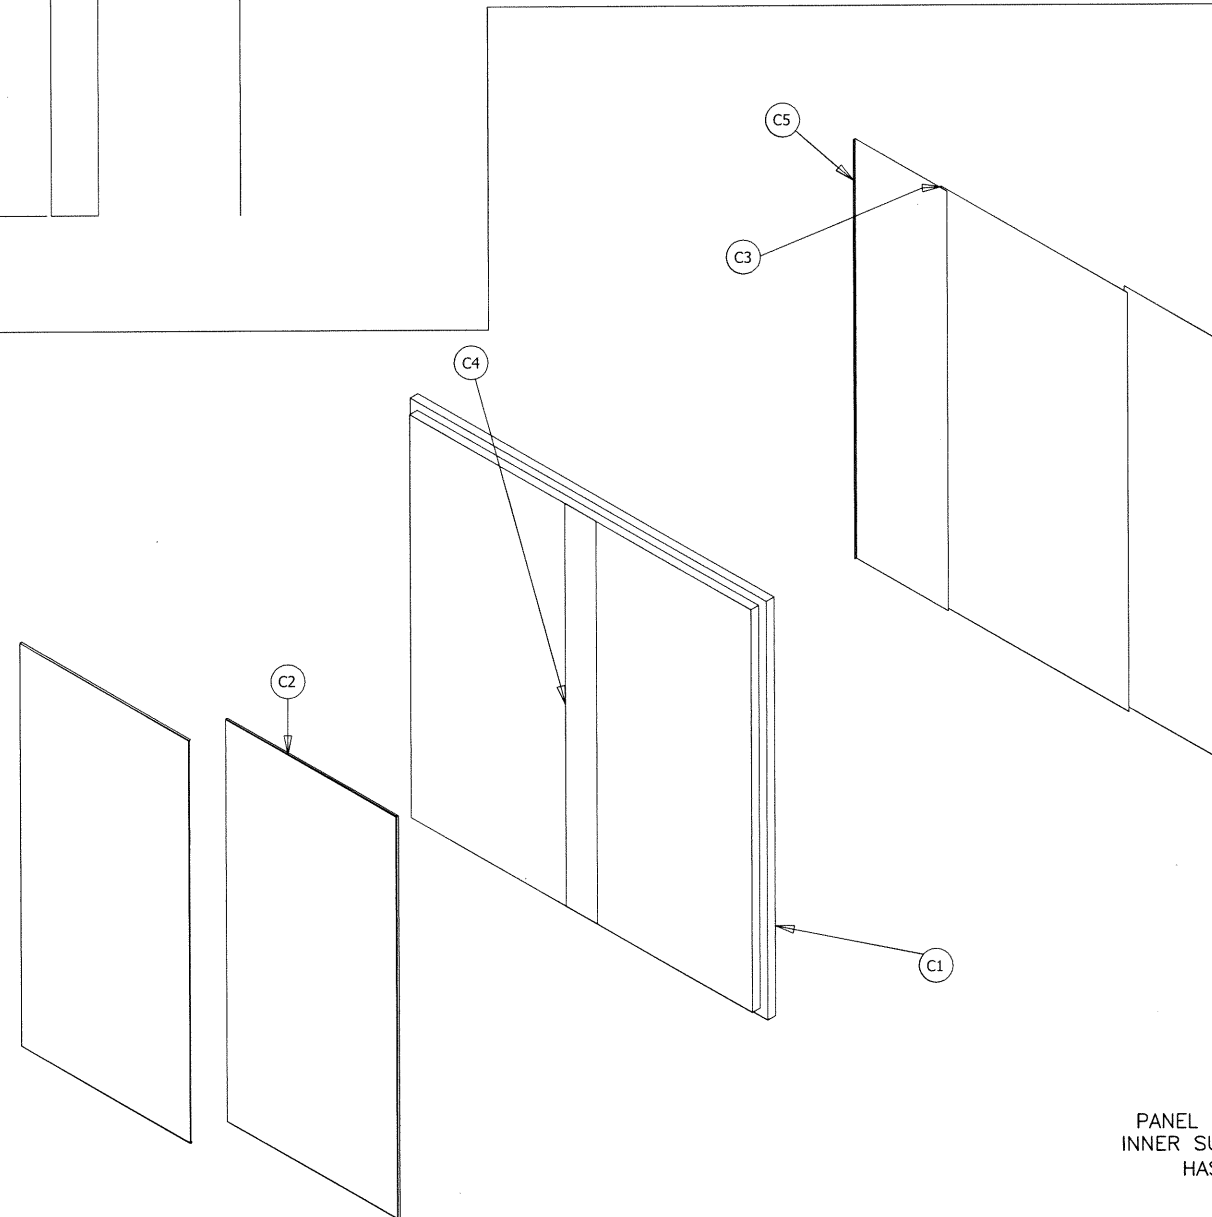


PANEL INNER PART HAS THE INNER SUPPORT SHEET WHICH HAS A THICKNESS 7.99"

a f c
AL-FAROOQ CORPORATION
 ENGINEERS & PRODUCT DEVELOPMENT
 9360 SUNSET DRIVE, SUITE 220 (C.A.N. 3538)
 MIAMI, FLORIDA 33173
 TEL. (305) 264-8100 FAX. (305) 262-6978
 COOLER\20-95T-BUS

WALK-IN COOLER & FREEZER
Barcel USA LLC.
 301 Northpoint Drive, Suite 100
 Coppell, TX 75019
 Phone: (972) 591-2493 Fax: (214) 441-9757

revisions:	
no	description


date: 11-20-20
 scale: 3/8"=1'-0"
 dr. by: -
 chk. by:

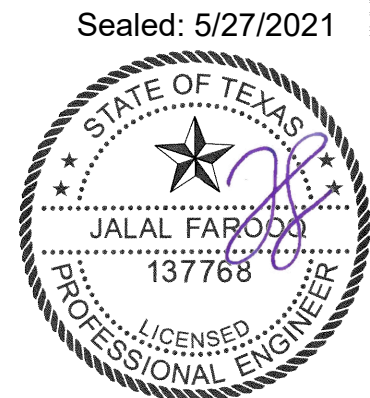

drawing no.
20-95T
 sheet 15 of 47


no	date	by	description

date: 11-20-20	scale: 3/8"=1'-0"	dr. by: -	chk. by:
----------------	-------------------	-----------	----------

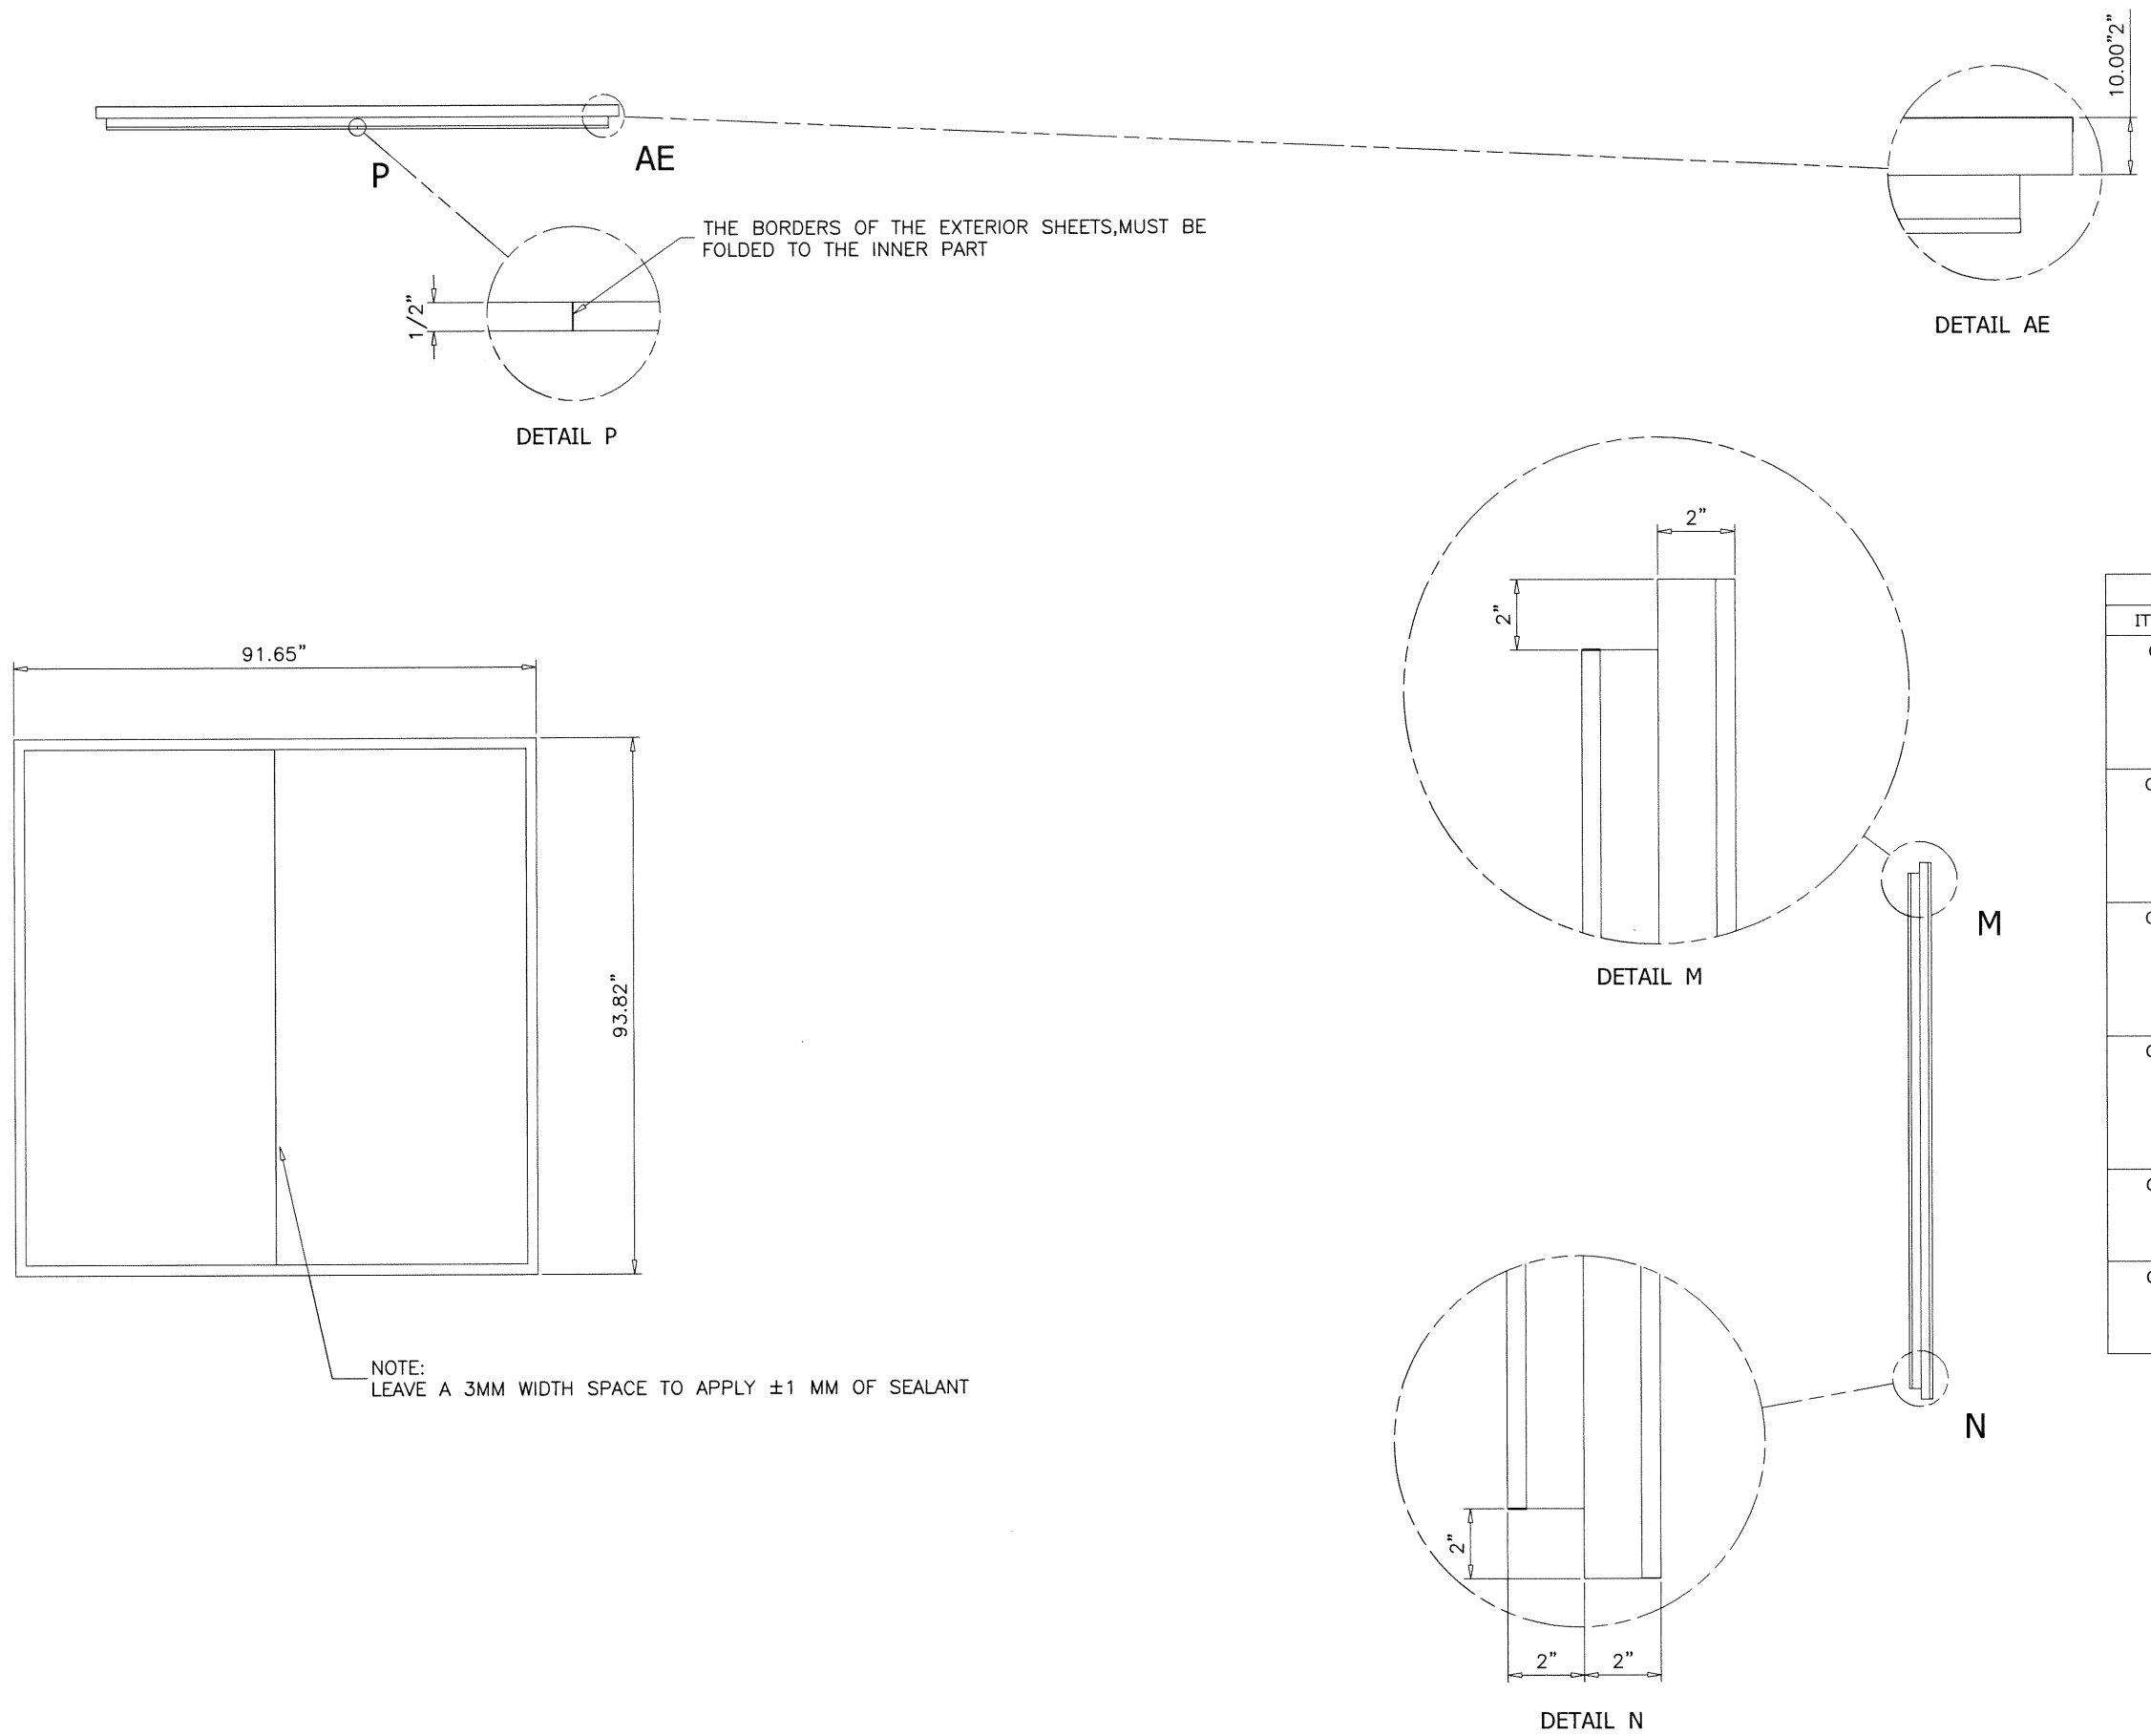


NOTE:
 LEAVE A 3MM WIDTH SPACE TO APPLY ±1 MM OF SEALANT



PARTS LIST			
ITEM	QTY	PART NUMBER	DESCRIPTION
C	1	REAR PANEL	
C1	1	REAR PANEL FOAM CORE	XPS CORE WITH A THICKNESS OF 3 AND 3' KG^3 DENSITY
C2	2	INTERIOR REAR PANEL ALUMINUM SHEET	EMBOZED STUCCO ALUMINUM SHEET GAUGE 23
C3	1	REAR PANEL EXTERIOR SHEET	WHITE PAINTED GALVANIZED STEEL SHEET GAUGE 26 TERNIUM ZINTRO G60
C4	1	INNER SPPORT SHEET	GALVANIZED STEEL SHEET GAUGE 26
C5	2	SHORT EXTERIOR REAR PANEL SHEET	WHITE PAINTED GALVANIZED STEEL SHEET GAUGE 26 TERNIUM ZINTRO G60

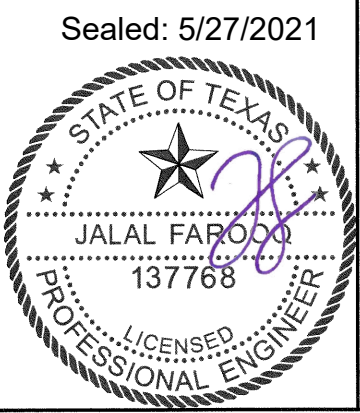

PARTS LIST			
ITEM	QTY	PART NUMBER	DESCRIPTION
C1	1	REAR PANEL FOAM CORE	XPS CORE WITH A THICKNESS OF 4", AND 30 KG/M3 DENSITY

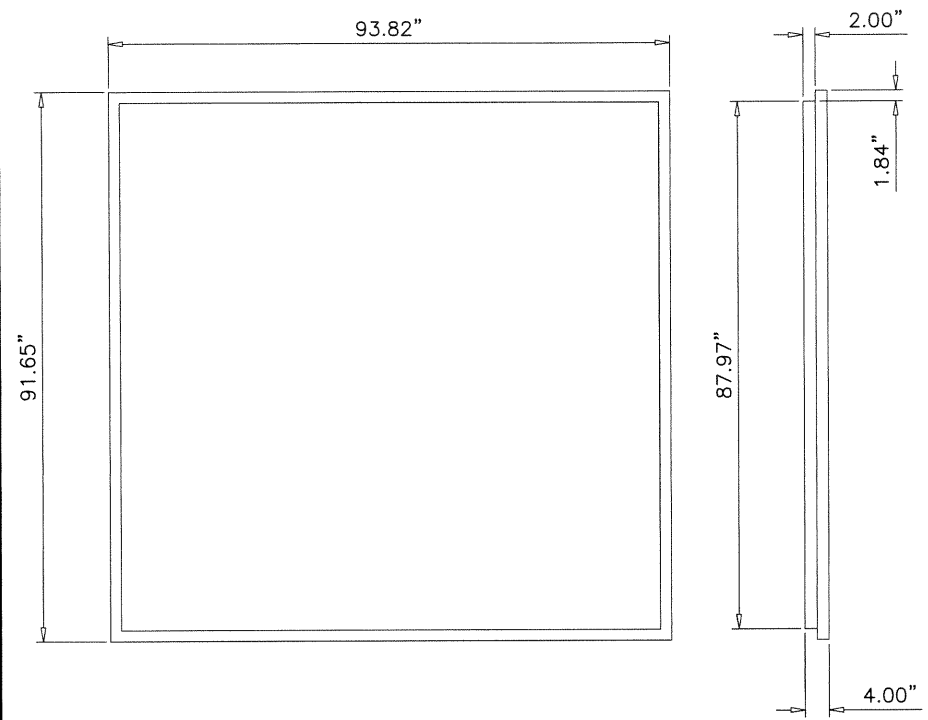


PARTS LIST			
ITEM	QTY	PART NUMBER	DESCRIPTION
C2	2	INTERIOR REAR PANEL ALUMINUM SHEET	EMBOZED STUCCO ALUMINUM SHEET GAUGE 23

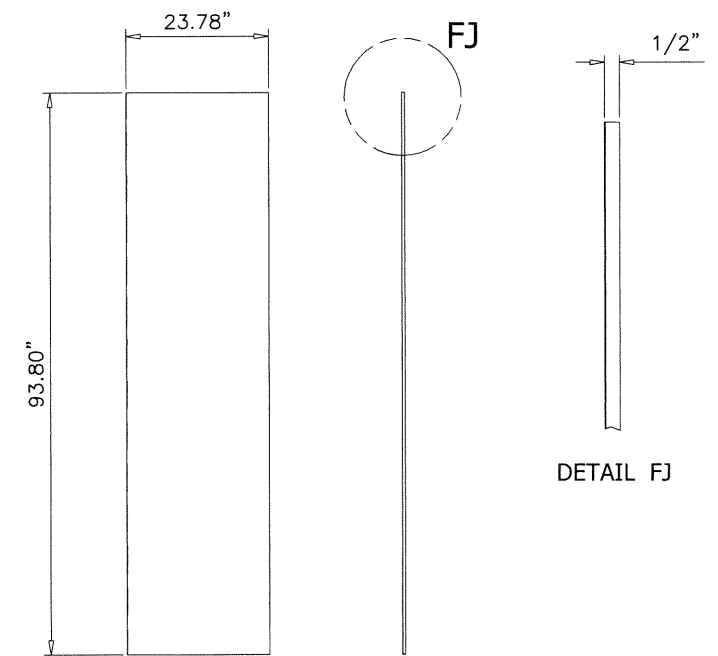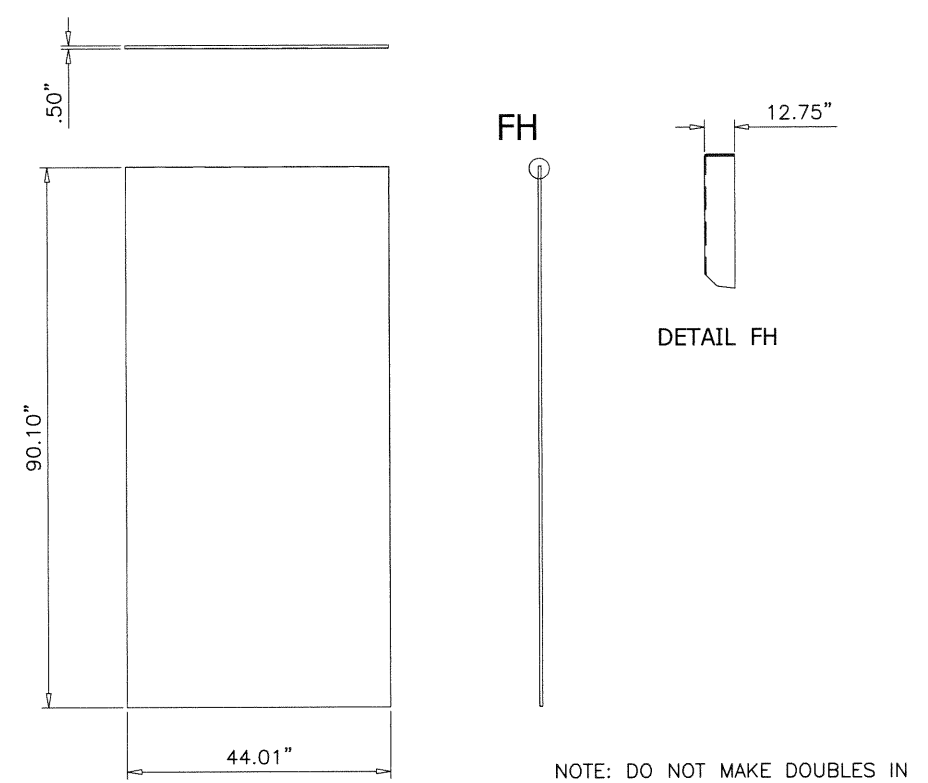


NOTE: THERE ARE NO FLODINGS ON THE INNER PART, THEY ARE OVERLAP BY 1-15/16".

PARTS LIST			
ITEM	QTY	PART NUMBER	DESCRIPTION
C3	1	REAR PANEL EXTERIOR SHEET	WHITE PAINTED GALVANIZED STEEL SHEET GAUGE 26 TERNIUM ZINTRO G60

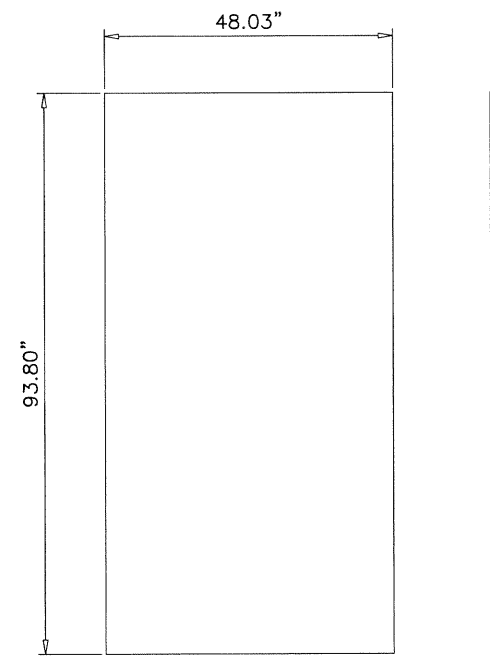


PARTS LIST			
ITEM	QTY	PART NUMBER	DESCRIPTION
A5,B5,C4	3	INNER SUPPORT SHEET	GALVANIZED STEEL SHEET GAUGE 26

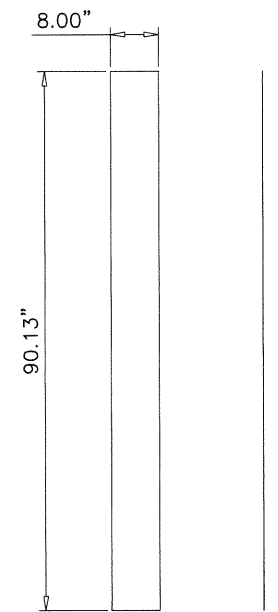

PARTS LIST			
ITEM	QTY	PART NUMBER	DESCRIPTION
C5	2	SHORT EXTERIOR REAR PANEL SHEET	WHITE PAINTED GALVANIZED STEEL SHEET GAUGE 26 TERNIUM ZINTRO G60


NOTE: WITHOUT FOLDING IN EXTREMES

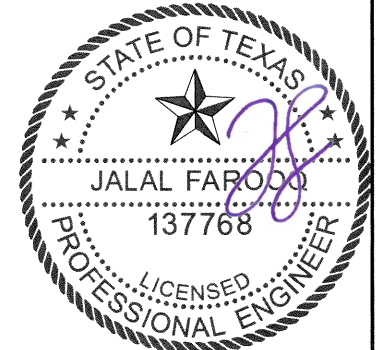

af c
AL-FAROOQ CORPORATION
 ENGINEERS & PRODUCT DEVELOPMENT
 9360 SUNSET DRIVE, SUITE 220
 MIAMI, FLORIDA 33173 (C.A.N. 3538)
 TEL. (305) 264-8100 FAX. (305) 262-6978
 COOLER\20-95T-BUS

WALK-IN COOLER & FREEZER
Barcel USA LLC.
 301 Northpoint Drive, Suite 100
 Coppell, TX 75019
 Phone: (972) 591-2493 Fax: (214) 441-9757

revisions:	no	date	by	description
date:	11-20-20	scale:	3/8"=1'-0"	
dr. by:	-	chk. by:		
drawing no.	20-95T			
sheet	17 of 47			

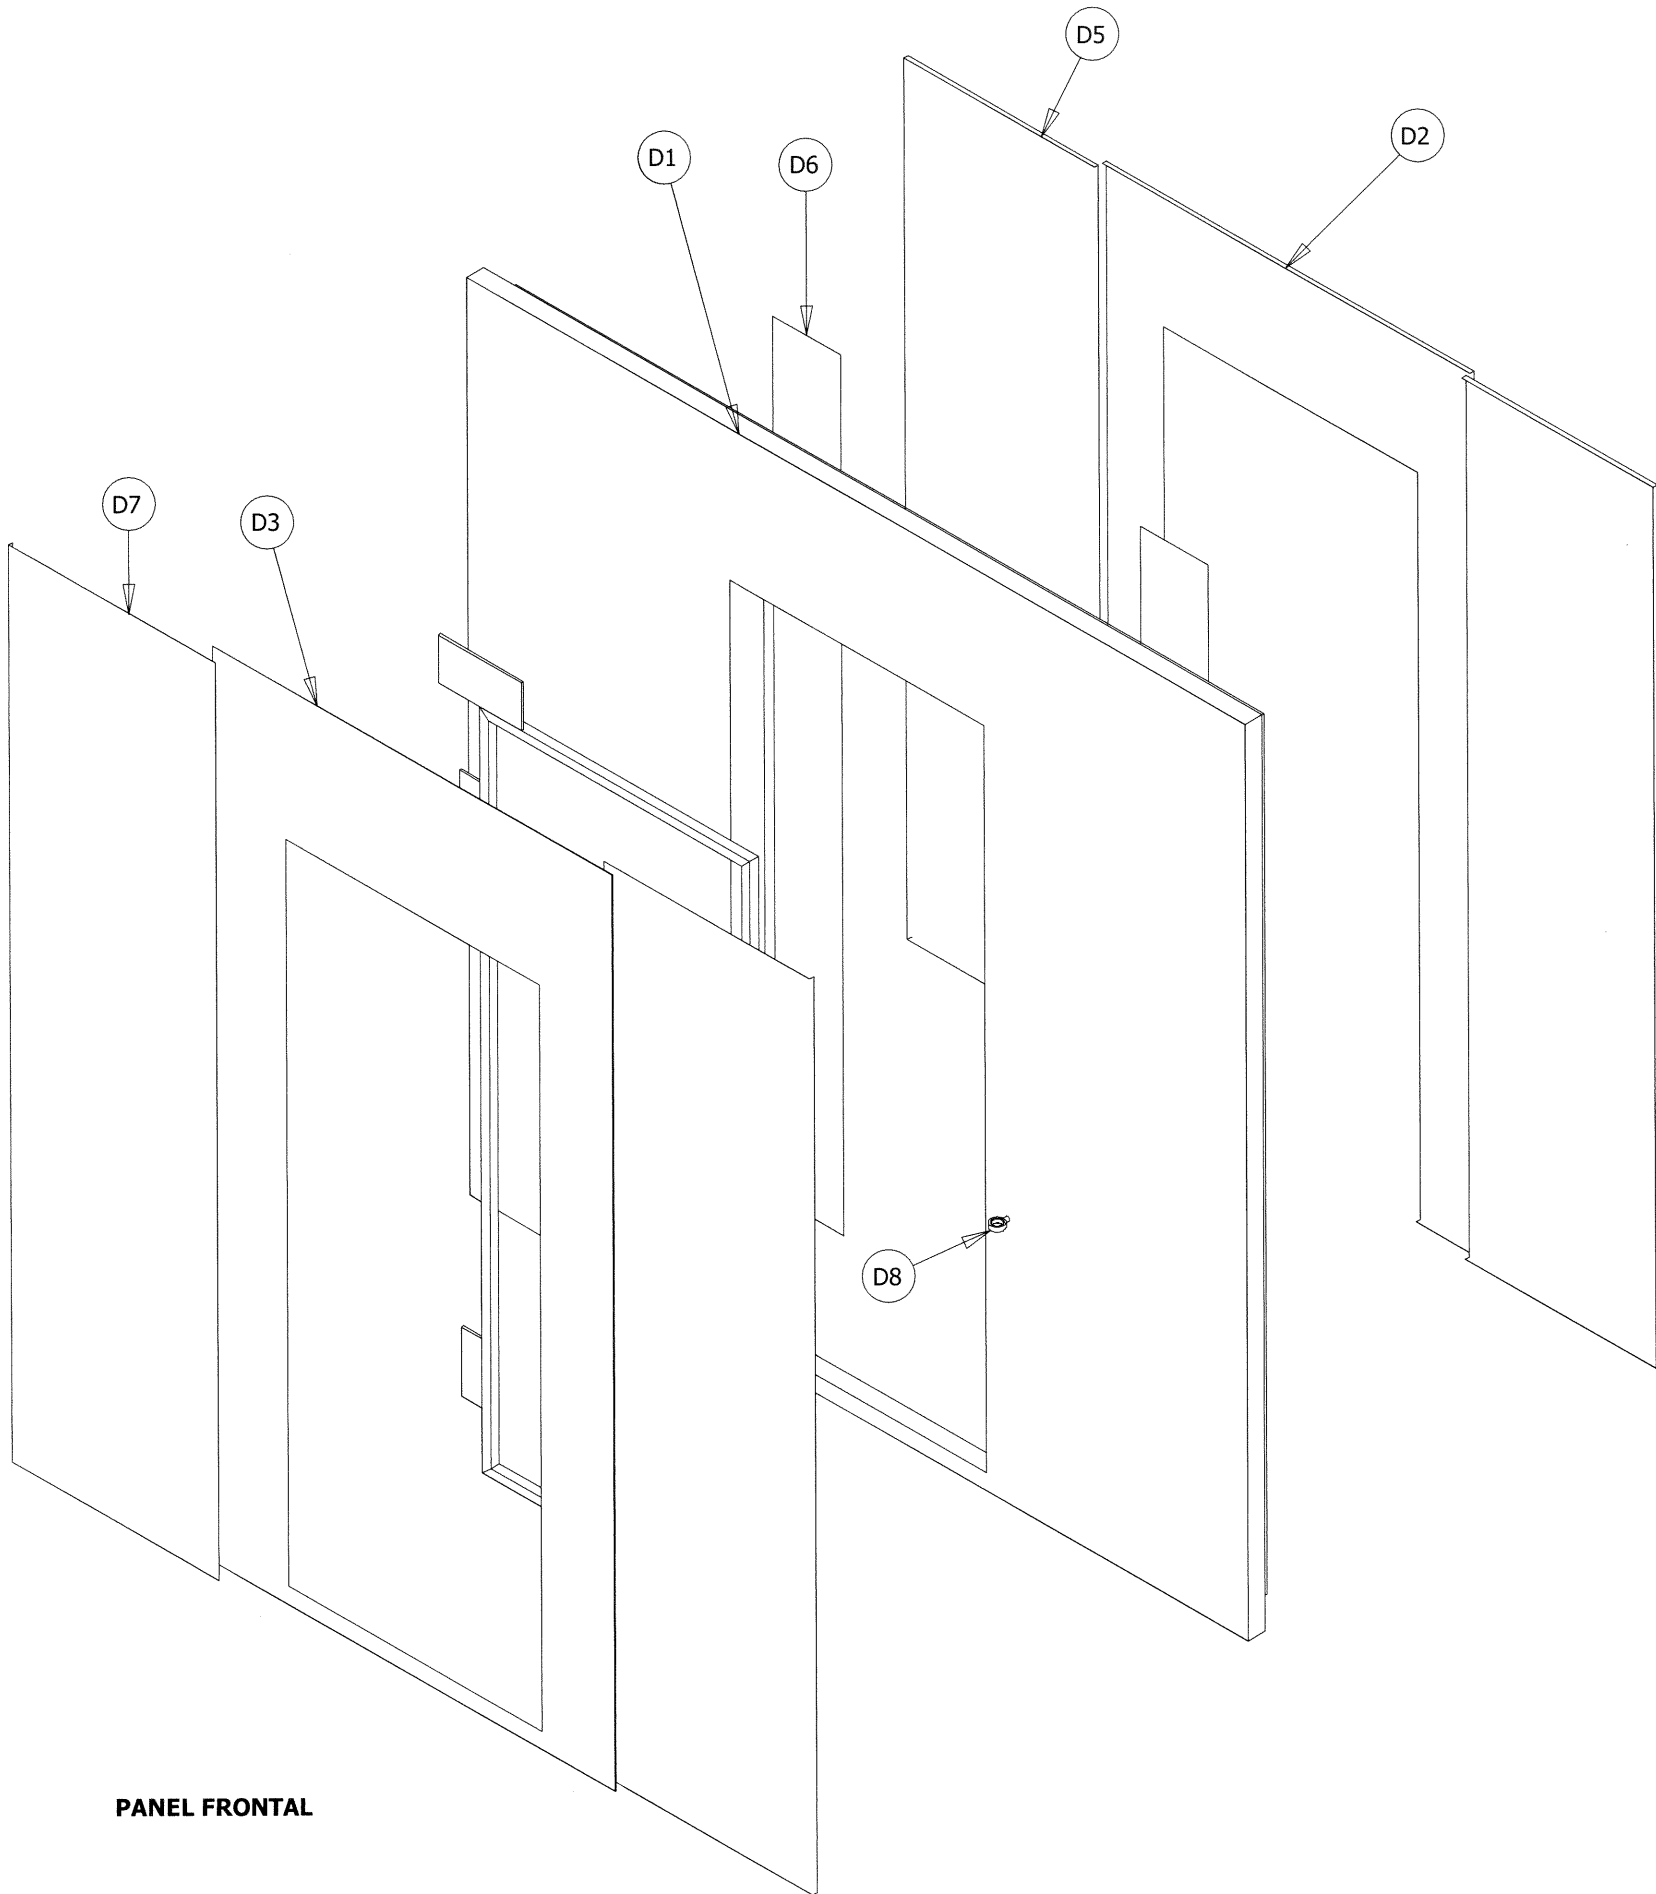

PANEL FRONTAL

PARTS LIST		
ITEM	QTY	DESCRIPTION
D	1	FRONT PANEL
D1	1	FRONT PANEL FOAM CORE XPS CORE WITH A THICKNESS OF 4", AND 30 KG/M3 DENSITY
D2	1	INTERIOR CENTRAL FRONTAL PANEL SHEET EMBOZED ALUMINUM STUCCO SHEET GAUGE 23
D3	1	EXTERIOR FRONTAL PANEL SHEET WHITE PAINTED GALVANIZED STEEL SHEET GAUGE 26 TERNIUM ZINTRO G60
D5	2	INTERIOR SIDE FRONTAL PANEL SHEET EMBOZED STUCCO ALUMINUM GAUGE 23
D6	2	INNER SUPPORT SHEET GALVANIZED STEEL SHEET GAUGE 26
D7	2	EXTERIOR SIDE FRONTAL PANEL SHEET WHITE PAINTED GALVANIZED STEEL SHEET GAUGE 26 TERNIUM ZINTRO G60
D8	1	PADLOCK EYEBOLT STAINLESS STEEL

PANEL MADE OF EXTRUDED POLYSTYRENE FOAM (XPS) WITH A 30 KG/M³ DENSITY AND COMPRESSION RESISTANCE OF 25 LBS/IN. OUTER FINISH IS GALVANIZED STEEL SHEET GAUGE 26 AND INNER FINISH IS ALUMINUM SHEET GAUGE 23 EXCEPT FOR THE FLOOR WHICH IS GAUGE 14.

af c
AL-FAROOQ CORPORATION
 ENGINEERS & PRODUCT DEVELOPMENT
 9360 SUNSET DRIVE, SUITE 220 (C.A.N. 3538)
 MIAMI, FLORIDA 33173 FAX. (305) 262-6978
 TEL. (305) 264-8100

WALK-IN COOLER & FREEZER

Barcel USA LLC.

301 Northpoint Drive, Suite 100
 Coppell, TX 75019


Phone: (972) 591-2493 Fax: (214) 441-9757



revisions:	
no	description

date: 11-20-20	scale: -	dr. by: -	chk. by:
----------------	----------	-----------	----------

drawing no.
20-95T
 sheet 18 of 47


Sealed: 5/27/2021

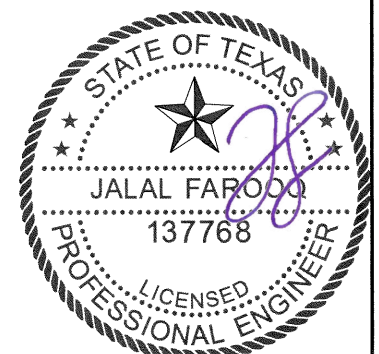

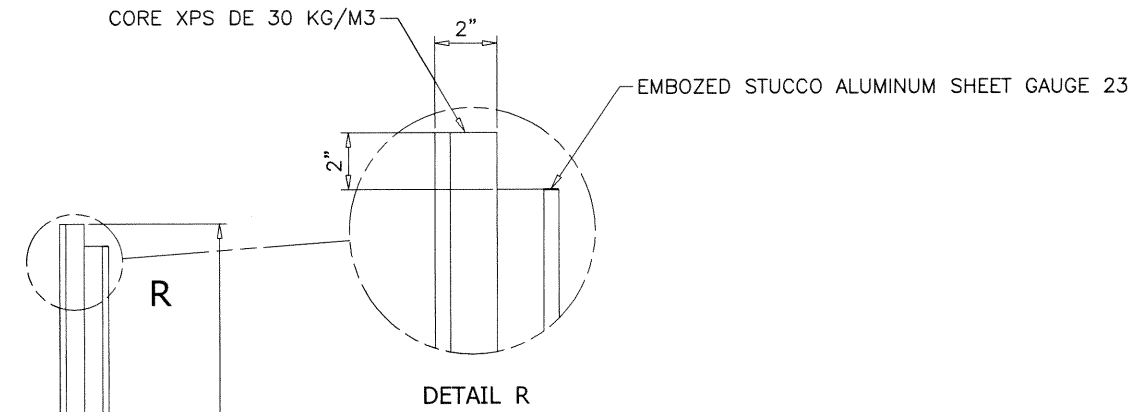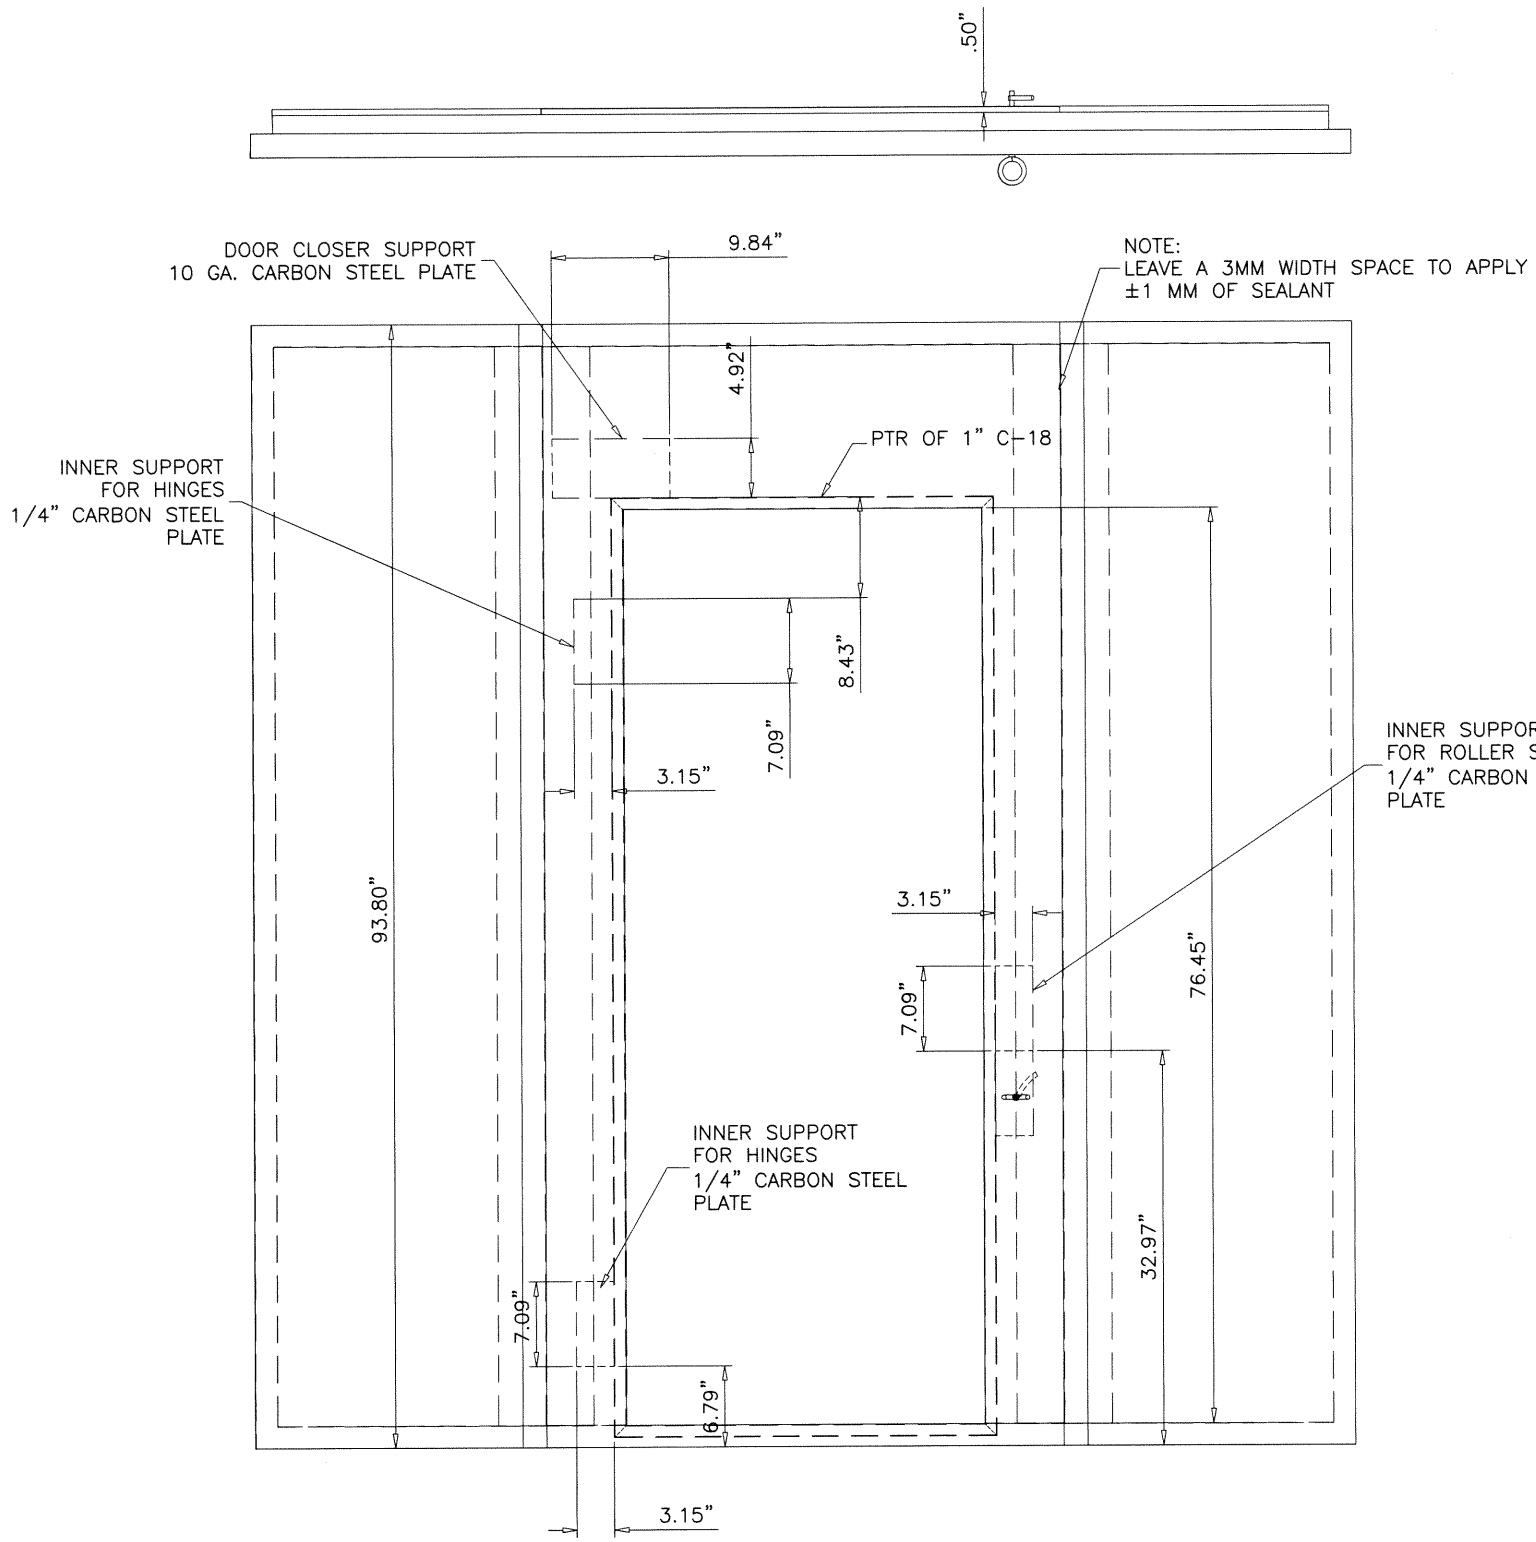

ALL THE REINFORCEMENTS MUST BE WELD TO THE DOOR FRAME SEAM WELD CONTINUOUSLY BECAUSE IT WILL BE UNDERGOING TO CONSTANT EFFORT

USE 1"X 1" CARBON STEEL TUBES 18 GA. FOR THE DOOR FRAME

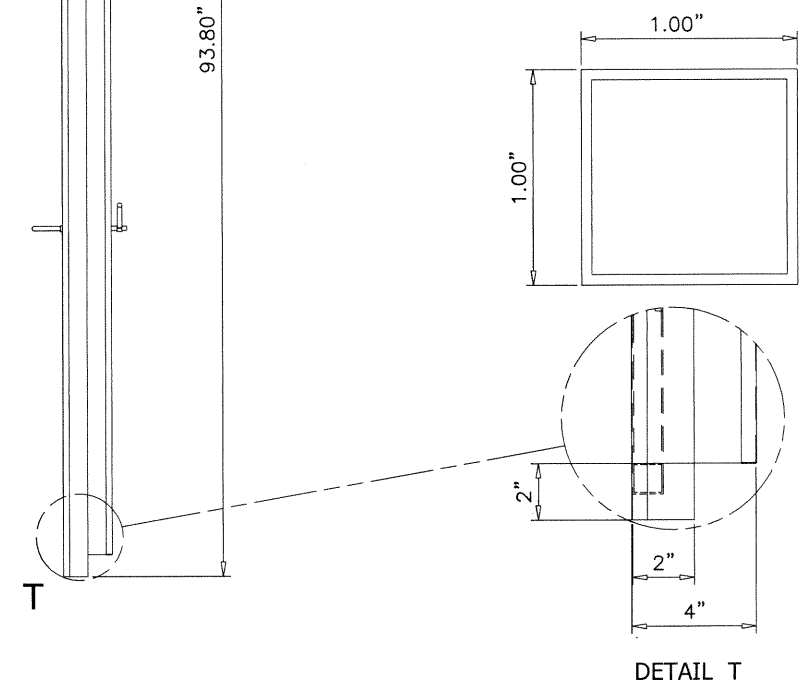

Sealed: 5/27/2021

WALK-IN COOLER & FREEZER




Barcel USA LLC.
 301 Northpoint Drive, Suite 100
 Coppell, TX 75019
 Phone: (972) 591-2493 Fax: (214) 441-9757

revisions:	
no	date by description

date: 11-20-20 scale: 3/4"=1'-0" dr. by: - chk. by: -

drawing no. **20-95T**

sheet 19 of 47

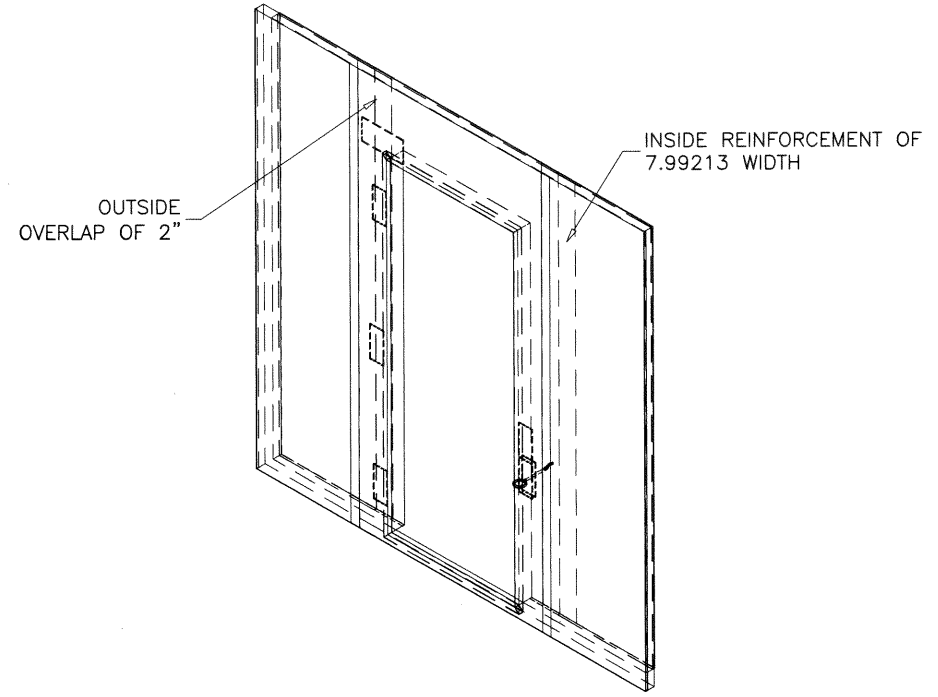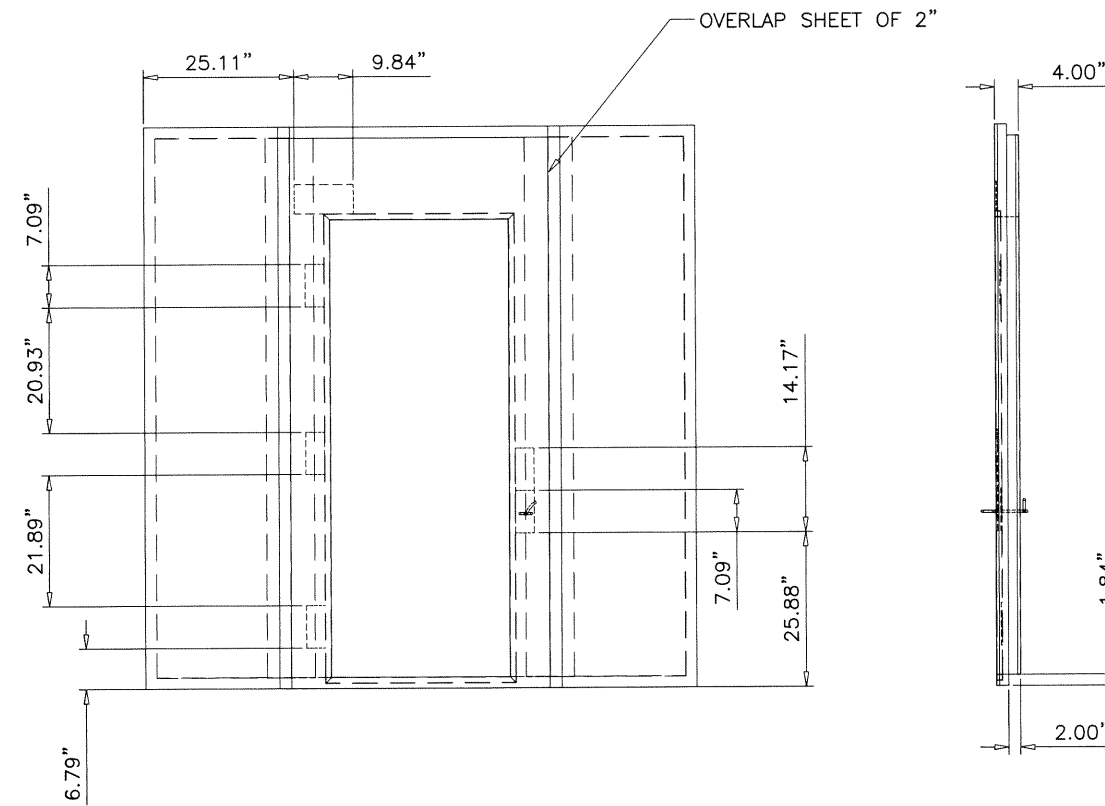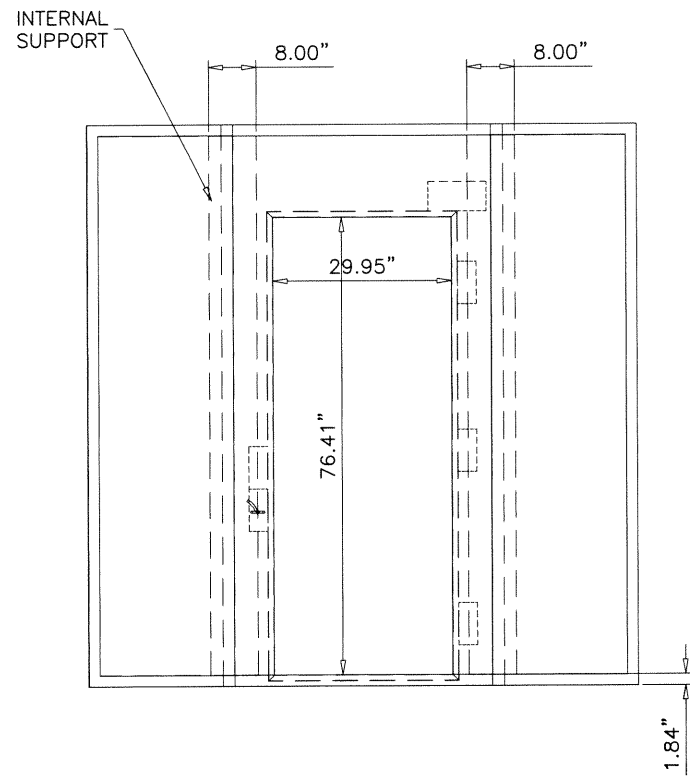

Sealed: 5/27/2021

af c

AL-FAROOQ CORPORATION
 ENGINEERS & PRODUCT DEVELOPMENT
 9360 SUNSET DRIVE, SUITE 220
 MIAMI, FLORIDA 33173 (C.A.N. 3538)
 TEL. (305) 264-8100 FAX. (305) 262-6978
 COOLER\20-95T-BUS

WALK-IN COOLER & FREEZER

Barcel USA LLC.
 301 Northpoint Drive, Suite 100
 Coppell, TX 75019
 Phone: (972) 591-2493 Fax: (214) 441-9757

revisions:	
no	date by description


date: 11-20-20
 scale: 3/8"=1'-0"
 dr. by: -
 chk. by:

drawing no.
20-95T

sheet 20 of 47

PANEL MADE OF EXTRUDED POLYSTYRENE FOAM (XPS) WITH A 30 KG/M³ DENSITY AND COMPRESSION RESISTANCE OF 25 LBS/IN. OUTER FINISH IS GALVANIZED STEEL SHEET GAUGE 26 AND INNER FINISH IS ALUMINUM SHEET GAUGE 23 EXCEPT FOR THE FLOOR WHICH IS GAUGE 14.

PARTS LIST			
ITEM	QTY	PART NUMBER	DESCRIPTION
E2	3	INTERIOR CEILING PANEL SHEET	EMBOZED STUCCO ALUMINUM SHEET GAUGE 23
E3	3	EXTERIOR CEILING PANEL SHEET	WHITE PAINTED GALVANIZED STEEL SHEET GAUGE 26 TERNIUM ZINTRO G60
E4	3	CEILING INNER REINFORCEMENT	2" X 2" CARBON STEEL TUBE GAUGE 18
E5	3	INNER SUPPORT SHEET	GALVANIZED STEEL SHEET GAUGE 26
E6	8	INNER REINFORCEMENT FOR THE EVAPORATOR	GALVANIZED STEEL SHEET GAUGE 10
E7	1	SHORT INTERNAL CEILING SHEET	EMBOZED STUCCO ALUMINUM SHEET GAUGE 23
E8	1	SHORT EXTERNAL CEILING SHEET	WHITE PAINTED GALVANIZED STEEL SHEET GAUGE 26 TERNIUM ZINTRO G60

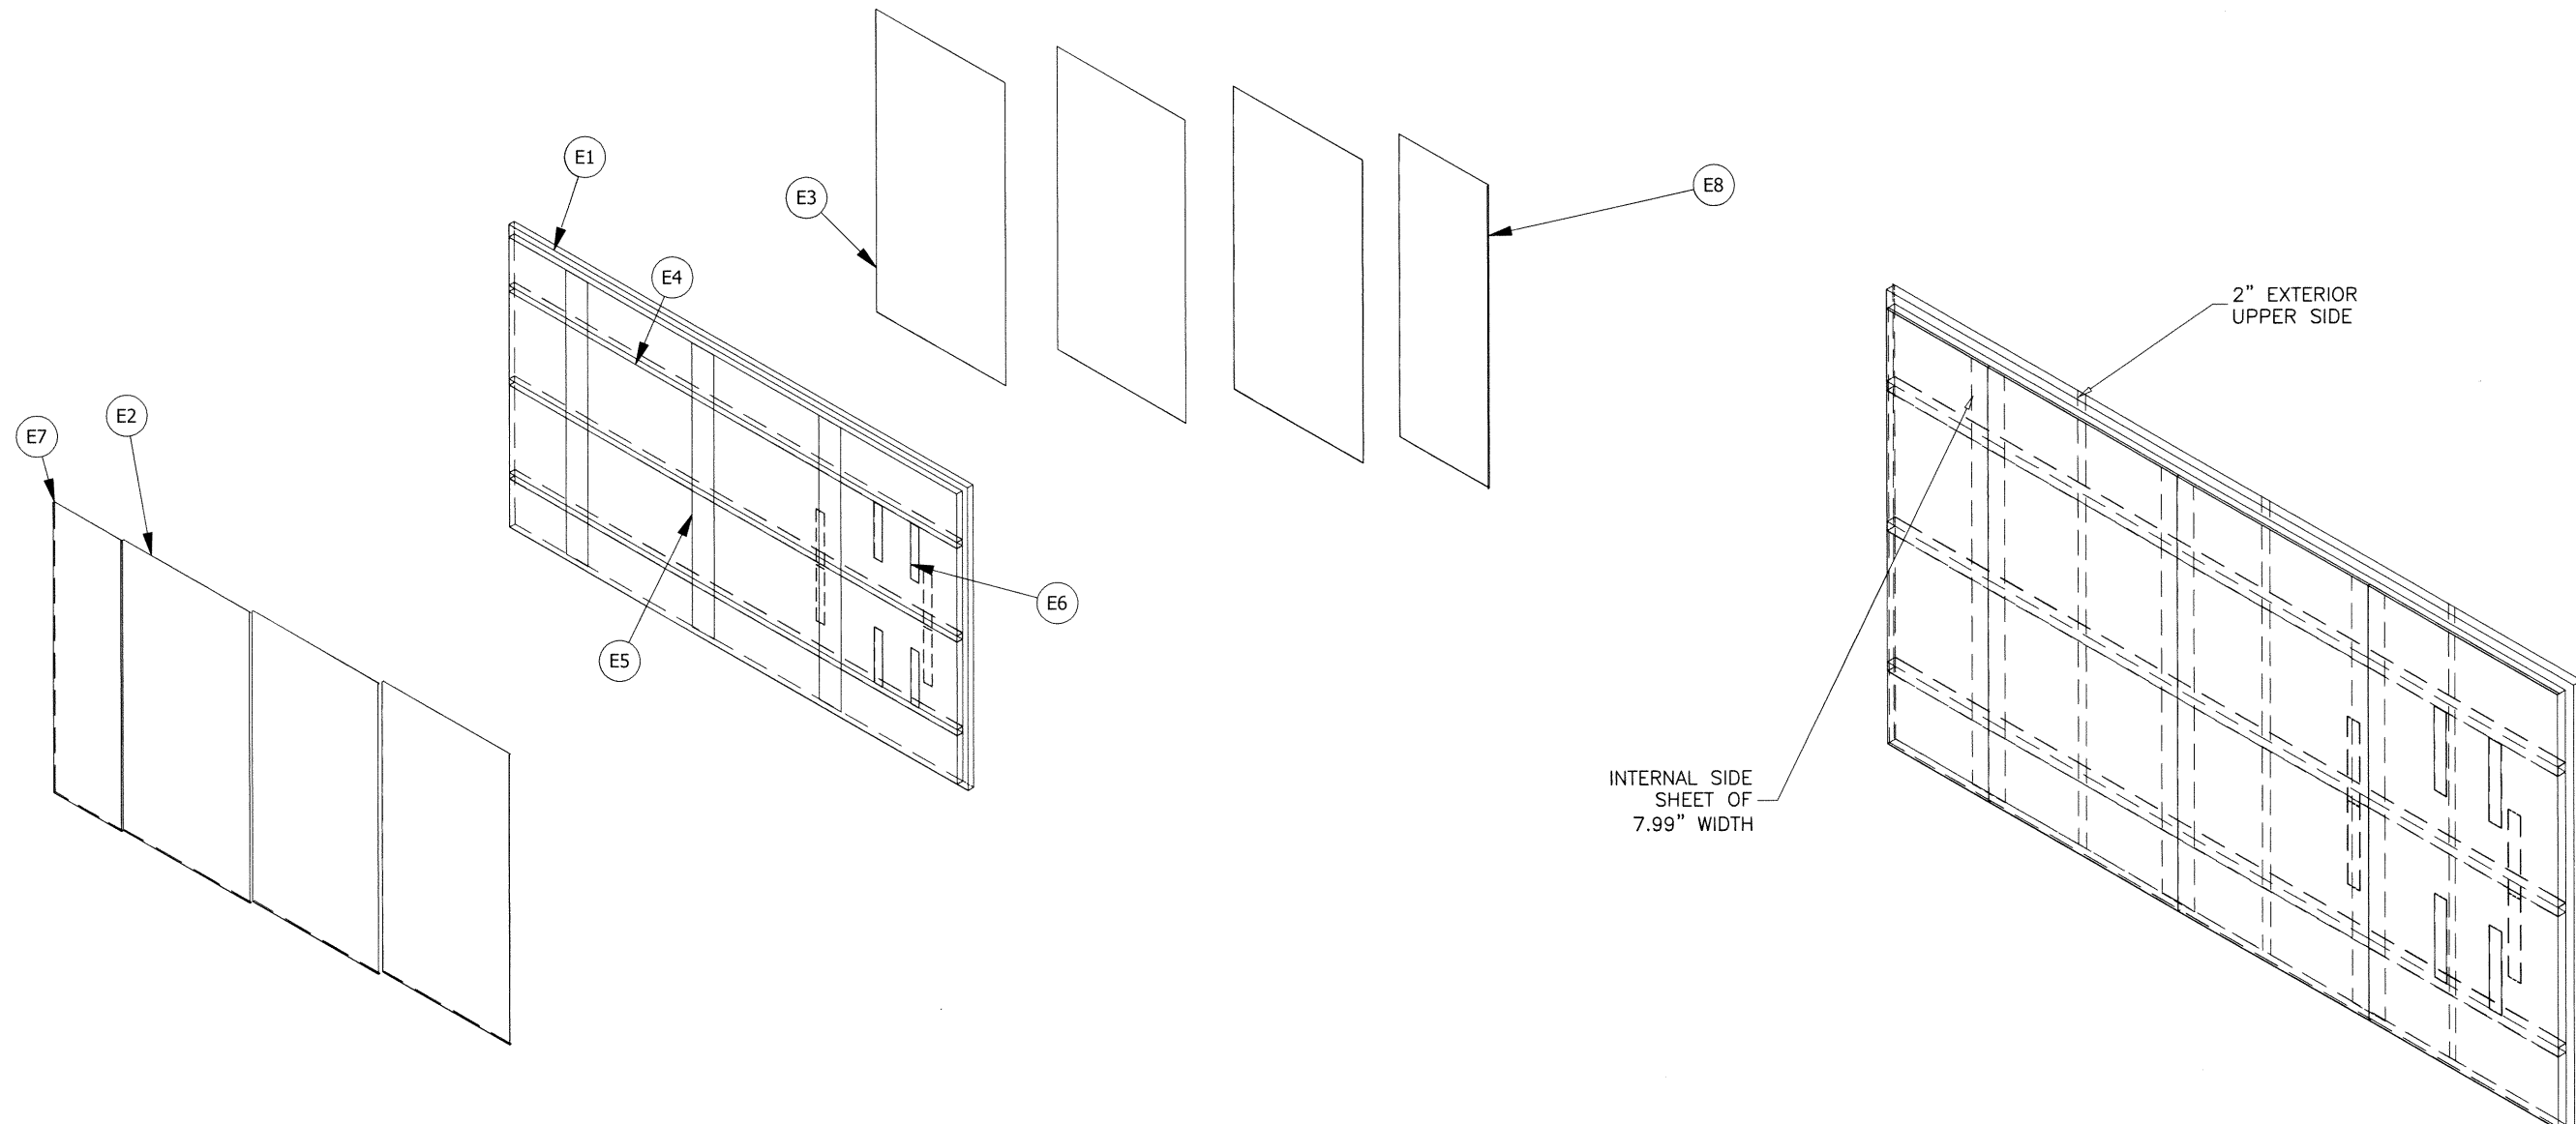


a f c
AL-FAROOQ CORPORATION
 ENGINEERS & PRODUCT DEVELOPMENT
 9360 SUNSET DRIVE, SUITE 220 (C.A.N. 5538)
 MIAMI, FLORIDA 33173
 TEL. (305) 264-8100 FAX. (305) 262-6978
 COOLER 20-95T-BUS

WALK-IN COOLER & FREEZER
Barcel USA LLC.
 301 Northpoint Drive, Suite 100
 Coppell, TX 75019
 Phone: (972) 591-2493 Fax: (214) 441-9757


revisions:	
no	date by description

date: 11-20-20
 scale: 3/8"=1'-0"
 dr. by: -
 chk. by:

drawing no.
20-95T
 sheet 21 of 47



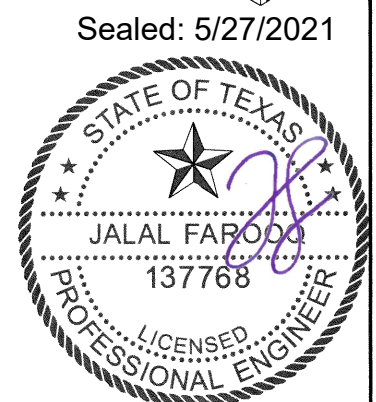


Sealed: 5/27/2021

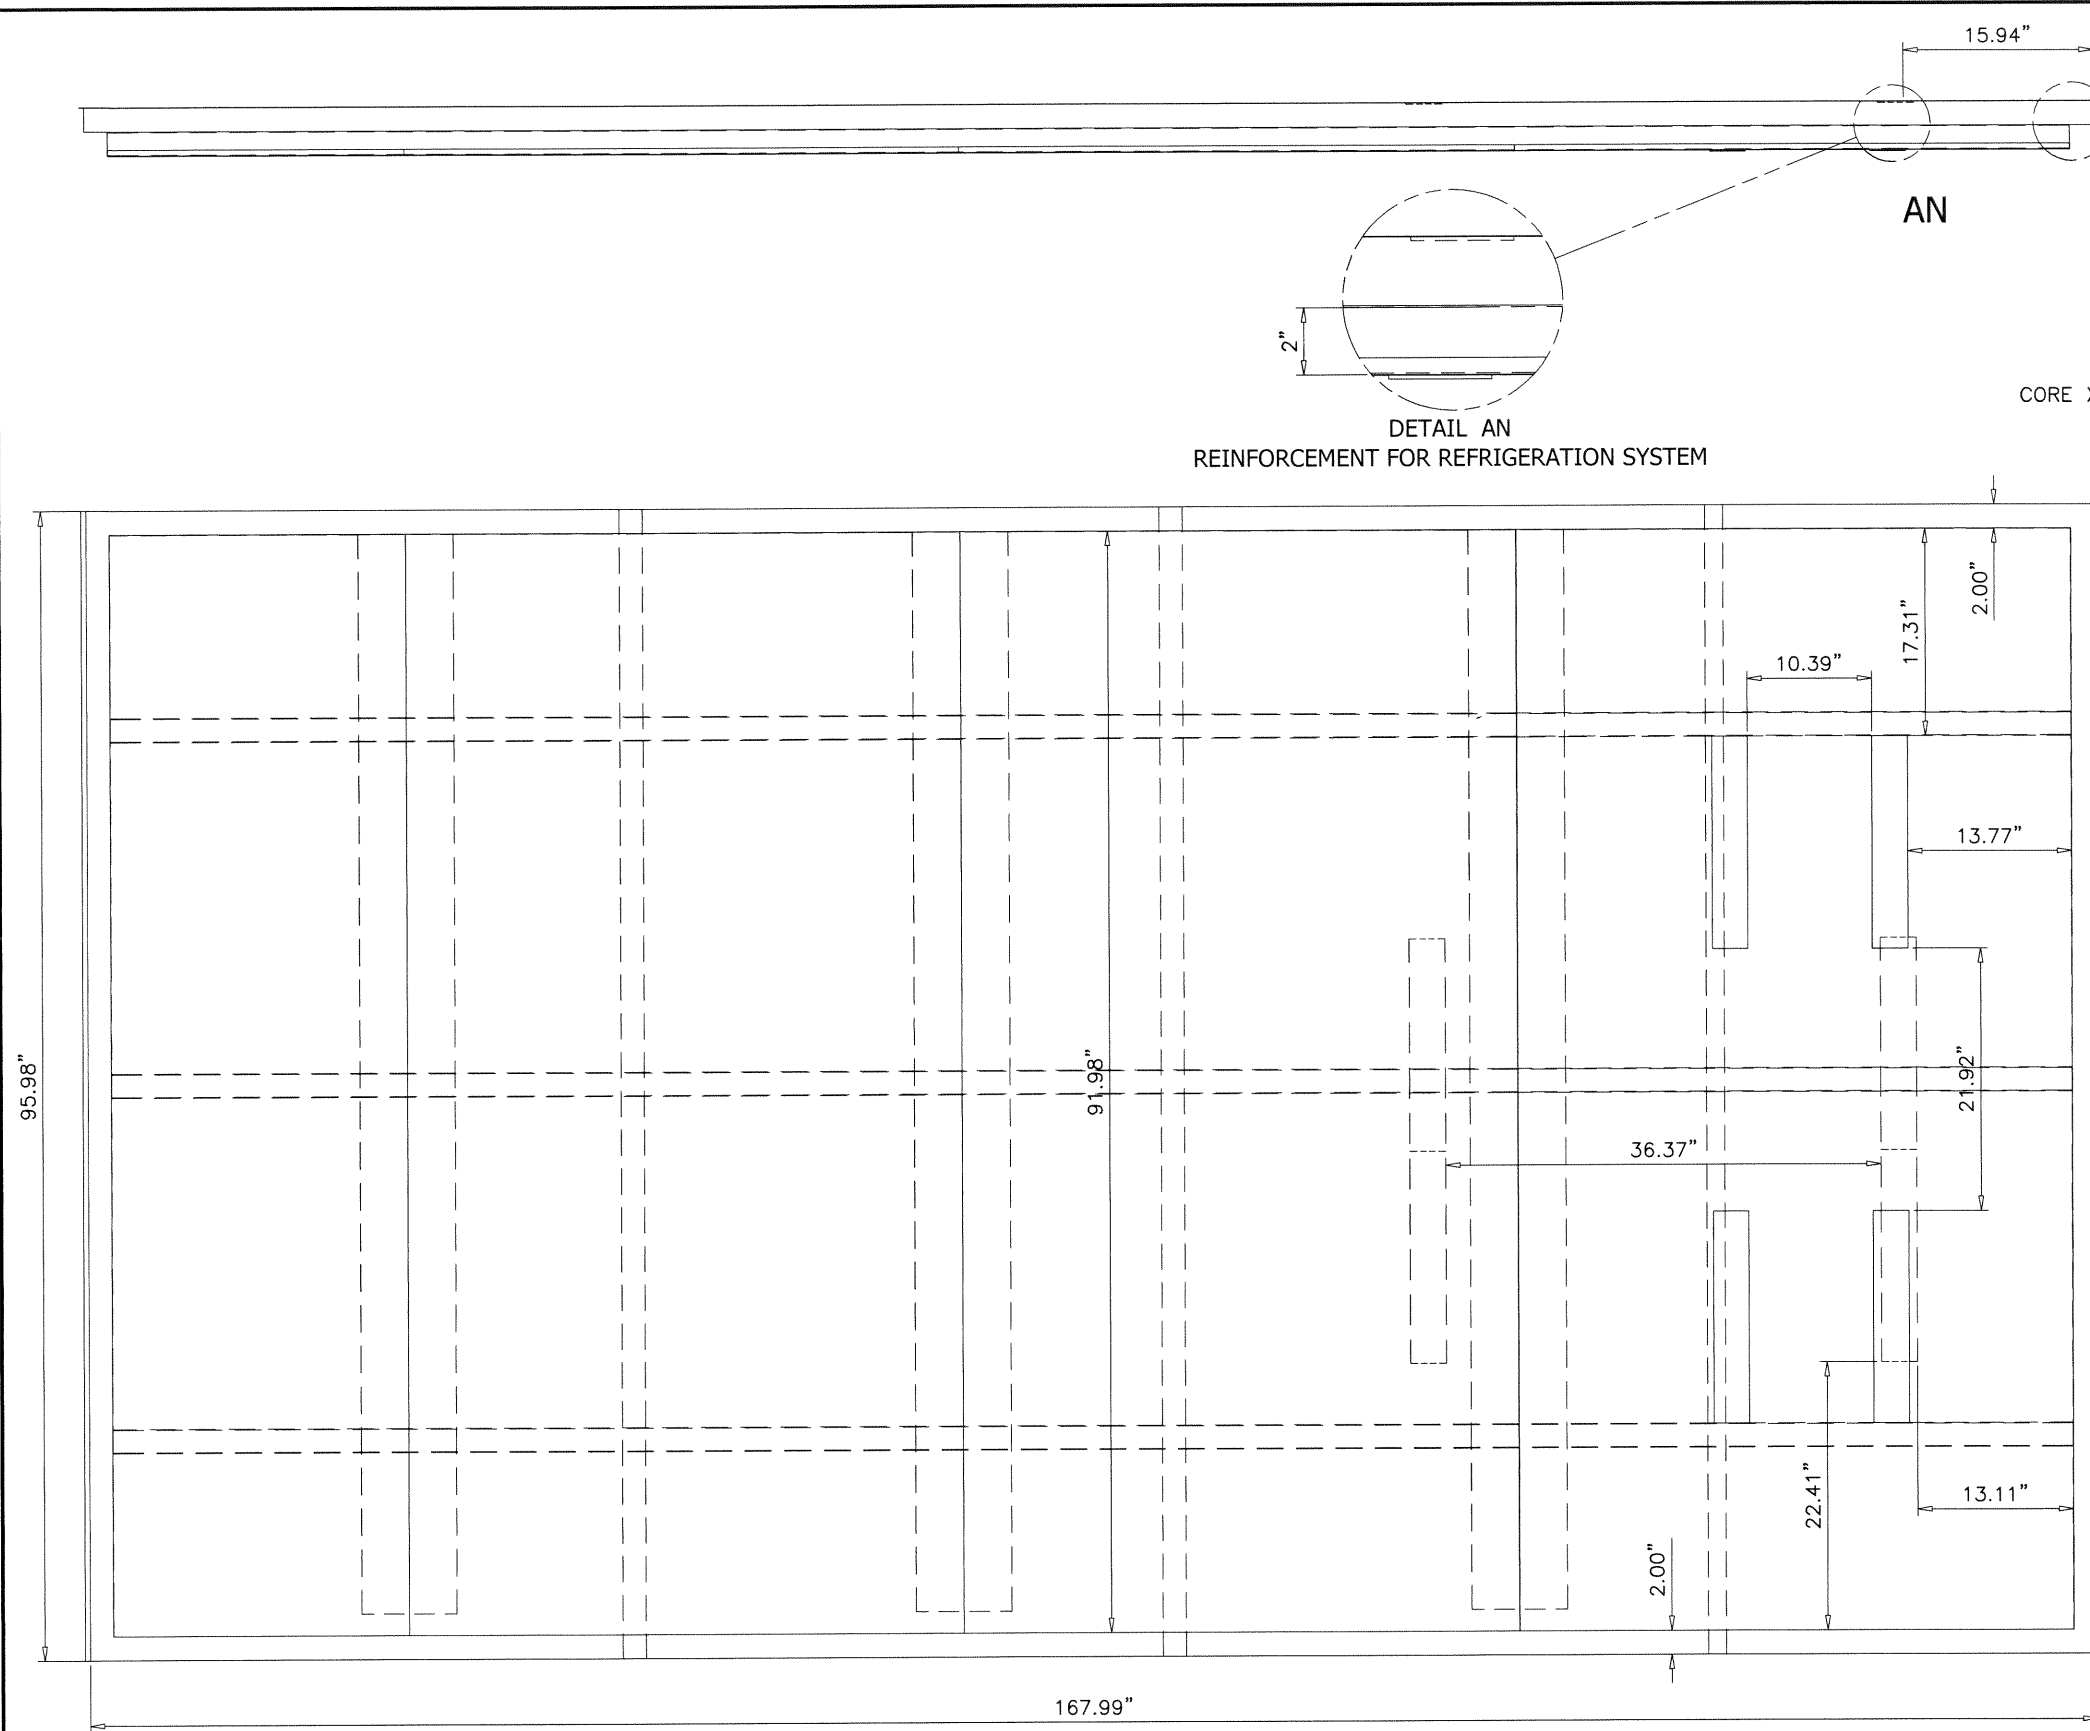

DETAIL AN
REINFORCEMENT FOR REFRIGERATION SYSTEM

CORE XPS THICKNESS OF 4"
30 KG/M3 DENSITY

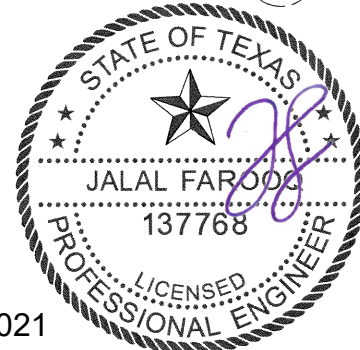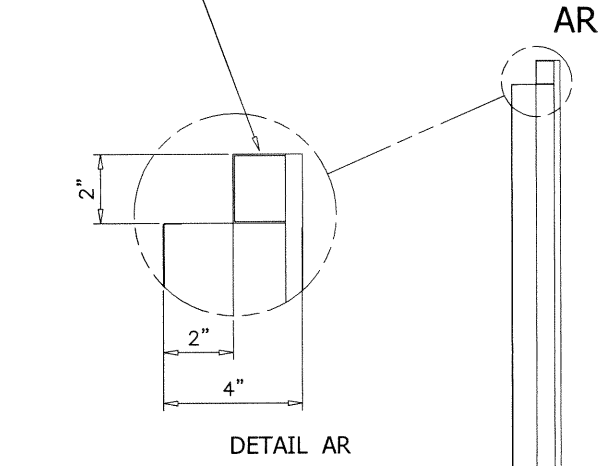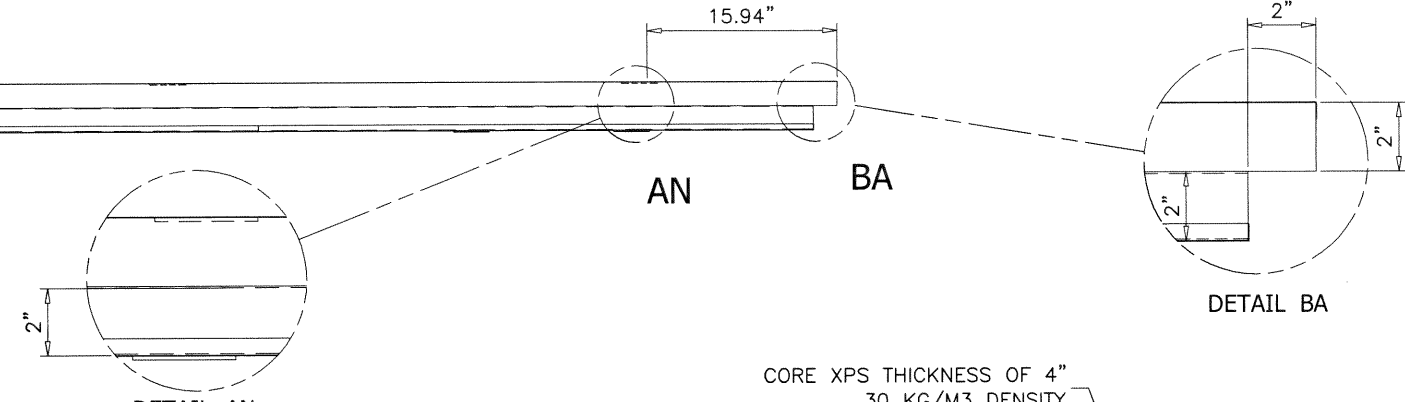

Sealed: 5/27/2021

afc
AL-FAROOQ CORPORATION
 ENGINEERS & PRODUCT DEVELOPMENT
 9360 SUNSET DRIVE, SUITE 220 (C.A.N. 3538)
 MIAMI, FLORIDA 33173
 TEL. (305) 264-8100 FAX. (305) 262-6978
 COOLER\20-95T-BUS




WALK-IN COOLER & FREEZER
Barcel USA LLC.
 301 Northpoint Drive, Suite 100
 Coppell, TX 75019
 Phone: (972) 591-2493 Fax: (214) 441-9757

no	date	by	description

date: 11-20-20
 scale: 3/4"=1'-0"
 dr. by: -
 chk. by:

drawing no.
20-95T
 sheet 22 of 47

PARTS LIST			
ITEM	QTY	PART NUMBER	DESCRIPTION
E2	3	INTERIOR CEILING PANEL SHEET	EMBOZED STUCCO ALUMINUM SHEET GAUGE 23
E3	3	EXTERIOR CEILING PANEL SHEET	WHITE PAINTED GALVANIZED STEEL SHEET GAUGE 26 TERNIUM ZINTRO G60
E4	3	CEILING INNER REINFORCEMENT	2" X 2" CARBON STEEL TUBE GAUGE 18
E5	3	INNER SUPPORT SHEET	GALVANIZED STEEL SHEET GAUGE 26
E6	8	INNER REINFORCEMENT FOR THE EVAPORATOR	GALVANIZED STEEL SHEET GAUGE 10
E7	1	SHORT INTERNAL CEILING SHEET	EMBOZED STUCCO ALUMINUM SHEET GAUGE 23
E8	1	SHORT EXTERNAL CEILING SHEET	WHITE PAINTED GALVANIZED STEEL SHEET GAUGE 26 TERNIUM ZINTRO G60

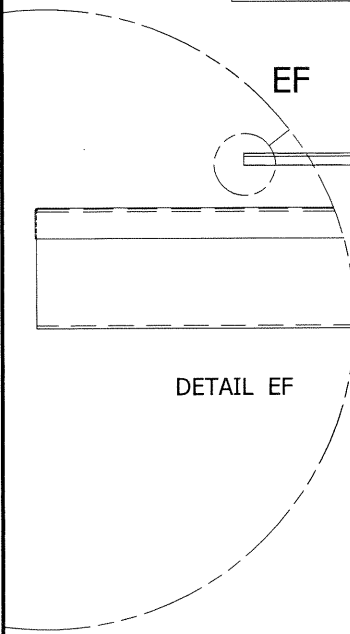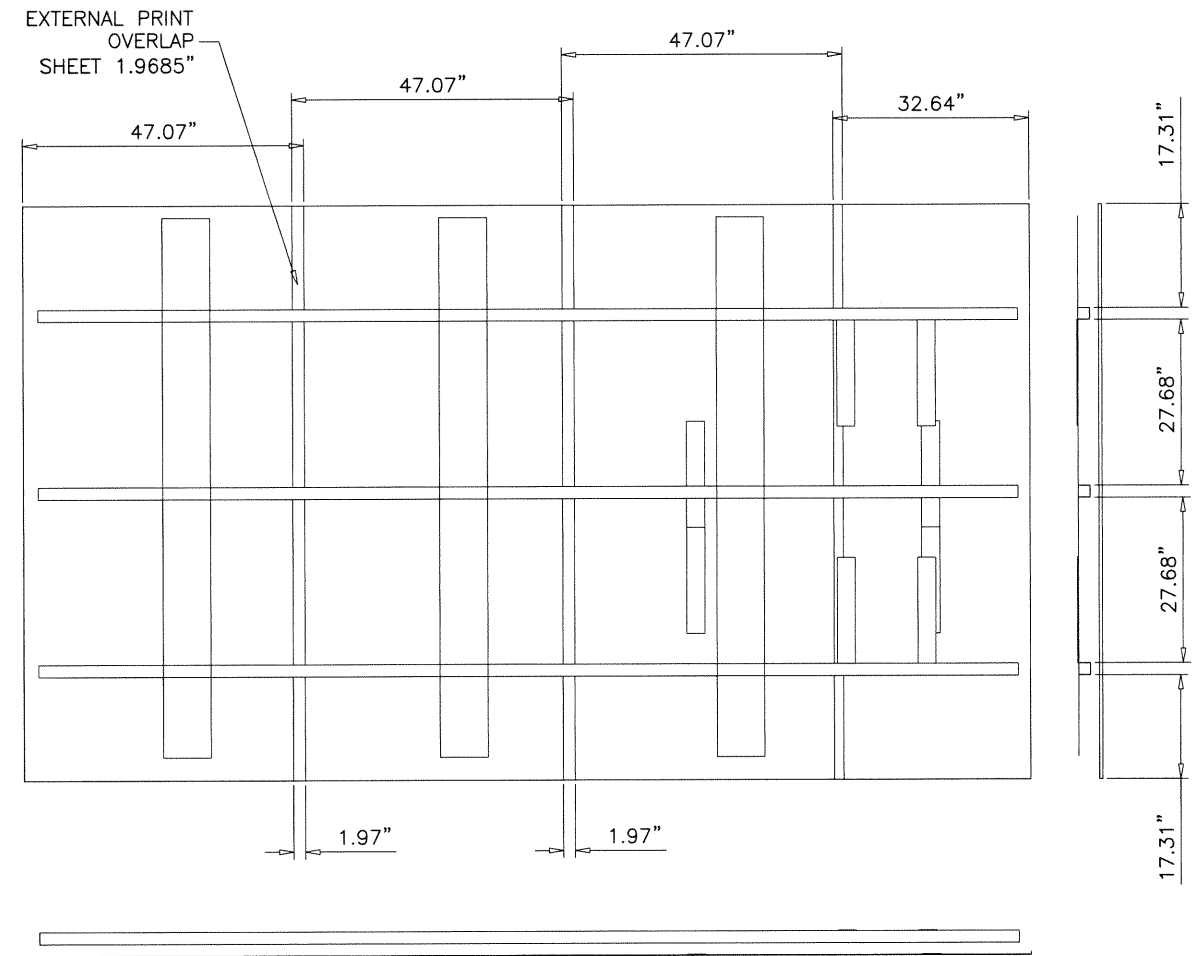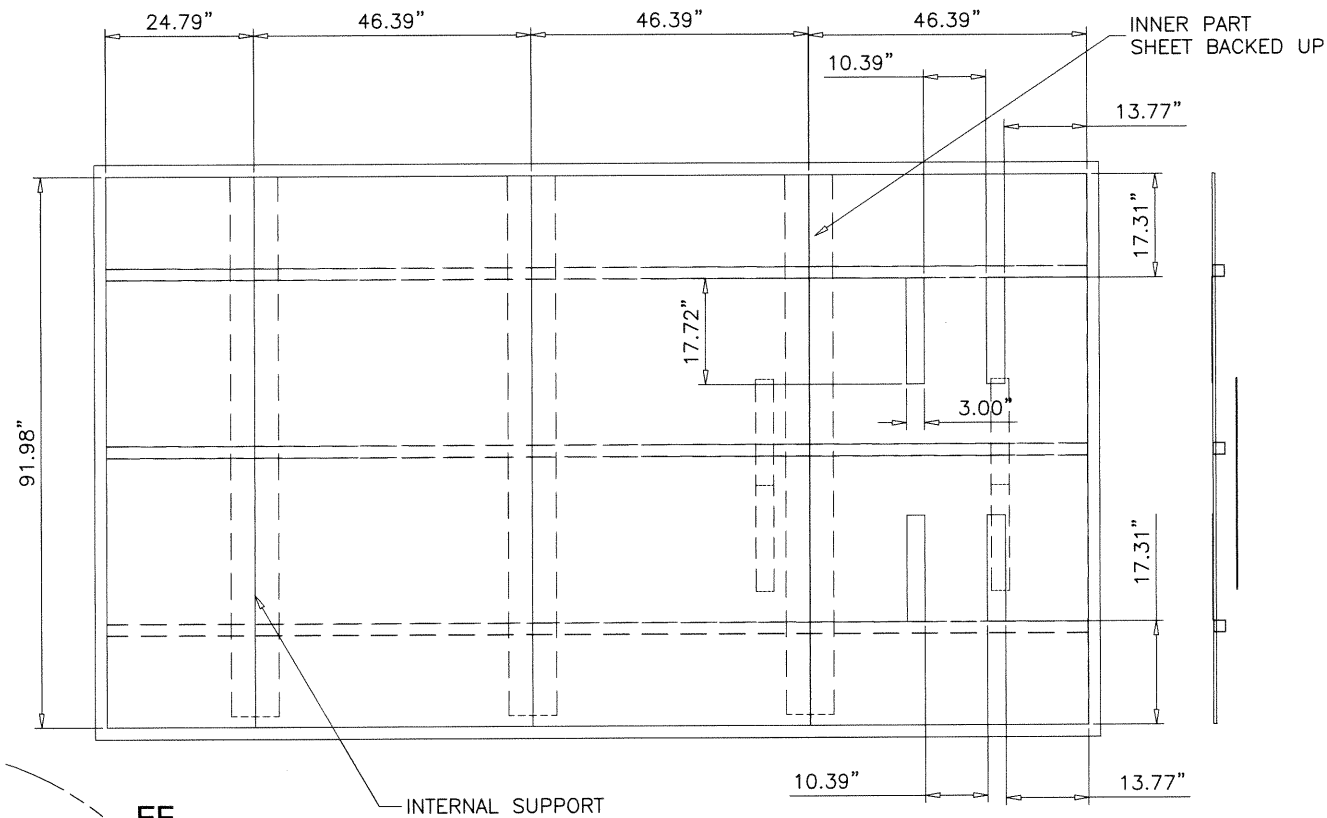

Sealed: 5/27/2021

STATE OF TEXAS
JALAL FAROOQ
137768
LICENSED PROFESSIONAL ENGINEER

a f c
AL-FAROOQ CORPORATION
ENGINEERS & PRODUCT DEVELOPMENT
9360 SUNSET DRIVE, SUITE 220
MIAMI, FLORIDA 33173 (C.A.N. 3538)
TEL. (305) 264-8100 FAX. (305) 262-6978
COOLER\20-95T-BUS

WALK-IN COOLER & FREEZER
Barcel USA LLC.
301 Northpoint Drive, Suite 100
Coppell, TX 75019
Phone: (972) 591-2493 Fax: (214) 441-9757




revisions:	
no	date by description

date: 11-20-20
scale: 3/8"=1'-0"
dr. by: -
chk. by: -

drawing no.
20-95T


sheet **23** of **47**

PARTS LIST			
ITEM	QTY	PART NUMBER	DESCRIPTION
E4	3	CEILING INNER REINFORCEMENT	2" X 2" CARBON STEEL TUBE GAUGE 18

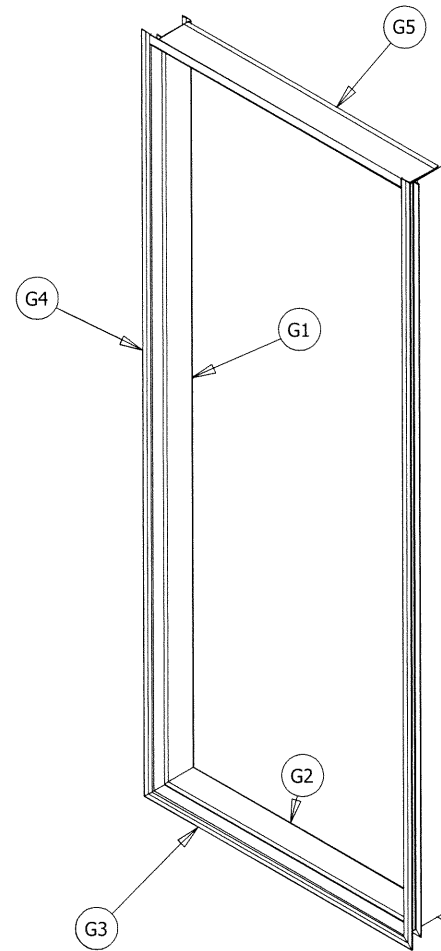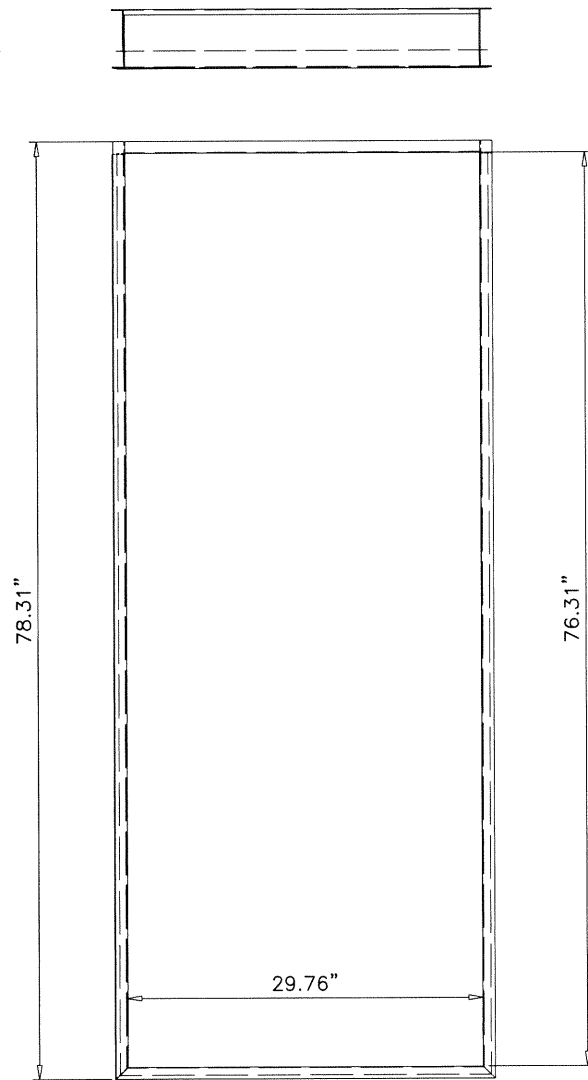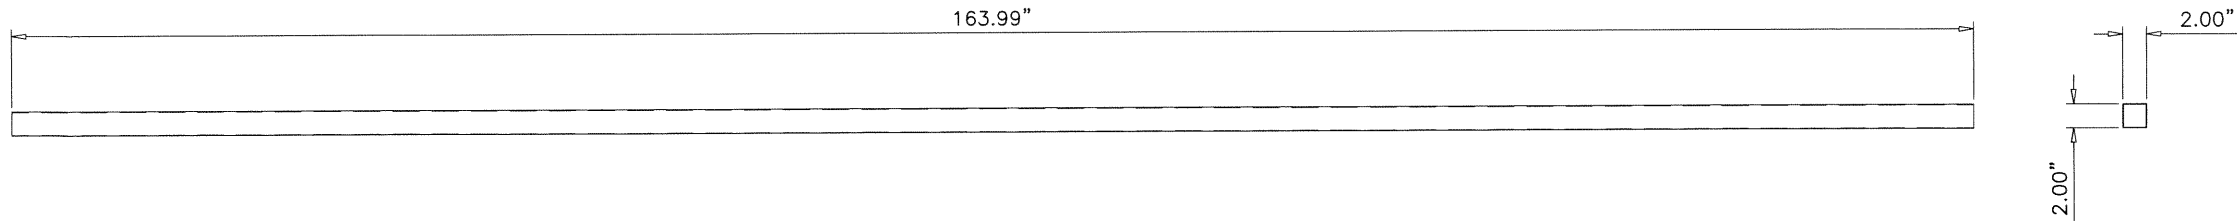

PARTS LIST			
ITEM	QTY	PART NUMBER	DESCRIPTION
G	1	DOOR FRAME	
G1	2	LARGE VERTICAL COVER	GALVANIZED STEEL SHEET GAUGE 18
G2	1	HORIZONTAL COVER TYPE A	GALVANIZED STEEL SHEET GAUGE 18
G3	1	HORIZONTAL DOOR FRAMING	GALVANIZED STEEL SHEET GAUGE 18
G4	2	VERTICAL DOOR FRAMING	GALVANIZED STEEL SHEET GAUGE 18
G5	1	HORIZONTAL COVER TYPE AA	GALVANIZED STEEL SHEET GAUGE 18

Sealed: 5/27/2021

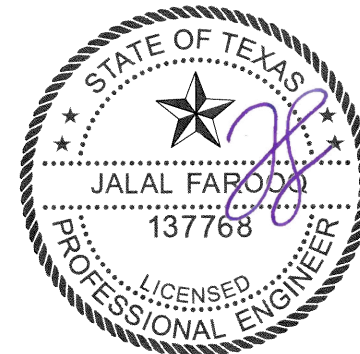


afc
AL-FAROOQ CORPORATION
 ENGINEERS & PRODUCT DEVELOPMENT
 9360 SUNSET DRIVE, SUITE 220
 MIAMI, FLORIDA 33173 (C.A.N. 3538)
 TEL. (305) 264-8100 FAX. (305) 262-6978
 COOLER\20-95T-BUS

WALK-IN COOLER & FREEZER
Barcel USA LLC.
 301 Northpoint Drive, Suite 100
 Coppell, TX 75019
 Phone: (972) 591-2493 Fax: (214) 441-9757


revisions:	
no	date by description

date: 11-20-20 scale: 3/4"=1'-0" dr. by: - chk. by: -
 drawing no. 20-95T
 sheet 24 of 47

PARTS LIST			
ITEM	QTY	PART NUMBER	DESCRIPTION
G1	2	LARGE VERTICAL COVER	GALVANIZED STEEL SHEET GAUGE 18

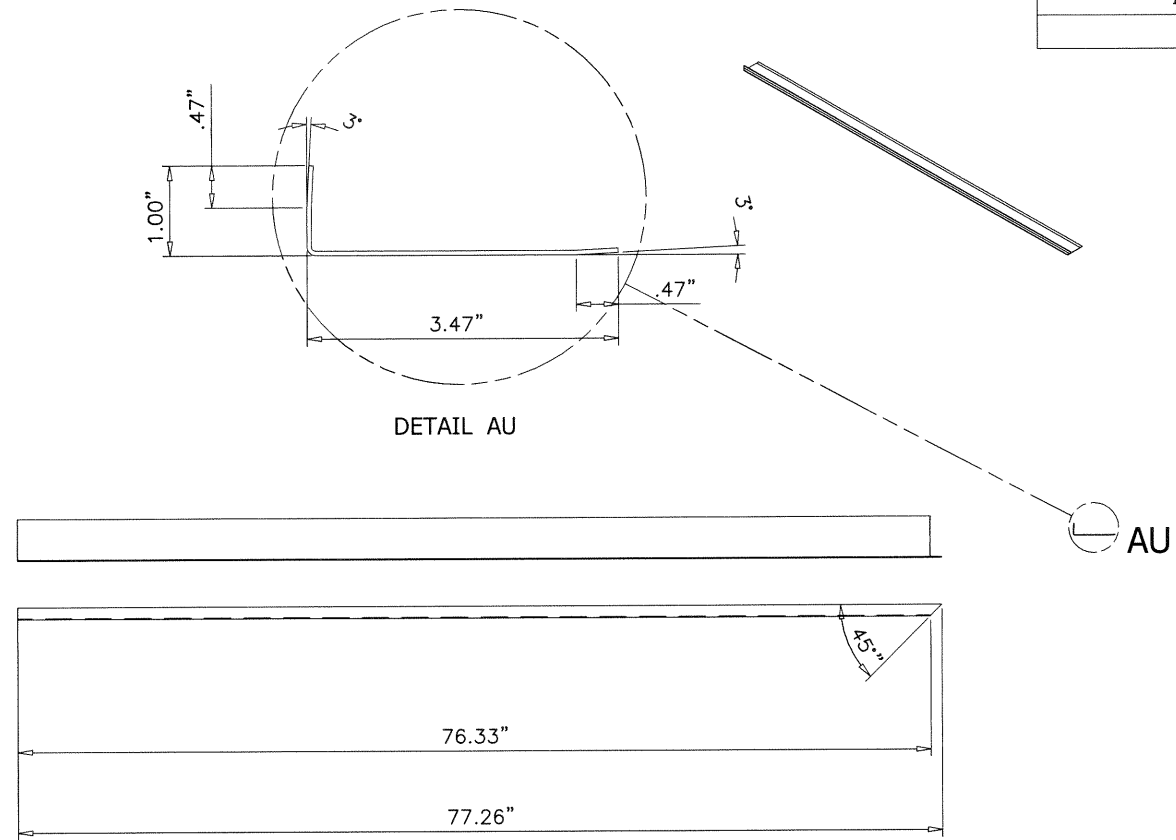


PARTS LIST			
ITEM	QTY	PART NUMBER	DESCRIPTION
G2	2	HORIZONTAL COVER TYPE A	GALVANIZED STEEL SHEET GAUGE 18

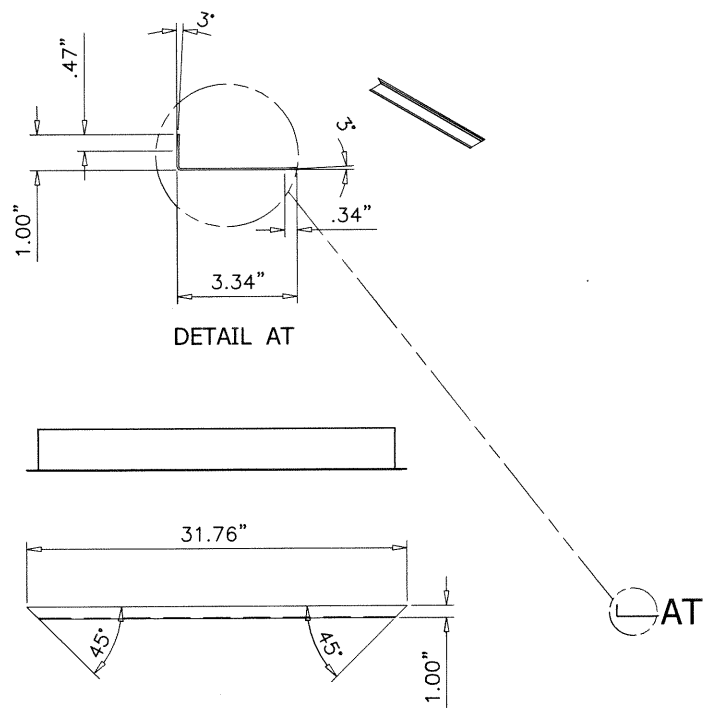


afc
AL-FAROQQ CORPORATION
 ENGINEERS & PRODUCT DEVELOPMENT
 9360 SUNSET DRIVE, SUITE 220 (C.A.N. 3538)
 MIAMI, FLORIDA 33173
 TEL. (305) 264-8100 FAX. (305) 262-6978
 COOLER\20-95T-BUS

WALK-IN COOLER & FREEZER
Barcel USA LLC.
 301 Northpoint Drive, Suite 100
 Coppell, TX 75019
 Phone: (972) 591-2493 Fax: (214) 441-9757


revisions:	no	date	by	description
date:	11-20-20	scale:	3/4"=1'-0"	
dr. by:		chk. by:		
drawing no.	20-95T			
sheet	25 of 47			

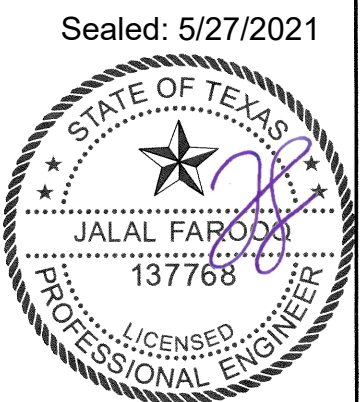


PARTS LIST			
ITEM	QTY	PART NUMBER	DESCRIPTION
G3	2	HORIZONTAL DOOR FRAMING	GALVANIZED STEEL SHEET GAUGE 18

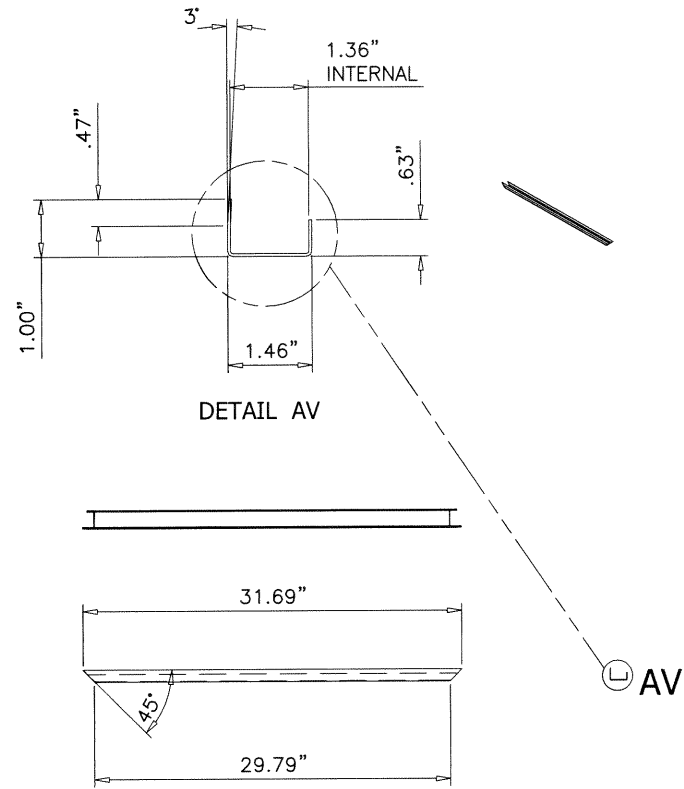

PARTS LIST			
ITEM	QTY	PART NUMBER	DESCRIPTION
G5	1	HORIZONTAL COVER TYPE AA	GALVANIZED STEEL SHEET GAUGE 18

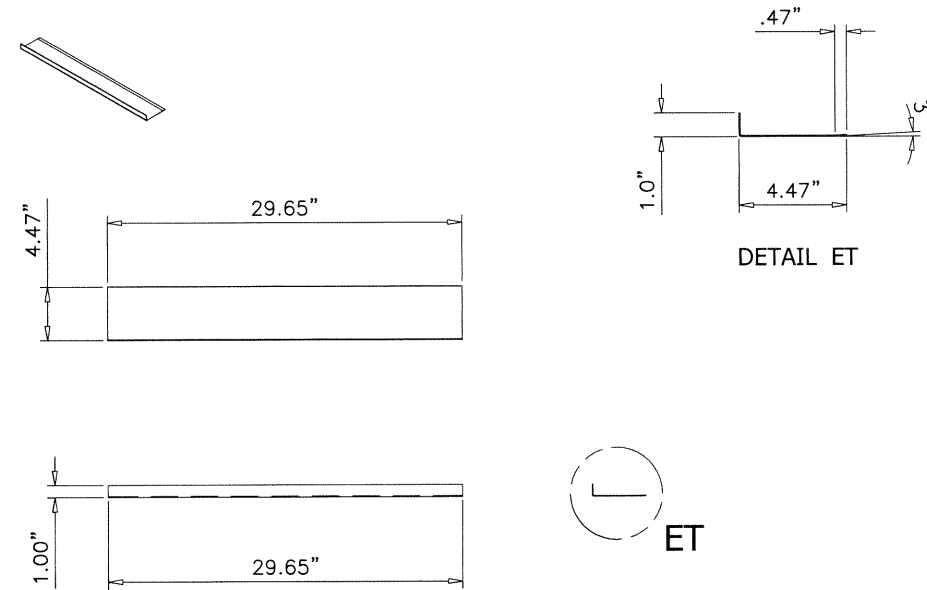

PARTS LIST			
ITEM	QTY	PART NUMBER	DESCRIPTION
G4	2	VERTICAL DOOR FRAMING	GALVANIZED STEEL SHEET GAUGE 18

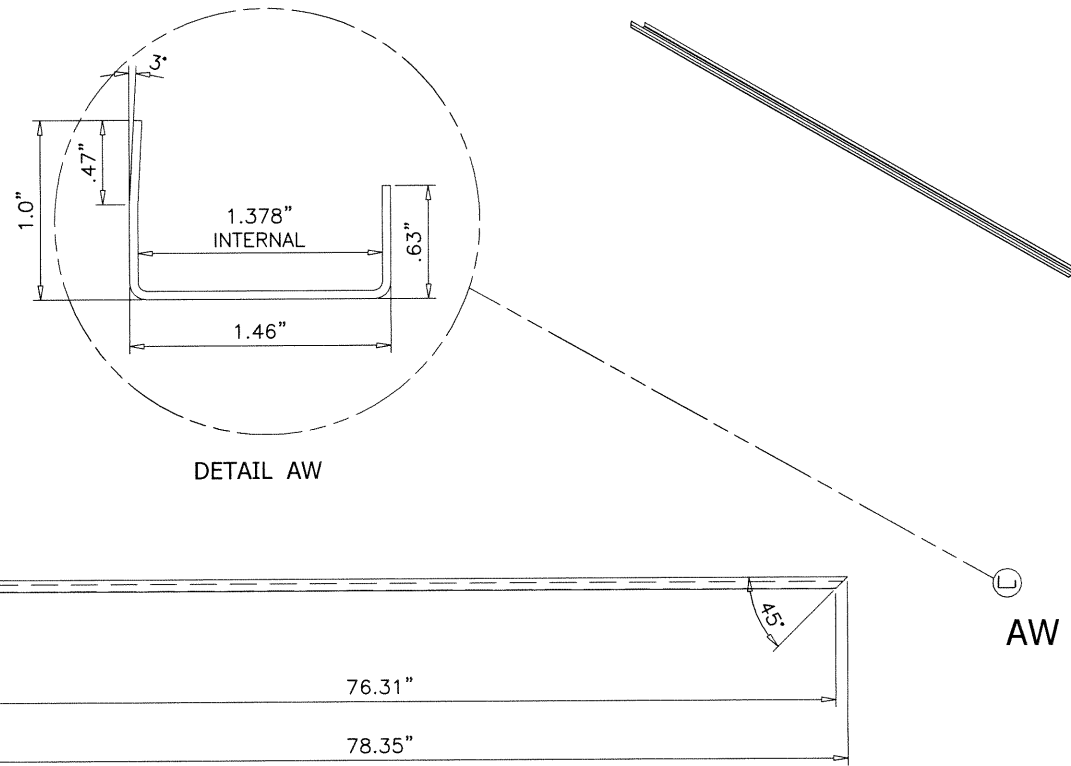


afc
AL-FAROQQ CORPORATION
 ENGINEERS & PRODUCT DEVELOPMENT
 9360 SUNSET DRIVE, SUITE 220 (C.A.N. 3538)
 MIAMI, FLORIDA 33173
 TEL. (305) 264-8100 FAX. (305) 262-6978
 COOLER\20-95T-BUS

WALK-IN COOLER & FREEZER
Barcel USA LLC.
 301 Northpoint Drive, Suite 100
 Coppell, TX 75019
 Phone: (972) 591-2493 Fax: (214) 441-9757

revisions:	no	date	by	description
date:	11-20-20	scale:	3/4"=1'-0"	
dr. by:		chk. by:		
drawing no.	20-95T			
sheet	26 of 47			



PARTS LIST		
ITEM	QTY	DESCRIPTION
H	1	DOOR
H1	1	DOOR FOAM CORE XPS CORE WITH A THICKNESS OF 4", AND 30 KG/M3 DENSITY
H2	1	INTERIOR DOOR SHEET EMBOZED STUCCO ALUMINUM SHEET GAUGE 23
H3	1	EXTERIOR DOOR SHEET WHITE PAINTED GALVANIZED STEEL SHEET GAUGE 26 TERNIUM ZINTRO G60
H4	1	DOOR FRAME 1" X 1" CARBON STEEL TUBE GAUGE 18
H5	2	FRAME A WHITE PAINTED GALVANIZED STEEL SHEET GAUGE 26 TERNIUM ZINTRO G60
H6	2	FRAME B WHITE PAINTED GALVANIZED STEEL SHEET GAUGE 26 TERNIUM ZINTRO G60
H7	1	PADLOCK LATCH 1/4" CARBON STEEL PLATE
H8	1	DOOR CLOSER LATCH GALVANIZED STEEL SHEET GAUGE 14

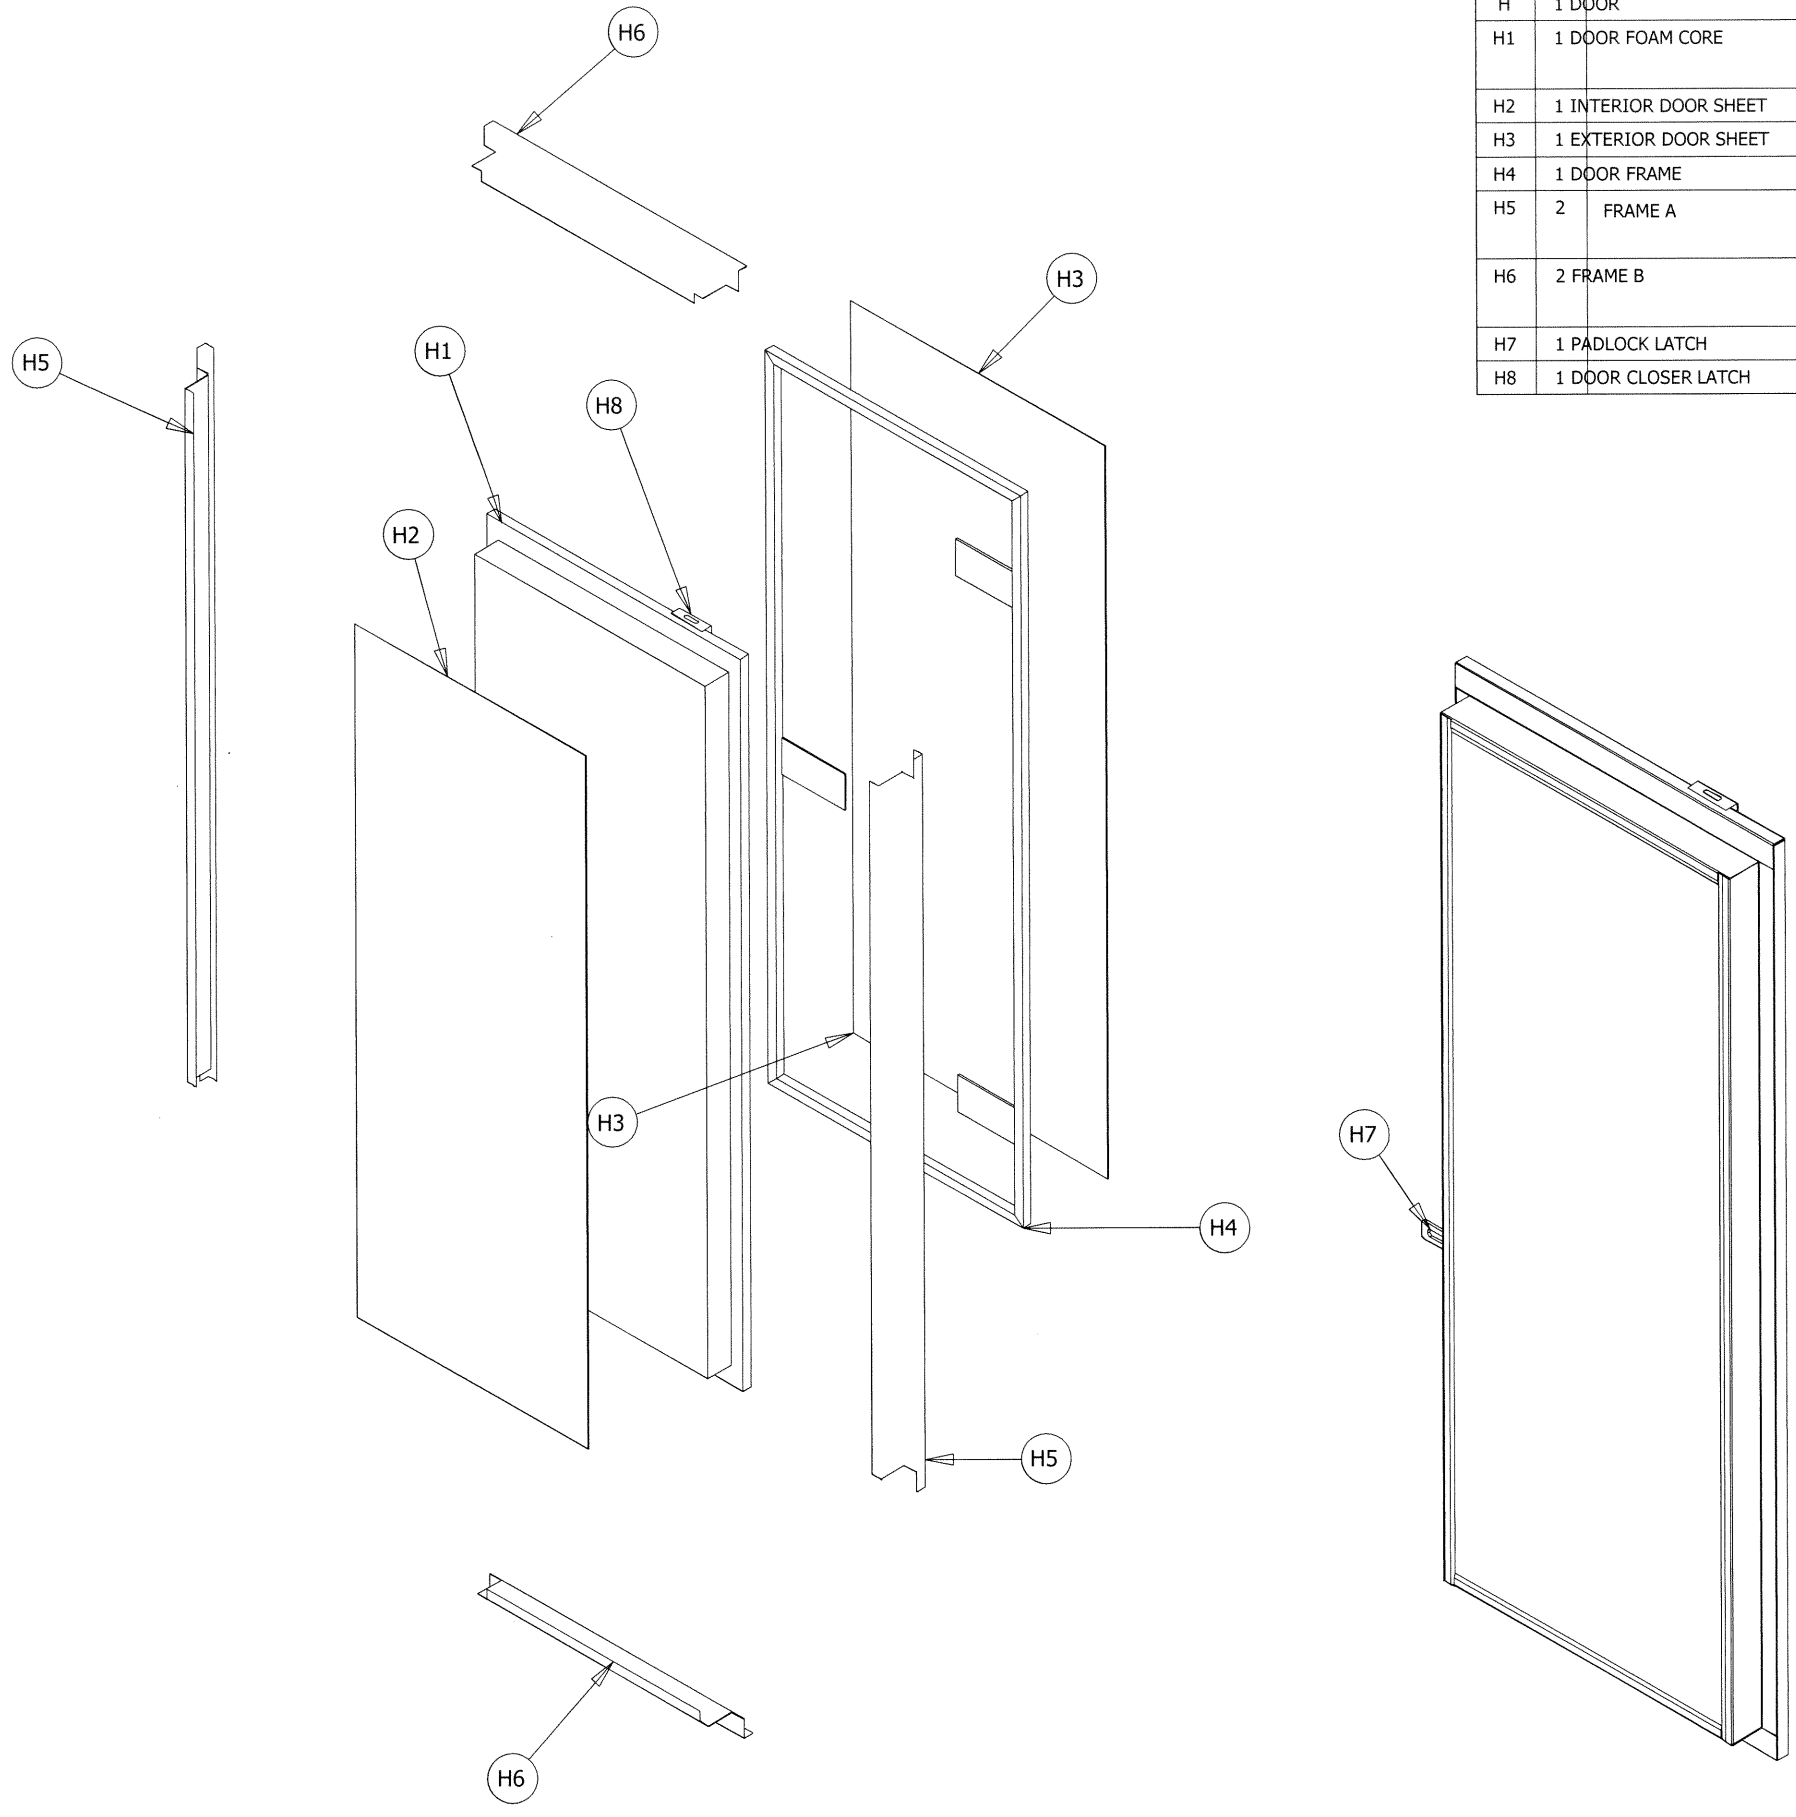


afc
AL-FAROOQ CORPORATION
 ENGINEERS & PRODUCT DEVELOPMENT
 9360 SUNSET DRIVE, SUITE 220 (C.A.N. 3538)
 MIAMI, FLORIDA 33173 FAX. (305) 262-6978
 TEL. (305) 264-8100

WALK-IN COOLER & FREEZER
Barcel USA LLC.
 301 Northpoint Drive, Suite 100
 Coppell, TX 75019
 Phone: (972) 591-2493 Fax: (214) 441-9757

revisions:	no	date	by	description



date: 11-20-20
 scale: 3/4"=1'-0"
 dr. by: -
 chk. by:

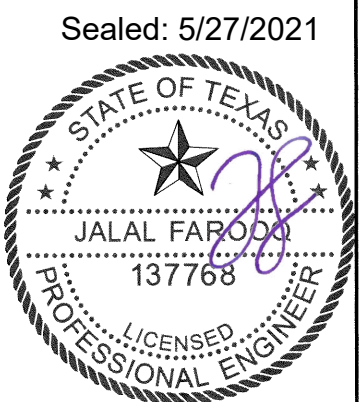

drawing no.
20-95T
 sheet 27 of 47

COOLER\20-95T-BUS


Sealed: 5/27/2021

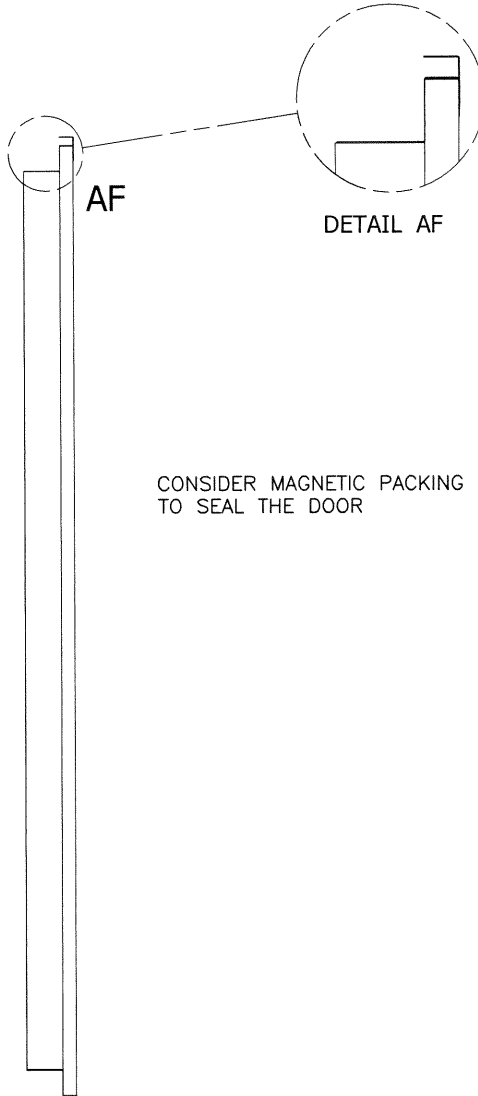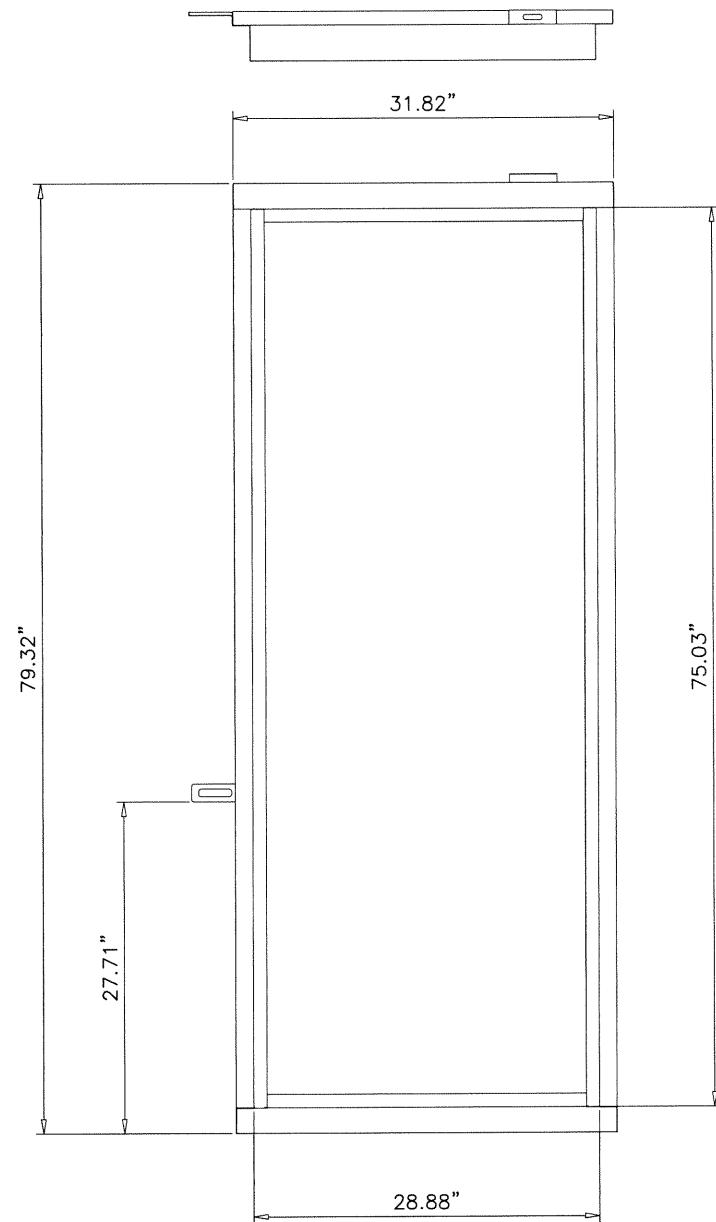

CONSIDER MAGNETIC PACKING TO SEAL THE DOOR

PARTS LIST			
ITEM	QTY	PART NUMBER	DESCRIPTION
H1	1	DOOR FOAM CORE	XPS CORE WITH A THICKNESS OF 4", AND 30 KG/M3 DENSITY
H2	1	INTERIOR DOOR SHEET	EMBOZED STUCCO ALUMINUM SHEET GAUGE 23
H3	1	EXTERIOR DOOR SHEET	WHITE PAINTED GALVANIZED STEEL SHEET GAUGE 26 TERNIUM ZINTRO G60
H4	1	DOOR FRAME	1" X 1" CARBON STEEL TUBE GAUGE 18
H5	2	FRAME A	WHITE PAINTED GALVANIZED STEEL SHEET GAUGE 26 TERNIUM ZINTRO G60
H6	2	FRAME B	WHITE PAINTED GALVANIZED STEEL SHEET GAUGE 26 TERNIUM ZINTRO G60
H7	1	PADLOCK LATCH	1/4" CARBON STEEL PLATE
H8	1	DOOR CLOSER LATCH	GALVANIZED STEEL SHEET GAUGE 14

Sealed: 5/27/2021

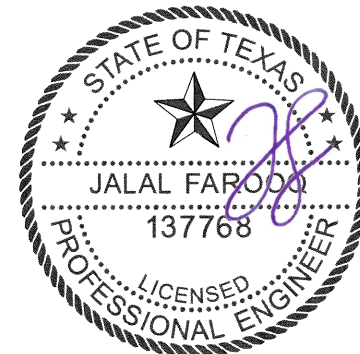

af c
AL-FAROOQ CORPORATION
 ENGINEERS & PRODUCT DEVELOPMENT
 9360 SUNSET DRIVE, SUITE 220 (C.A.N. 3538)
 MIAMI, FLORIDA 33173 FAX. (305) 262-6978
 TEL. (305) 264-8100

WALK-IN COOLER & FREEZER
Barcel USA LLC.
 301 Northpoint Drive, Suite 100
 Coppell, TX 75019
 Phone: (972) 591-2493 Fax: (214) 441-9757




revisions:	no	date	by	description

date: 11-20-20
 scale: 3/4" = 1'-0"
 dr. by: -
 chk. by:


drawing no.
20-95T
 sheet 28 of 47

COOLER\20-95T-BUS

 DETAIL BK

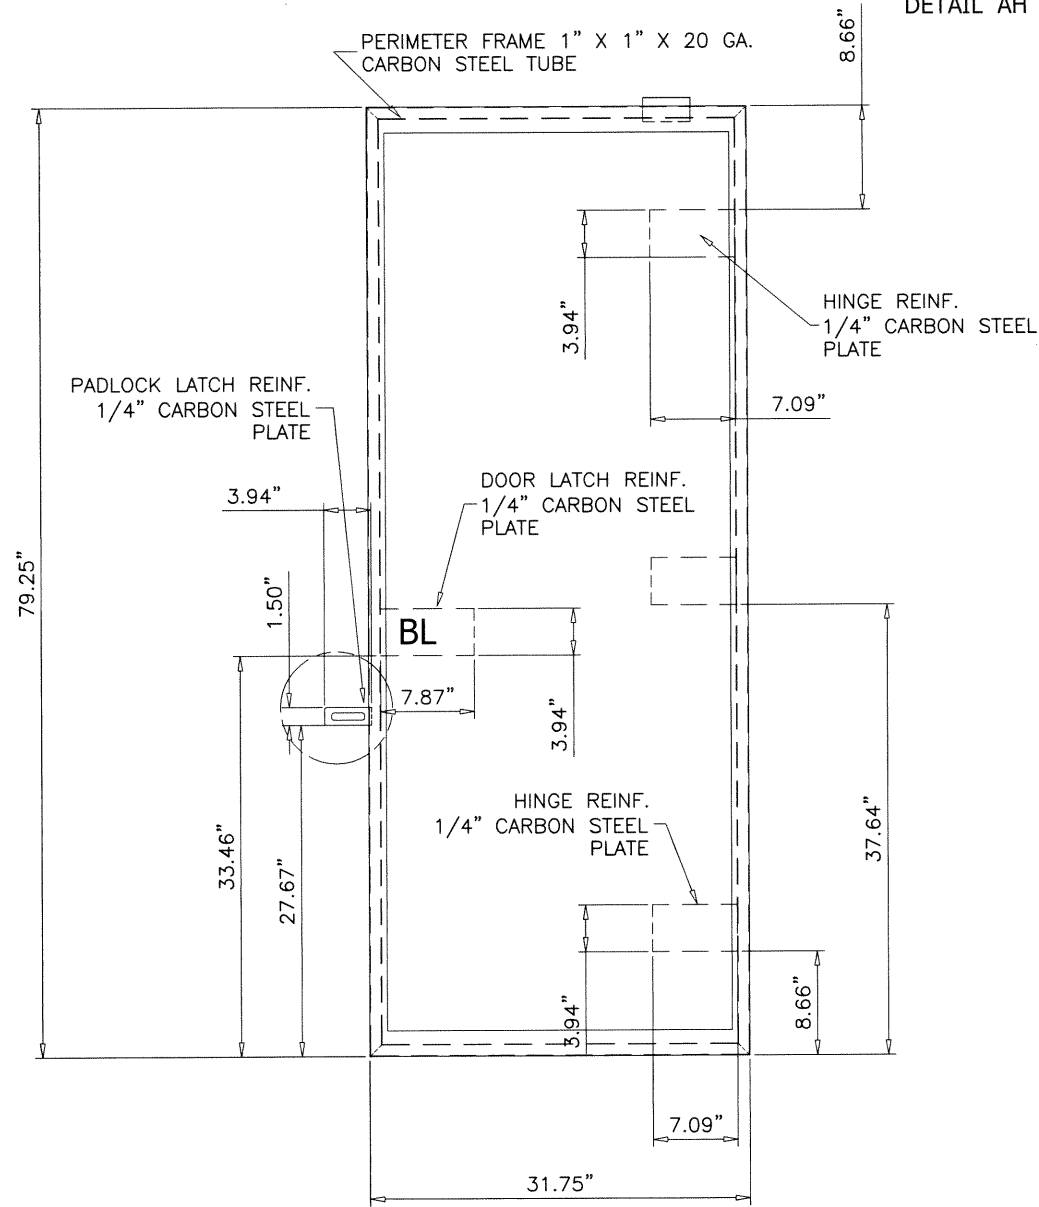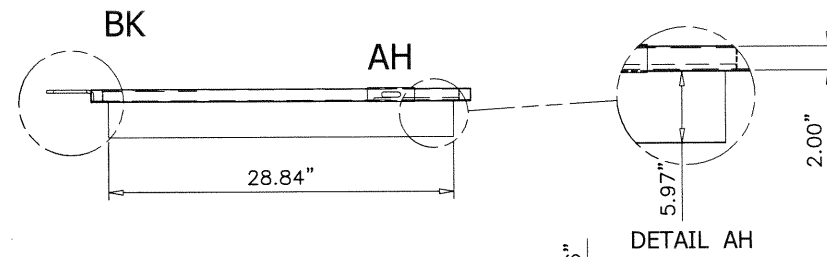

AG

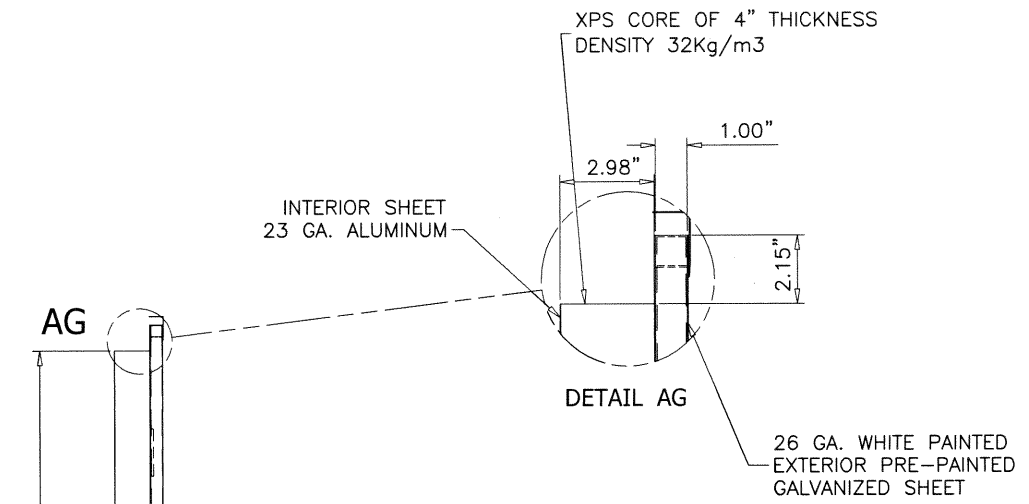



ALL REINFORCEMENTS ARE WELDED TO THE PERIMETER FRAME APPLY SEAM WELDING CONTINUOUSLY.

THE DOOR PERIMETER SHOULD BE COVERED AND RIVETED BY GALVANIZED SHEET MOLDING C-20


THE PADLOCK LATCH SHALL BE SEAM WELDED TO THE CARBON STEEL TUBE FRAME

1" X 1" X 18 GA. CARBON STEEL TUBE FOR DOOR'S PERIMETER FRAME

74.96"

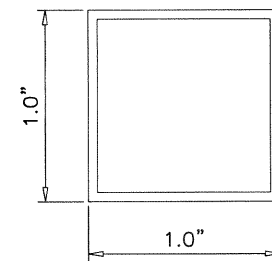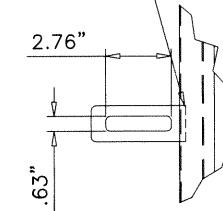

Sealed: 5/27/2021

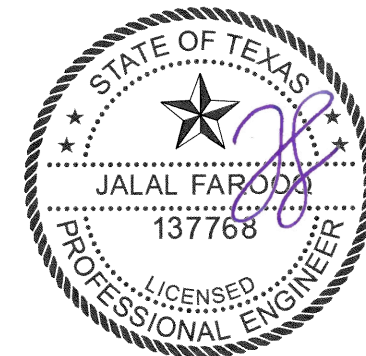

afc
AL-FAROOQ CORPORATION
 ENGINEERS & PRODUCT DEVELOPMENT
 9360 SUNSET DRIVE, SUITE 220 (C.A.N. 3538)
 MIAMI, FLORIDA 33173
 TEL. (305) 264-8100 FAX. (305) 262-6978
 COOLER\20-95T-BUS

WALK-IN COOLER & FREEZER
Barcel USA LLC.
 301 Northpoint Drive, Suite 100
 Coppell, TX 75019
 Phone: (972) 591-2493 Fax: (214) 441-9757


revisions:	
no	date by description

date: 11-20-20
 scale: 3/4" = 1'-0"
 dr. by: -
 chk. by: -


drawing no.
20-95T

sheet 29 of 47


PARTS LIST			
ITEM	QTY	PART NUMBER	DESCRIPTION
H2	1	INTERIOR DOOR SHEET	EMBOZED STUCCO ALUMINUM SHEET GAUGE 23

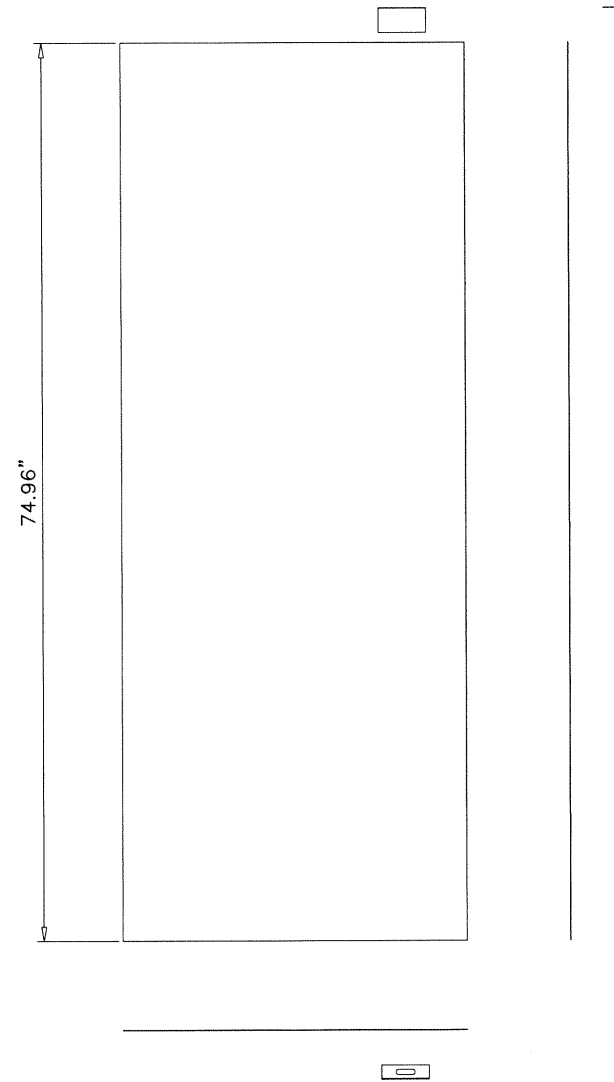

PARTS LIST			
ITEM	QTY	PART NUMBER	DESCRIPTION
H3	1	EXTERIOR DOOR SHEET	WHITE PAINTED GALVANIZED STEEL SHEET GAUGE 26 TERNIUM ZINTRO G60

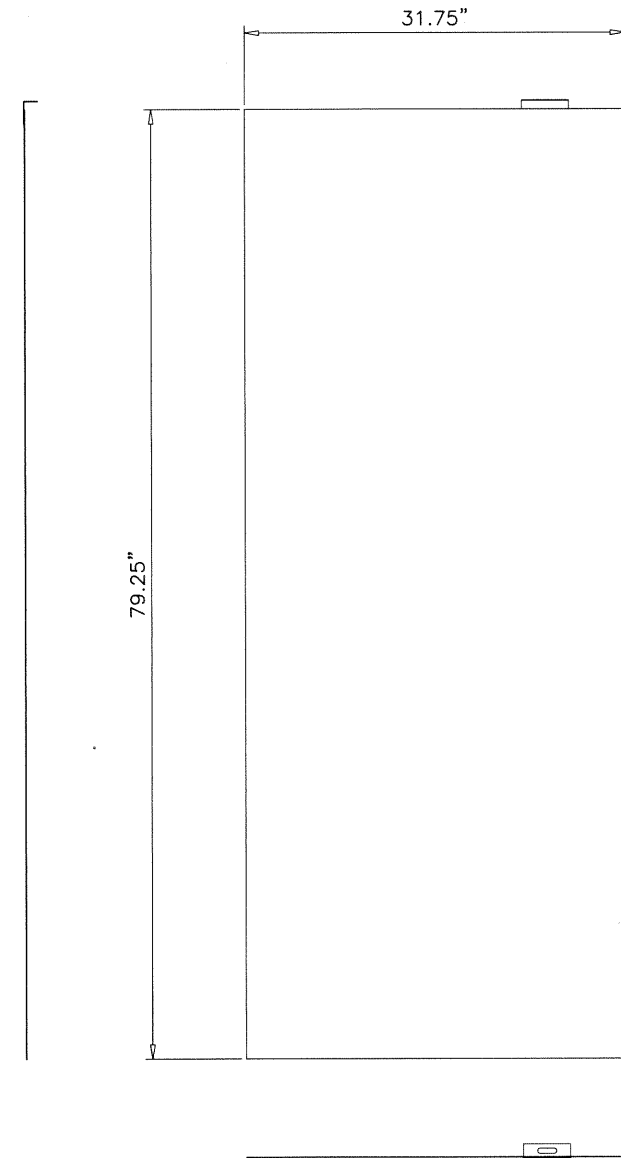

Sealed: 5/27/2021


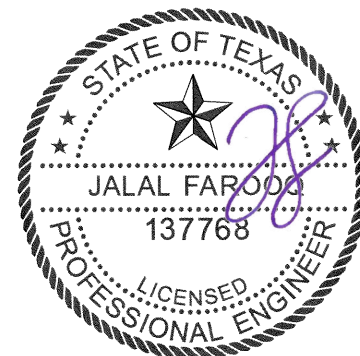


date: 11-20-20	scale: 3/4"=1'-0"	dr. by: -	chk. by:
drawing no. 20-95T			
sheet 30 of 47			





WALK-IN COOLER & FREEZER
Barcel USA LLC.
 301 Northpoint Drive, Suite 100
 Coppell, TX 75019
 Phone: (972) 591-2493 Fax: (214) 441-9757

AL-FAROOQ CORPORATION
 ENGINEERS & PRODUCT DEVELOPMENT
 9360 SUNSET DRIVE, SUITE 220
 MIAMI, FLORIDA 33173 (C.A.N. 3538)
 TEL. (305) 264-8100 FAX. (305) 262-6978
 COOLER\20-951-BUS

PARTS LIST			
ITEM	QTY	PART NUMBER	DESCRIPTION
H7	1	PADLOCK LATCH	1/4" CARBON STEEL PLATE

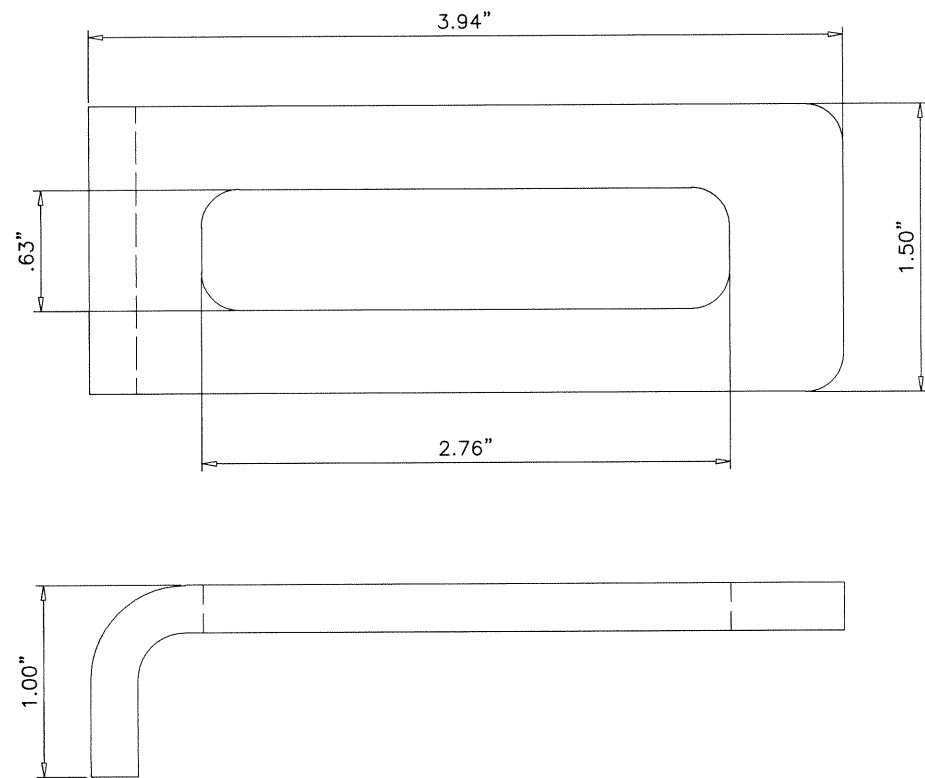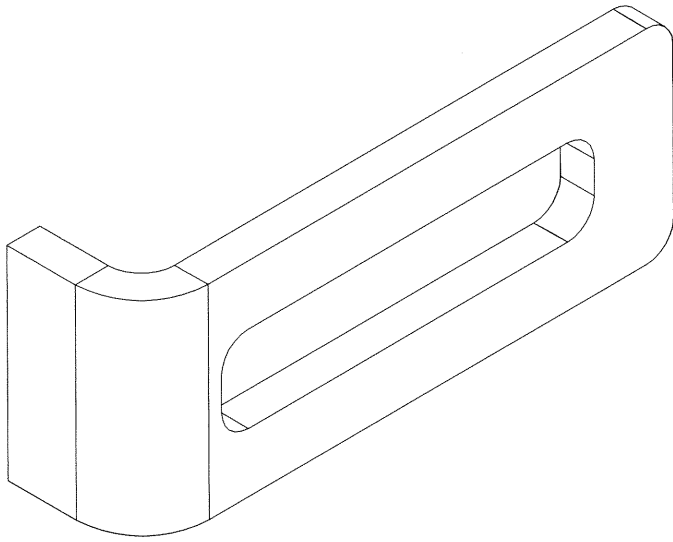

PARTS LIST			
ITEM	QTY	PART NUMBER	DESCRIPTION
H8	1	DOOR CLOSER LATCH	14 GA. GALV. STEEL SHEET

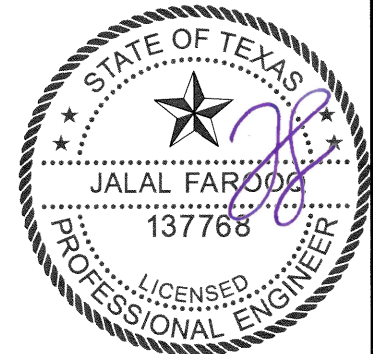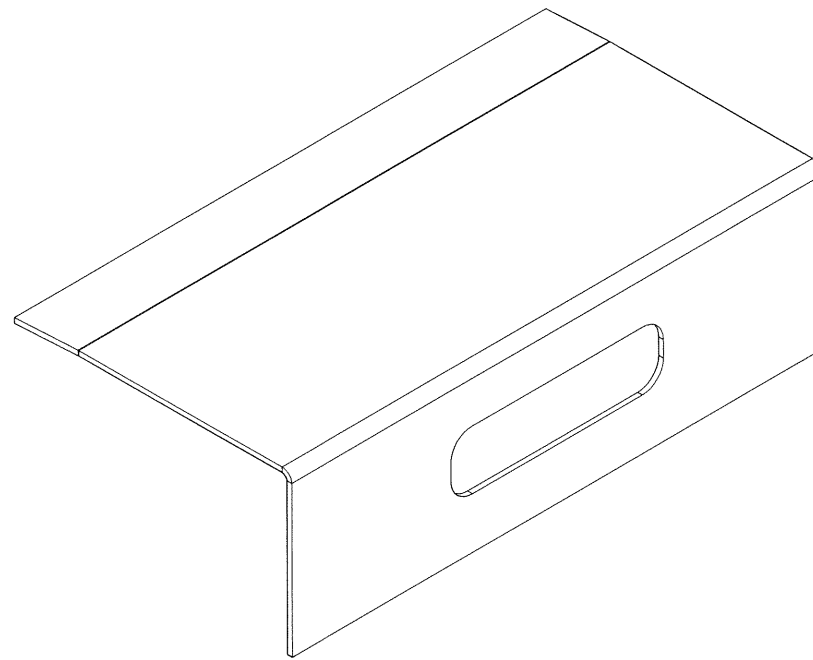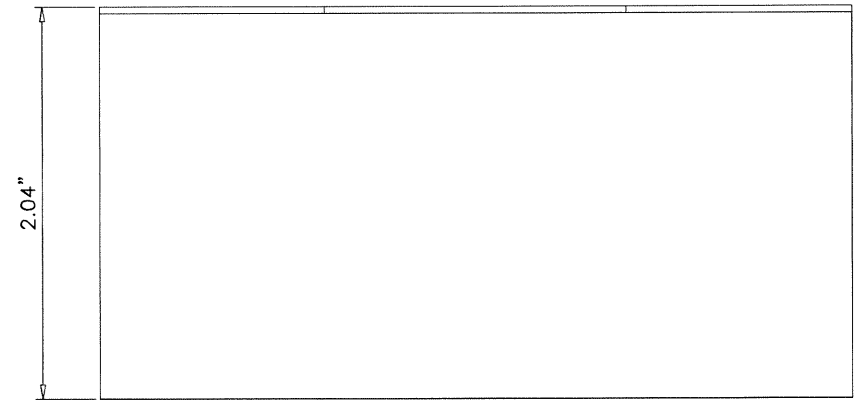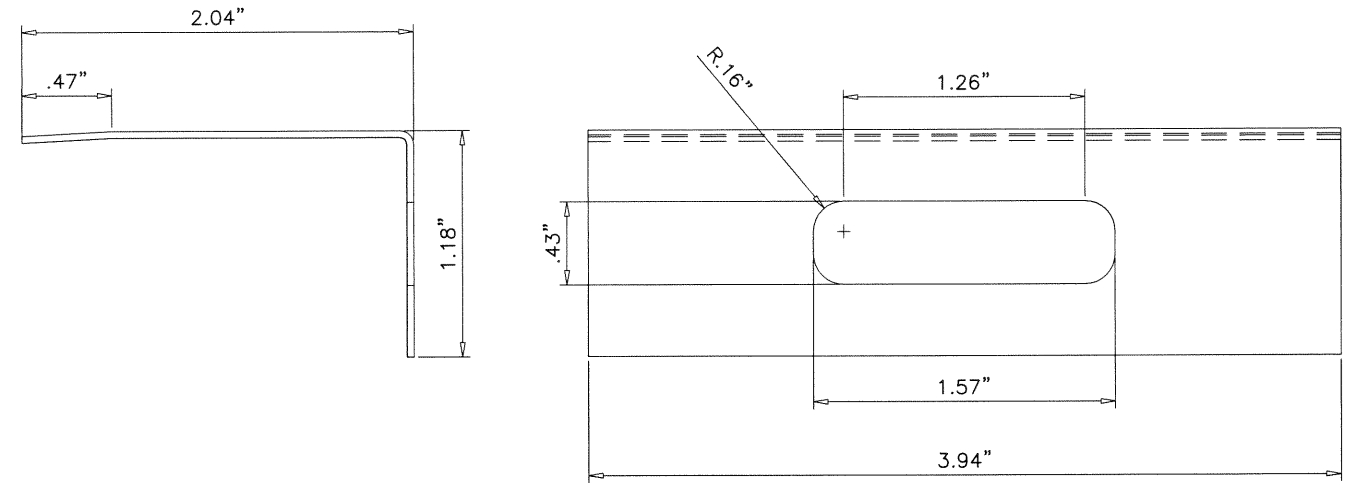



afc
AL-FAROOQ CORPORATION
 ENGINEERS & PRODUCT DEVELOPMENT
 9360 SUNSET DRIVE, SUITE 220 (C.A.N. 3538)
 MIAMI, FLORIDA 33173
 TEL. (305) 264-8100 FAX. (305) 262-6978
 COOLER\20-95T-BUS

WALK-IN COOLER & FREEZER
Barcel USA LLC.
 301 Northpoint Drive, Suite 100
 Coppell, TX 75019
 Phone: (972) 591-2493 Fax: (214) 441-9757

revisions:		date:	scale:	dr. by:	chk. by:
no	date	11-20-20	FULL	-	-
by	description				


drawing no. **20-95T**
 sheet **31** of **47**

PARTS LIST			
ITEM	QTY	PART NUMBER	DESCRIPTION
I1.1	6	REINFORCEMENT PLATE	3/8 X 3 " CARBON STEEL PLATE
I1.2	3	FLOOR SUPPORT	2X3" CARBON STEEL TUBE GAUGE 14

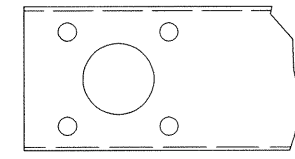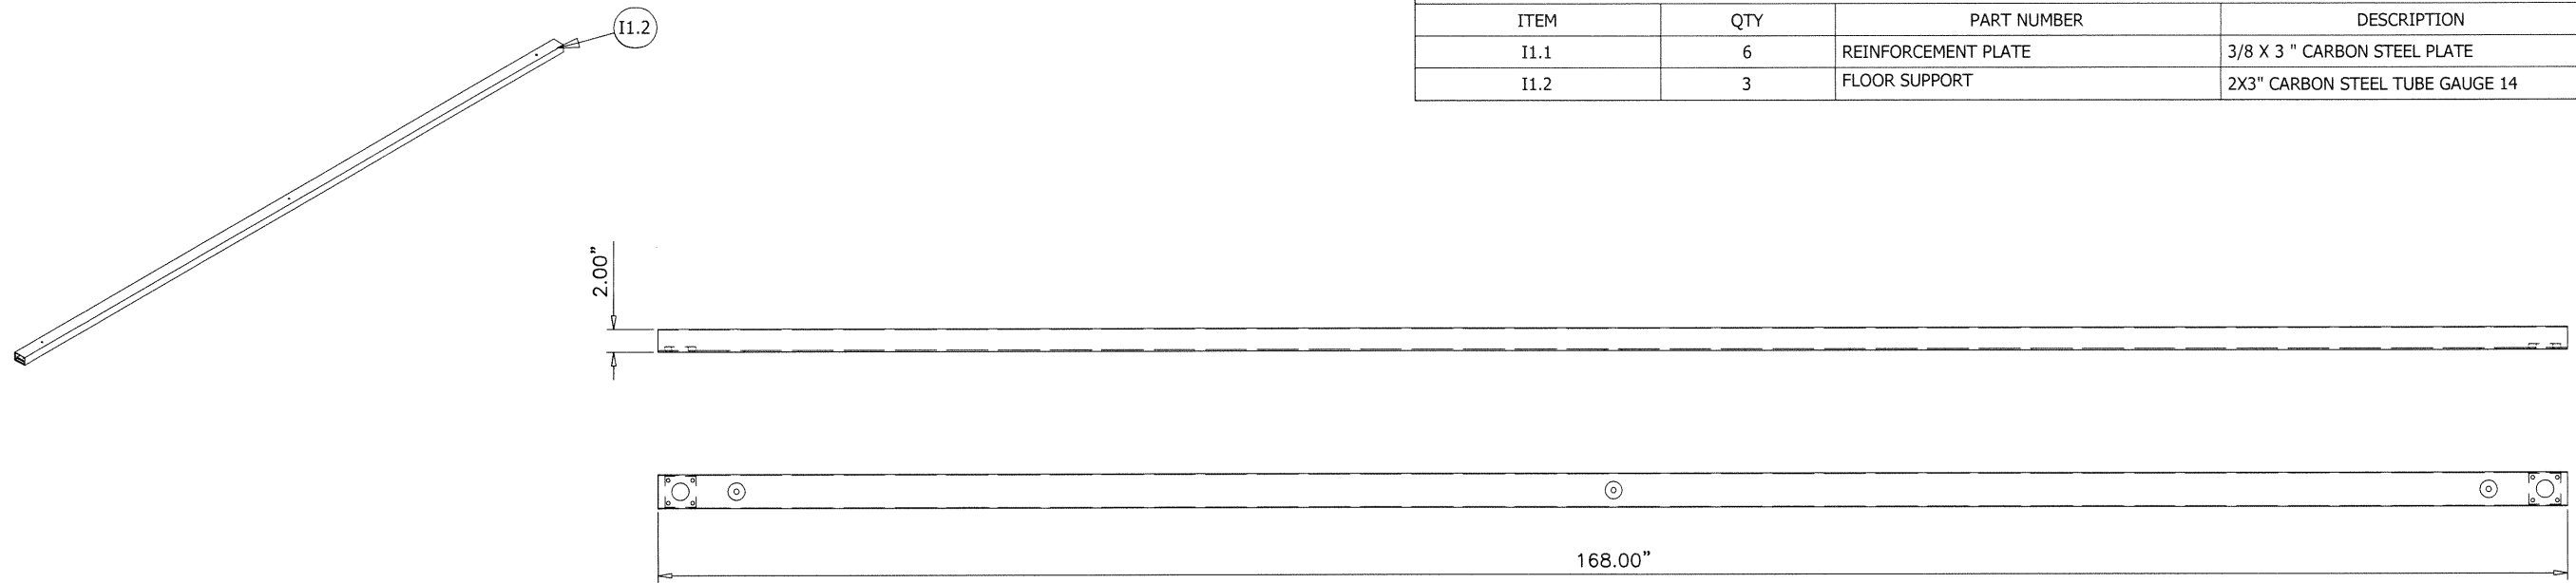


DETAIL HC

PARTS LIST			
ITEM	QTY	PART NUMBER	DESCRIPTION
1.1	3	FLOOR SUPPORT	2X3" CARBON STEEL TUBE GAUGE 14

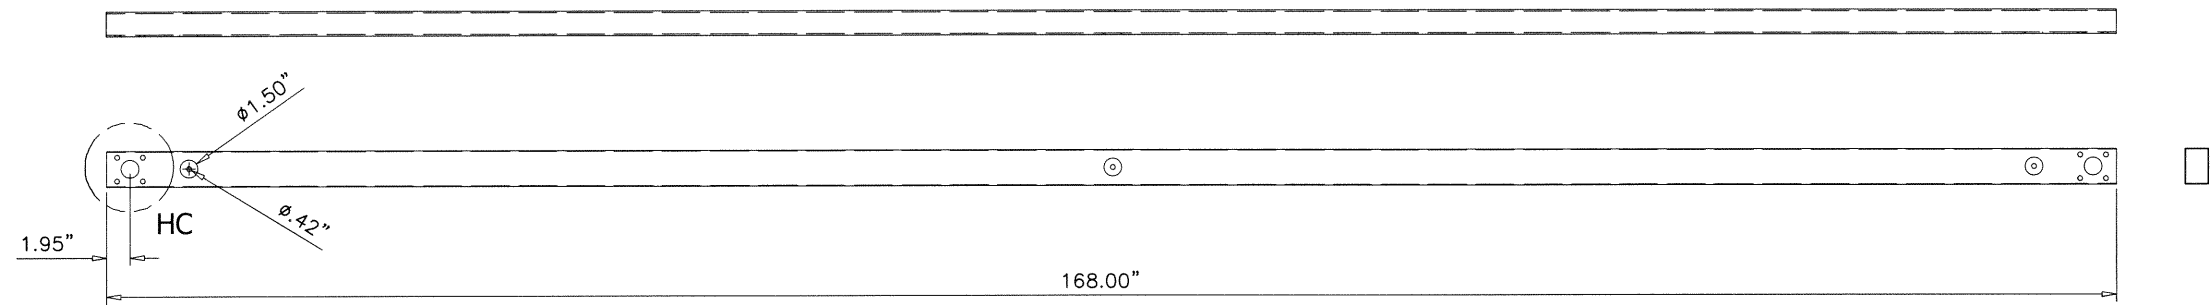

PARTS LIST			
ITEM	QTY	PART NUMBER	DESCRIPTION
1.2	6	REINFORCEMENT PLATE	3/8 X 3 " CARBON STEEL PLATE

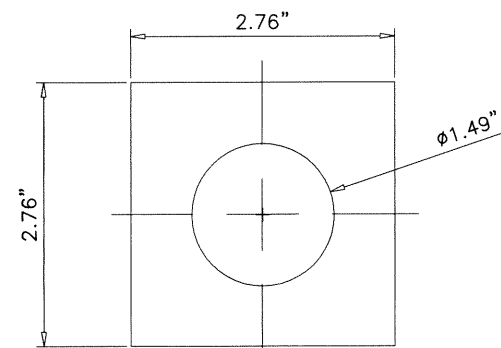

af c
AL-FAROOQ CORPORATION
 ENGINEERS & PRODUCT DEVELOPMENT
 9360 SUNSET DRIVE, SUITE 220 (C.A.N. 3538)
 MIAMI, FLORIDA 33173
 TEL. (305) 264-8100 FAX. (305) 262-6978

WALK-IN COOLER & FREEZER

Barcel USA LLC.
 301 Northpoint Drive, Suite 100
 Coppell, TX 75019
 Phone: (972) 591-2493 Fax: (214) 441-9757



revisions:	no	date	by	description

date: 11-20-20	scale: 3/4" = 1'-0"	dr. by: -	chk. by:
drawing no. 20-95T			
sheet 32 of 47			

COOLER\20-95T-BUS

PARTS LIST			
ITEM	QTY	PART NUMBER	DESCRIPTION
J	8	LARGE HORIZONTAL CORNER	18 GA. GALV. STEEL SHEET

NOTE:
CONSIDER 4 PIECES FOR THE LEFT SIDE
AND 4 PIECES FOR THE RIGHT SIDE

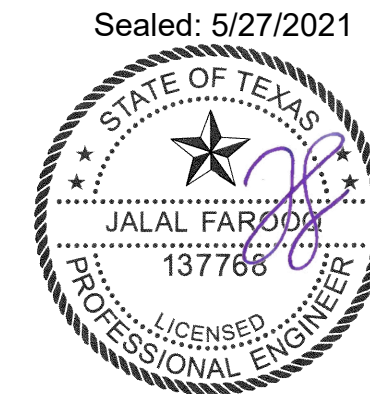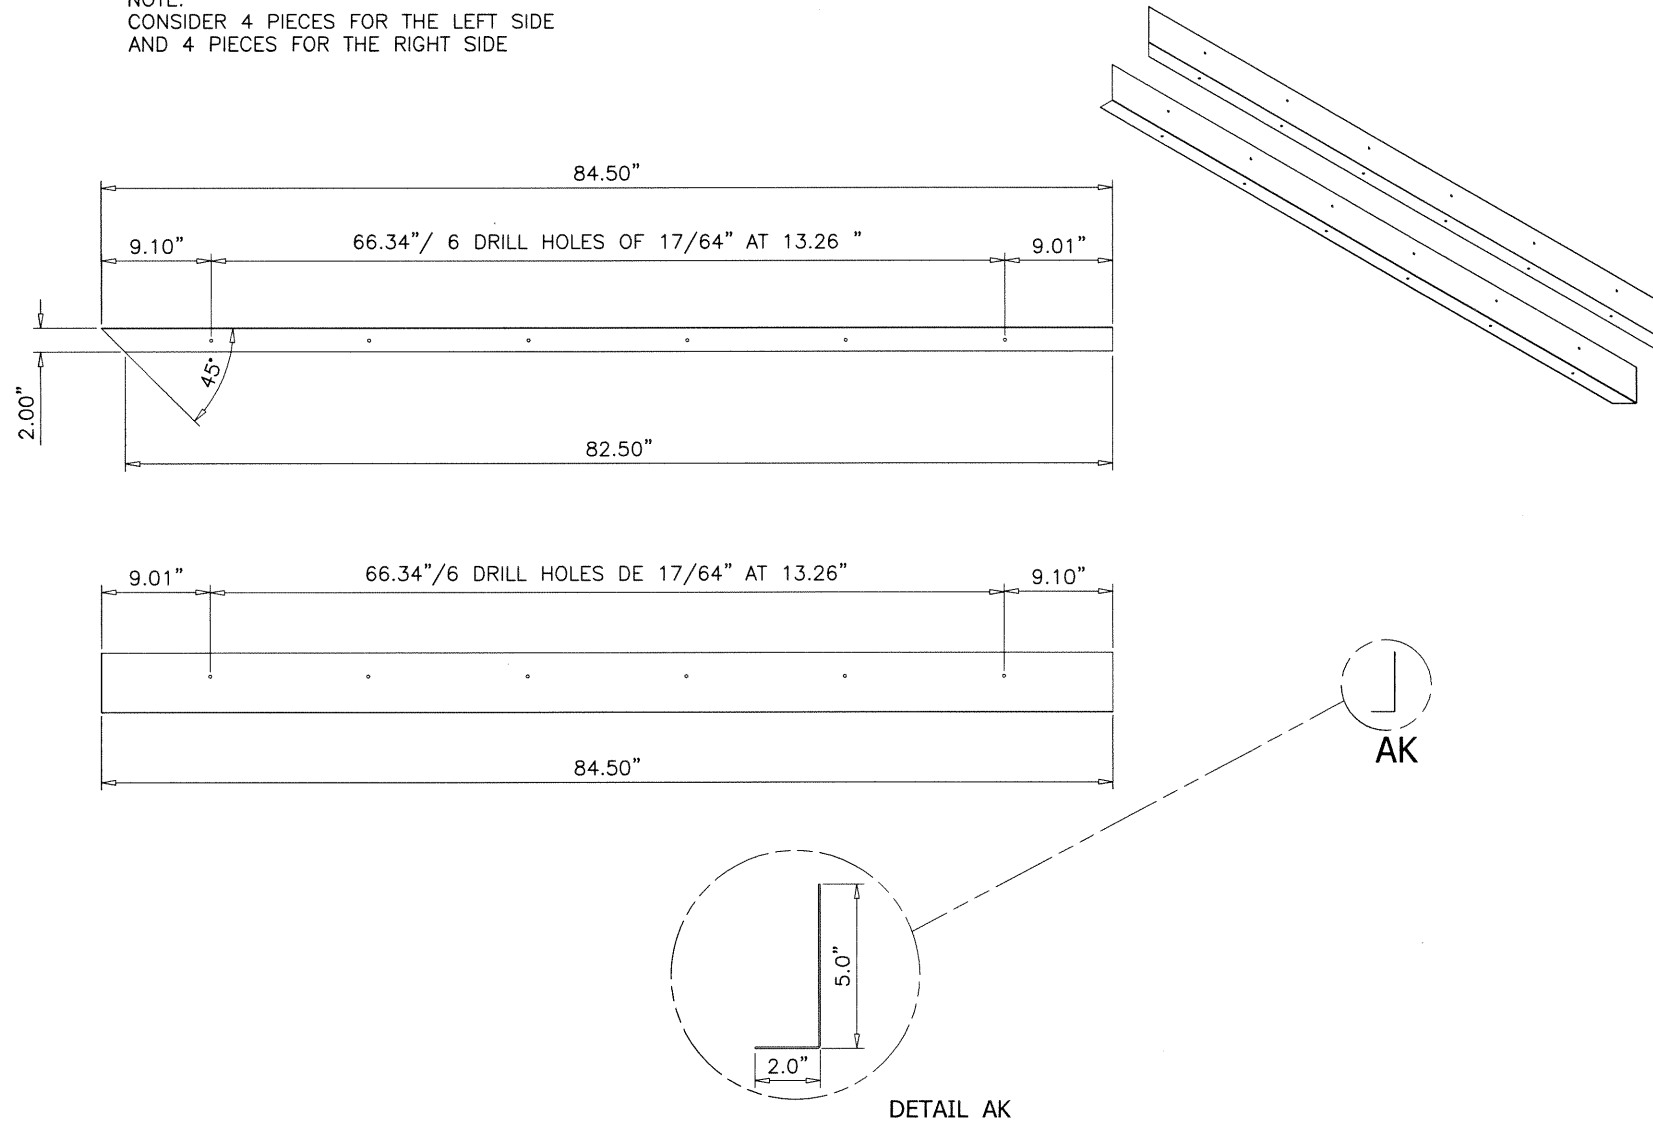




afc
AL-FAROOQ CORPORATION
 ENGINEERS & PRODUCT DEVELOPMENT
 9360 SUNSET DRIVE, SUITE 220 (C.A.N. 3538)
 MIAMI, FLORIDA 33173
 TEL. (305) 264-8100 FAX. (305) 262-6978
 COOLER\20-95T-BUS

WALK-IN COOLER & FREEZER
Barcel USA LLC.
 301 Northpoint Drive, Suite 100
 Coppell, TX 75019
 Phone: (972) 591-2493 Fax: (214) 441-9757

revisions:	no.	date	by	description

date: 11-20-20
 scale: 3/4"=1'-0"
 dr. by: -
 chk. by: -
 drawing no.
20-95T
 sheet **33** of **47**

PARTS LIST			
ITEM	QTY	PART NUMBER	DESCRIPTION
K	3	SHORT HORIZONTAL CORNER	18 GA. GALV. STEEL SHEET

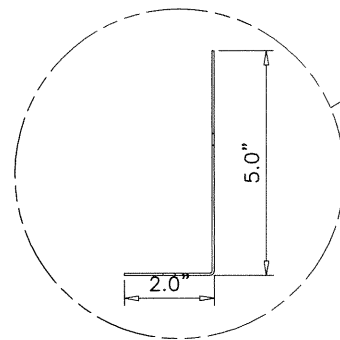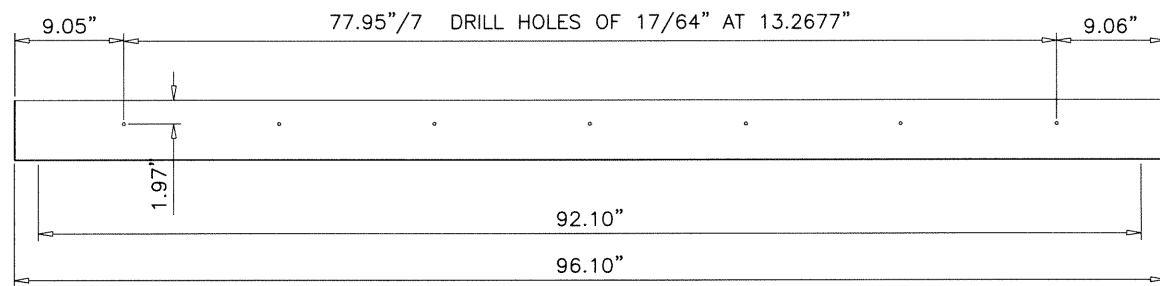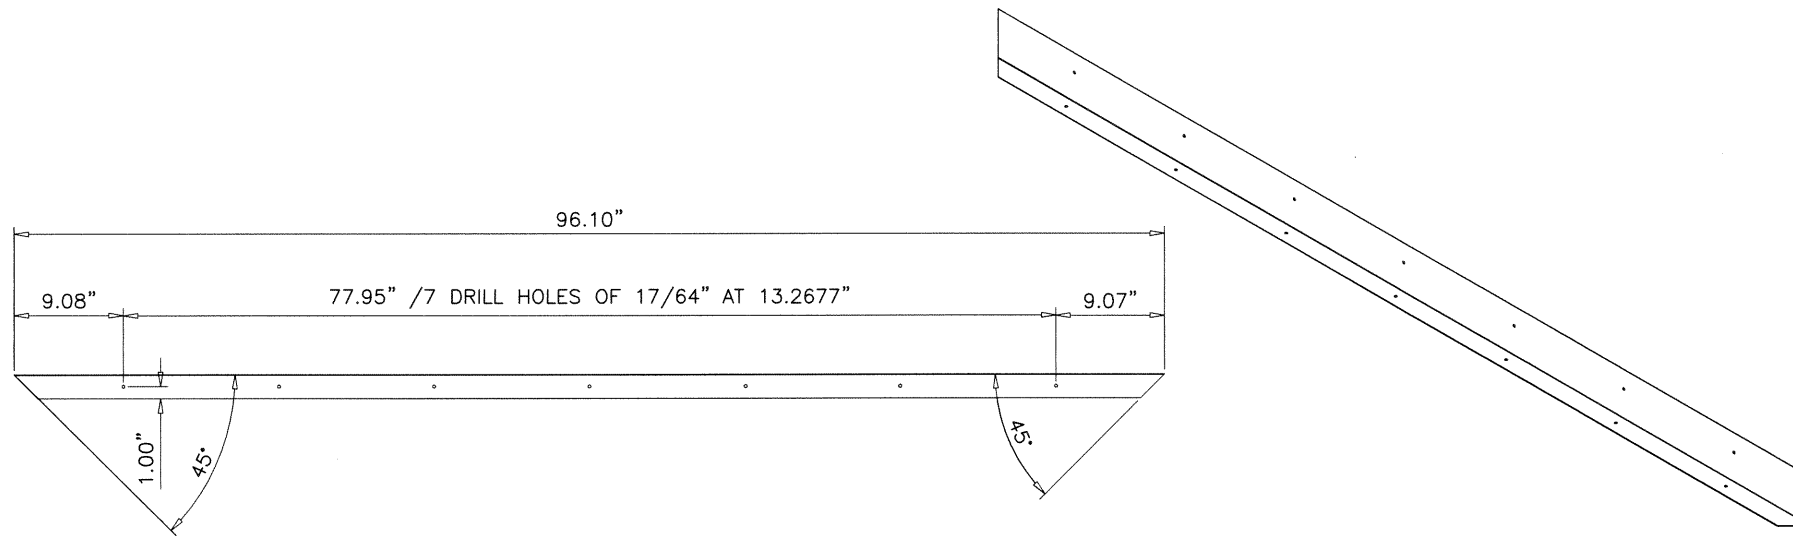

afc
AL-FAROOQ CORPORATION
 ENGINEERS & PRODUCT DEVELOPMENT
 9360 SUNSET DRIVE, SUITE 220 (C.A.N. 3538)
 MIAMI, FLORIDA 33173
 TEL. (305) 264-8100 FAX. (305) 262-6978




WALK-IN COOLER & FREEZER
Barcel USA LLC.
 301 Northpoint Drive, Suite 100
 Coppell, TX 75019
 Phone: (972) 591-2493 Fax: (214) 441-9757

no	date	by	description

date: 11-20-20
 scale: 3/4"=1'-0"
 dr. by: -
 chk. by: -


drawing no.
20-95T
 sheet 34 of 47

COOLER\20-95T-BUS

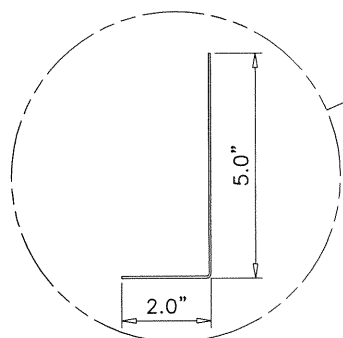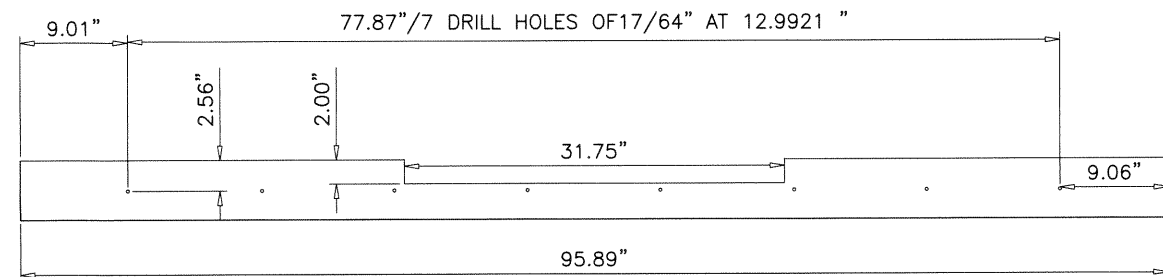
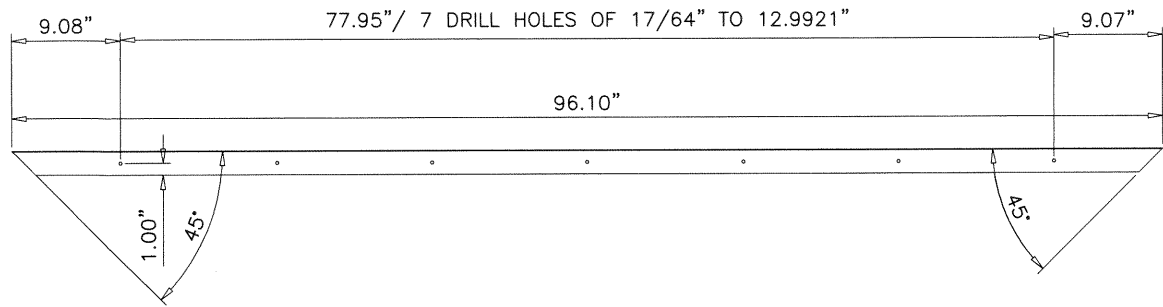


DETAIL BC

PARTS LIST			
ITEM	QTY	PART NUMBER	DESCRIPTION
L	1		DOOR LOWER CORNER
			18 GA. GALV. STEEL SHEET

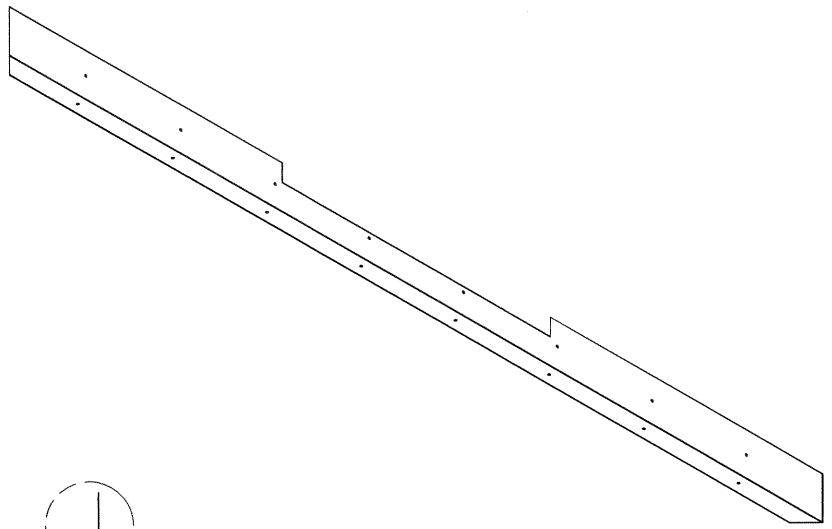


BC

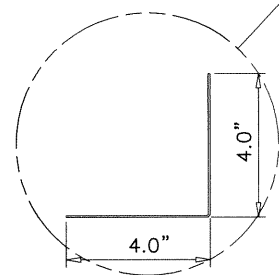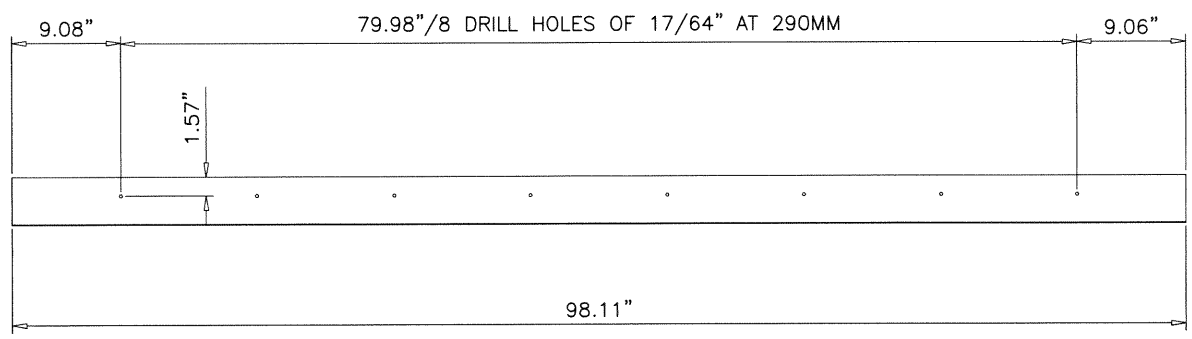


DETAIL AM

PARTS LIST			
ITEM	QTY	PART NUMBER	DESCRIPTION
M	4		VERTICAL CORNER
			18 GA. GALV. STEEL SHEET

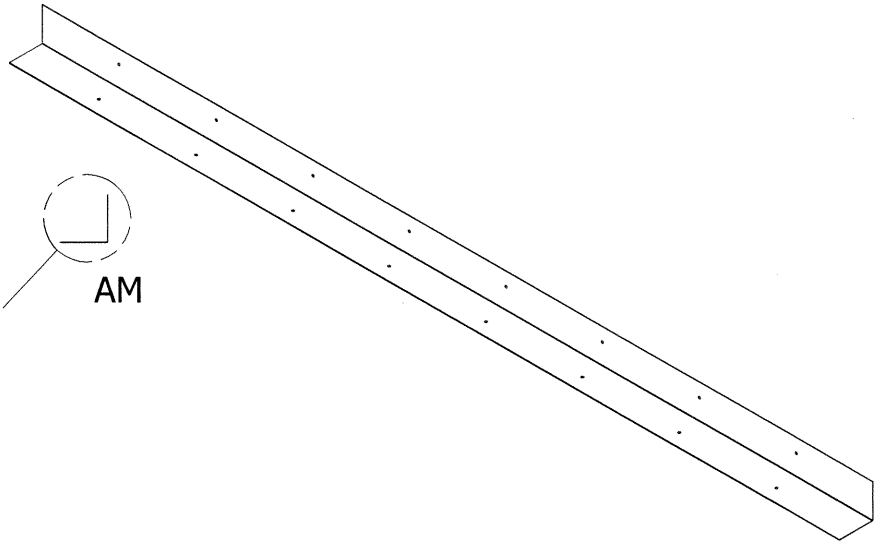

AM

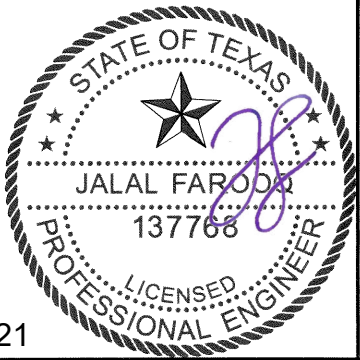

Sealed: 5/27/2021



af c
AL-FAROOQ CORPORATION
 ENGINEERS & PRODUCT DEVELOPMENT
 9360 SUNSET DRIVE, SUITE 220
 MIAMI, FLORIDA 33173 (C.A.N. 3538)
 TEL. (305) 264-8100 FAX. (305) 262-6978

WALK-IN COOLER & FREEZER
Barcel USA LLC.
 301 Northpoint Drive, Suite 100
 Coppell, TX 75019
 Phone: (972) 591-2493 Fax: (214) 441-9757

revisions:	no	date	by	description
date:	11-20-20			
scale:	3/4" = 1'-0"			
dr. by:				
chk. by:				
drawing no.	20-95T			
sheet	35 of 47			

COOLER\20-95T-BUS

PARTS LIST			
ITEM	QTY	PART NUMBER	DESCRIPTION
N	2	HINGES	KASON REVERSIBLE CAM-RISE HINGES 1245

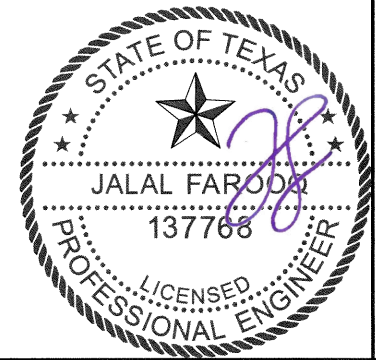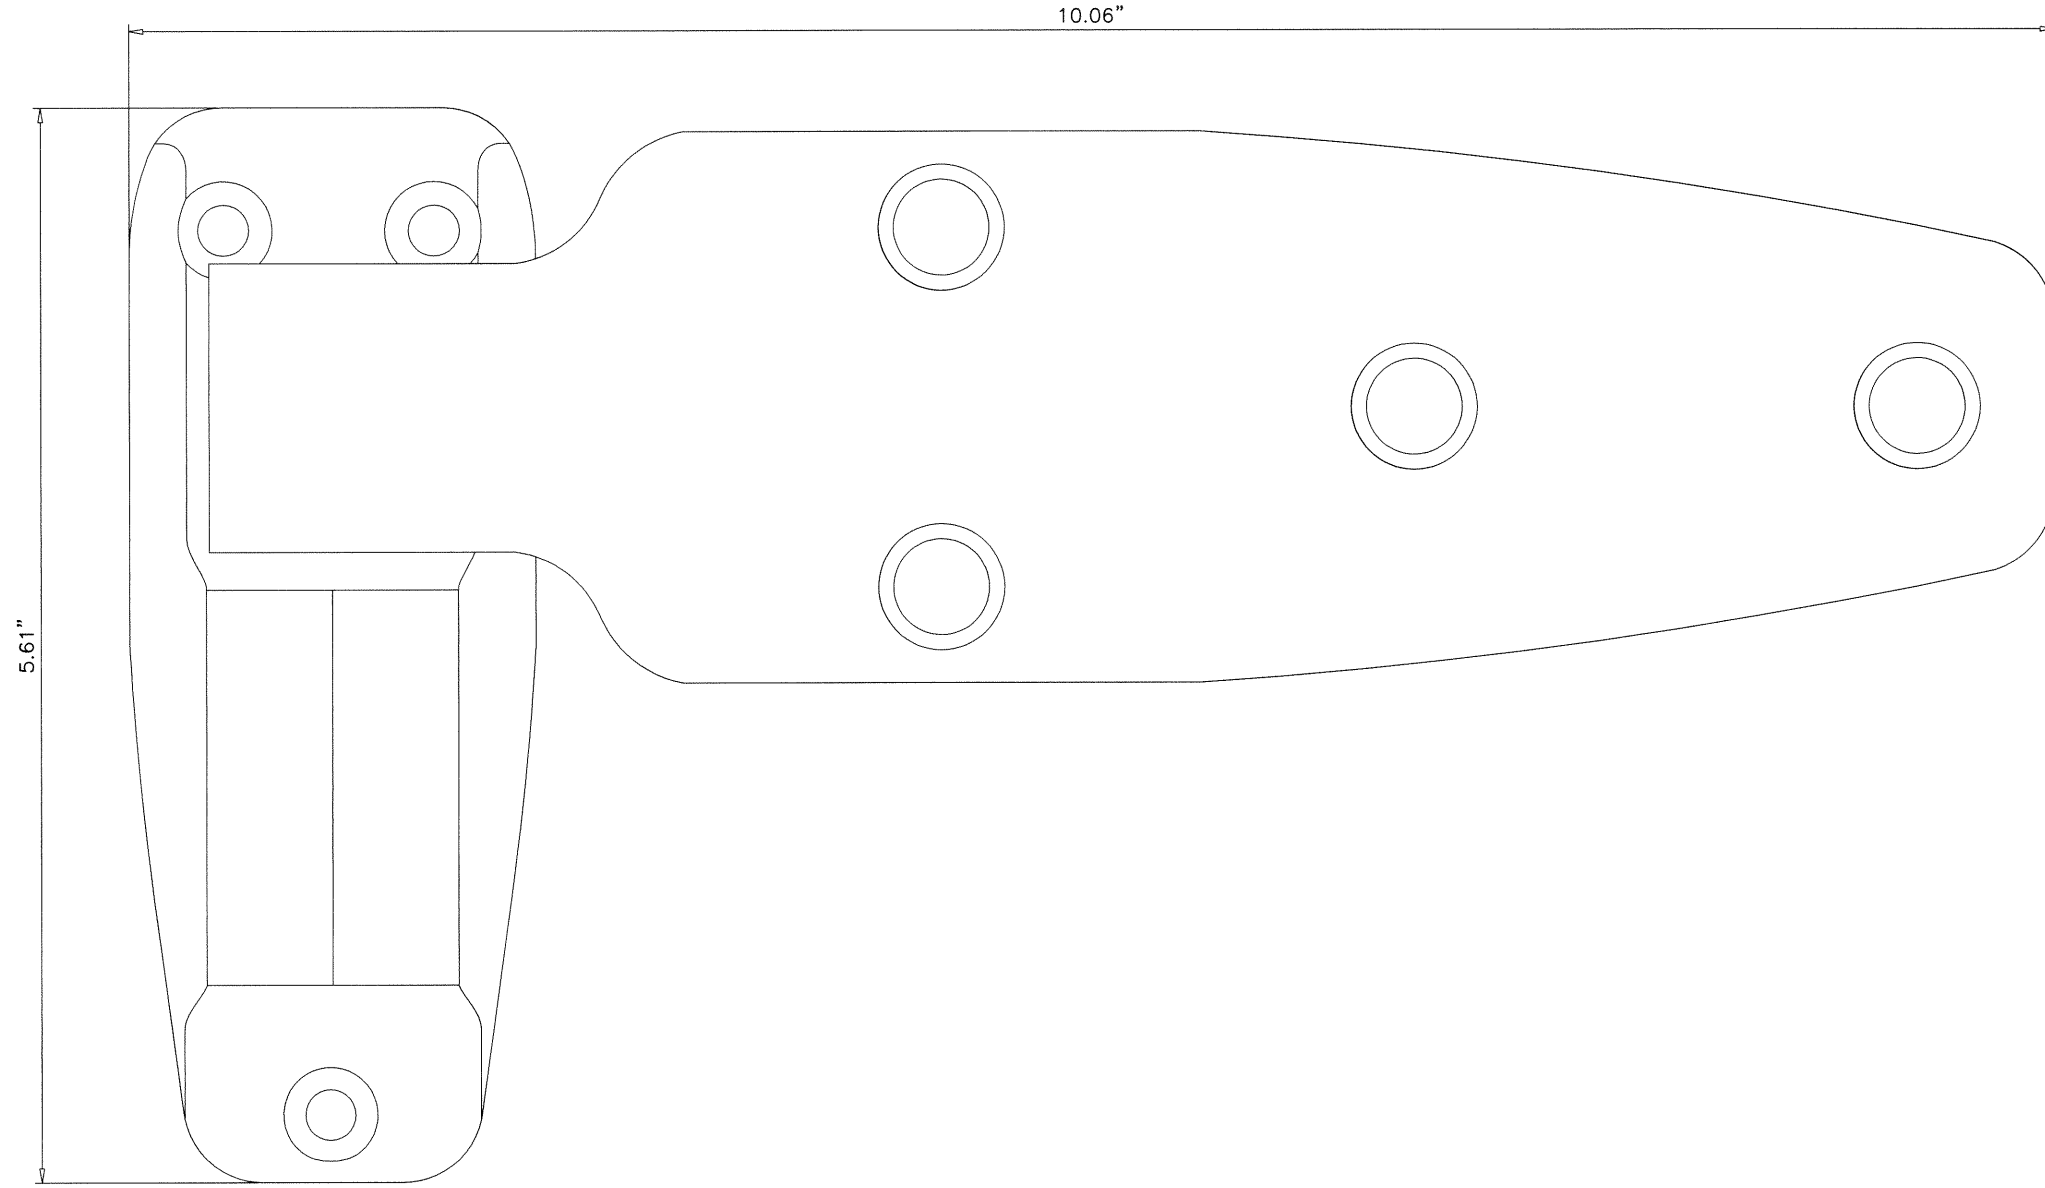

Sealed: 5/27/2021

date: 11-20-20	scale: FULL	dr. by: -	chk. by:
----------------	-------------	-----------	----------

drawing no.
20-95T

sheet **36** of **47**

no.	date	by	description


WALK-IN COOLER & FREEZER
Barcel USA LLC.
 301 Northpoint Drive, Suite 100
 Coppell, TX 75019
 Phone: (972) 591-2493 Fax: (214) 441-9757

AL-FAROOQ CORPORATION
 ENGINEERS & PRODUCT DEVELOPMENT
 9360 SUNSET DRIVE, SUITE 220
 MIAMI, FLORIDA 33173 (C.A.N. 3538)
 TEL. (305) 264-8100 FAX. (305) 262-6978


afc

COOLER\20-95T-BUS

PARTS LIST			
ITEM	QTY	PART NUMBER	DESCRIPTION
S	4	KICK PLATES	14 GA. GALV. STEEL SHEET

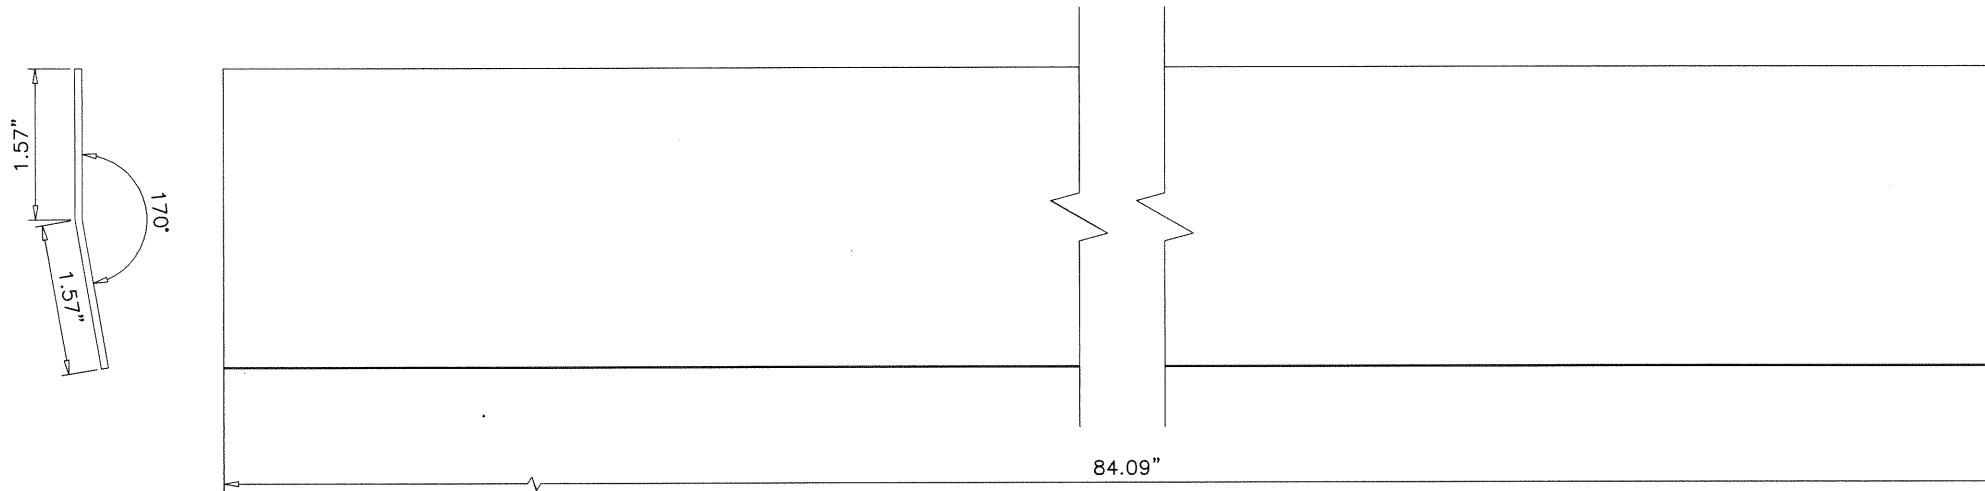

PARTS LIST			
ITEM	QTY	PART NUMBER	DESCRIPTION
T	2	LOWER SUPPORT	14 GA. GALV. STEEL SHEET

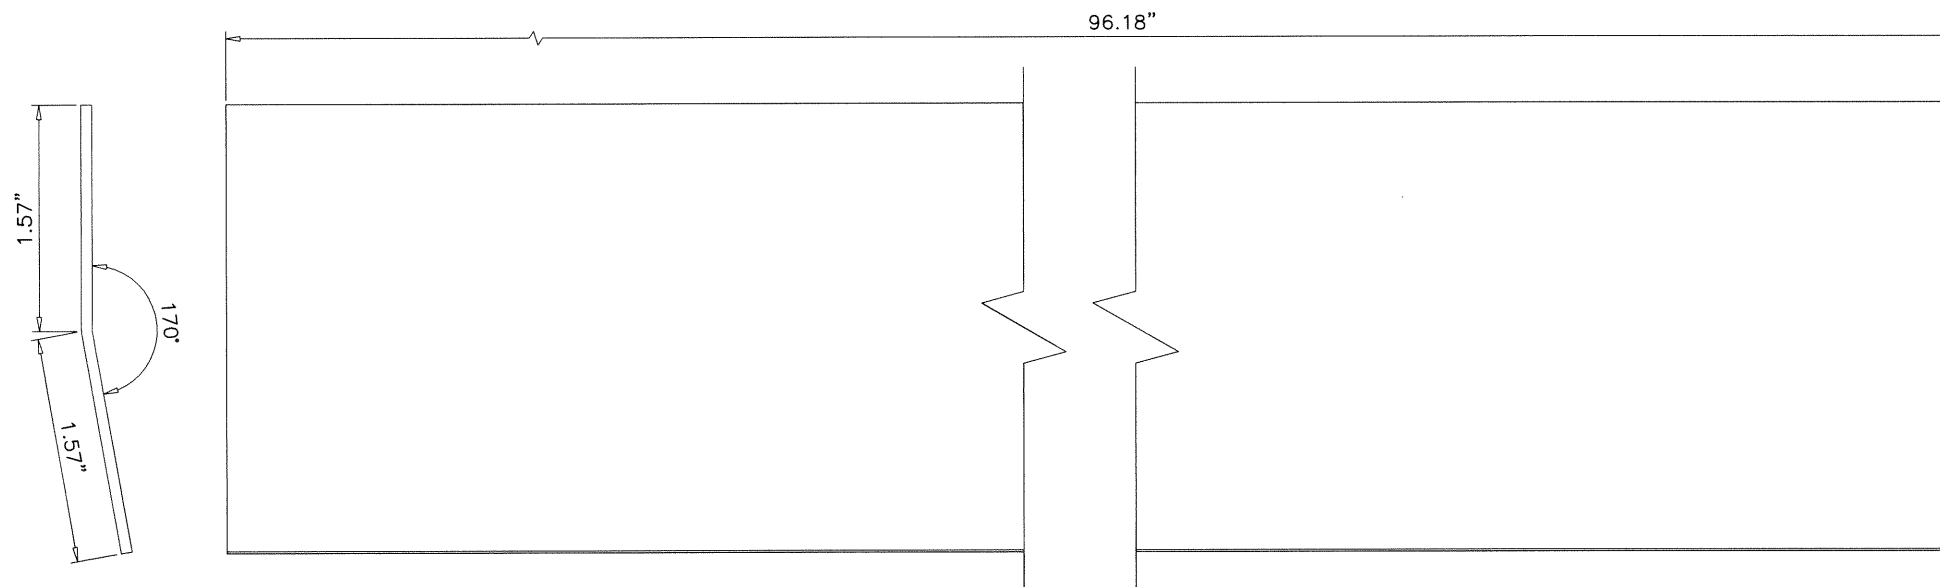

afc
AL-FAROOQ CORPORATION
 ENGINEERS & PRODUCT DEVELOPMENT
 9360 SUNSET DRIVE, SUITE 220 (C.A.N. 3538)
 MIAMI, FLORIDA 33173 FAX. (305) 262-6978
 TEL. (305) 264-8100





WALK-IN COOLER & FREEZER
Barcel USA LLC.
 301 Northpoint Drive, Suite 100
 Coppell, TX 75019
 Phone: (972) 591-2493 Fax: (214) 441-9757

revisions:	no.	date	by	description

date: 11-20-20	scale: -	dr. by: -	chk. by: -
----------------	----------	-----------	------------

drawing no.
20-95T
 sheet **38** of **47**




COOLER\20-95T-BUS

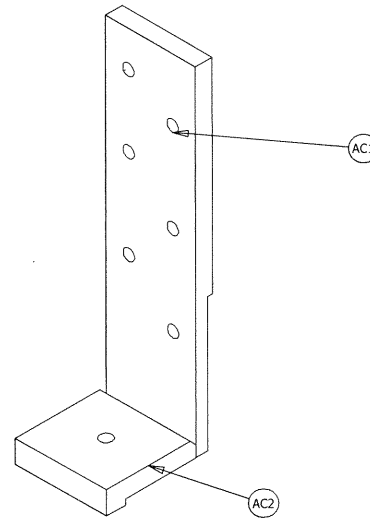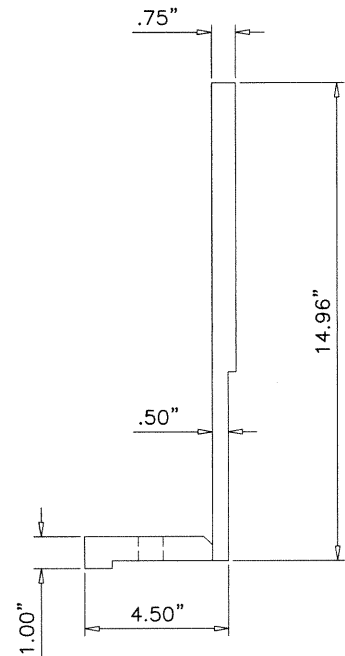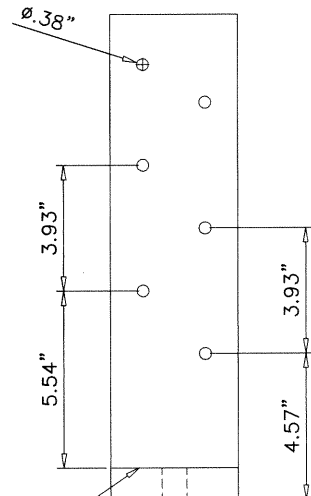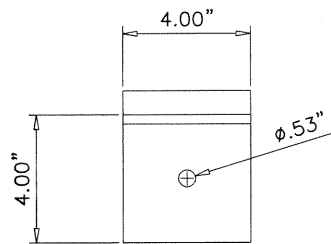

PARTS LIST			
ITEM	QTY	PART NUMBER	DESCRIPTION
AC1	12	ANCHOR SUBASSEMBLY A	3/4" A36 CARBON STEEL PLATE
AC2	12	ANCHOR SUBASSEMBLY B	1" A36 CARBON STEEL PLATE
AC3	12	MATERIAL	1/2" HILTI KWIK BLOT 3 CARBON STEEL ANCHOR WITH 3-12" MIN. EMBED.,
AC4	72	MATERIAL	5/16" (SAE GR.5). SCREW
AC5	72	MATERIAL	5/16" FLAT WASHER
AC6	72	MATERIAL	5/16" LOCK WASHER
AC7	12	MATERIAL	1/2" FLAT WASHER
AC8	12	MATERIAL	1/2" LOCK WASHER

APPLY HIGH RESISTANCE CONTINUOUS WELDING

PARTS LIST			
ITEM	QTY	PART NUMBER	DESCRIPTION
AD	8	CORNER	18 GA. GALV. STEEL SHEET

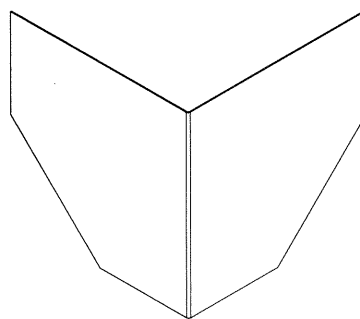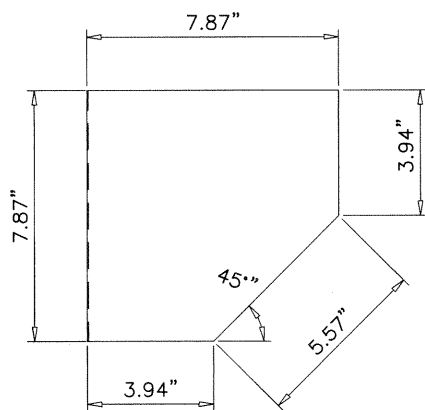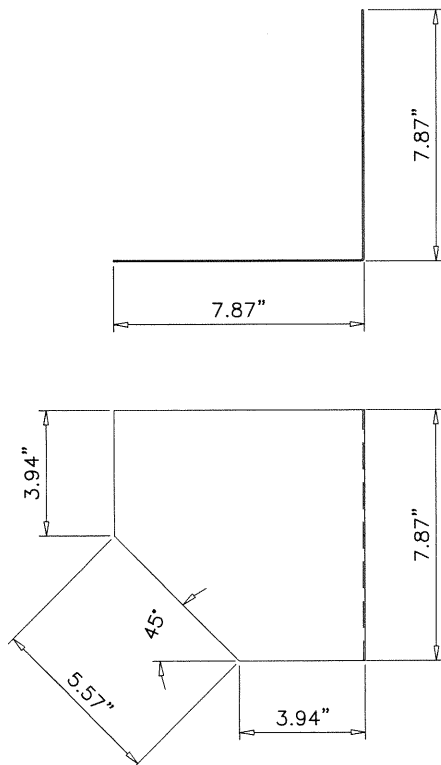

AL-FAROOQ CORPORATION
 ENGINEERS & PRODUCT DEVELOPMENT
 9360 SUNSET DRIVE, SUITE 220
 MIAMI, FLORIDA 33173 (C.A.N. 3538)
 TEL. (305) 264-8100 FAX. (305) 262-6978

WALK-IN COOLER & FREEZER

Barcel USA LLC.

301 Northpoint Drive, Suite 100
 Coppell, TX 75019

Phone: (972) 591-2493 Fax: (214) 441-9757

revisions:
 no. date by description

date: 11-20-20
 scale: 1" = 6"

dr. by: -
 chk. by:

drawing no.
 20-95T








sheet 39 of 47




Sealed: 5/27/2021

COOLER/20-95T-BUS

PARTS LIST			
ITEM	QTY	PART NUMBER	DESCRIPTION
AN1.1	2	FRONTAL ANGLES FOR ANCHORS	GALVANIZED STEEL SHEET GAUGE 10
AN1.2	6	OMEGA FITTING A	GALVANIZED STEEL SHEET GAUGE 14

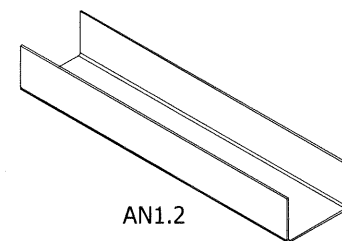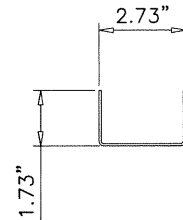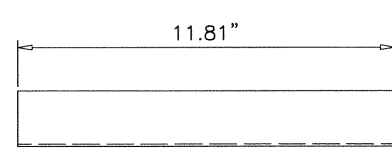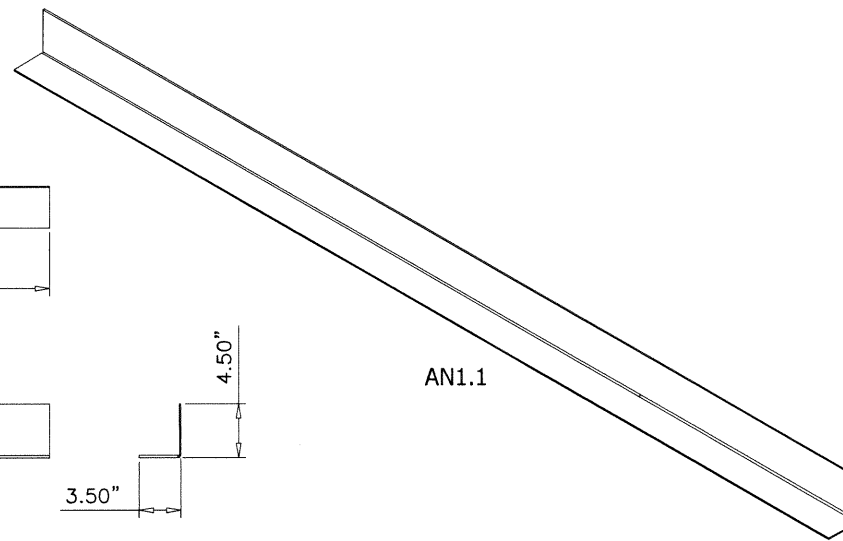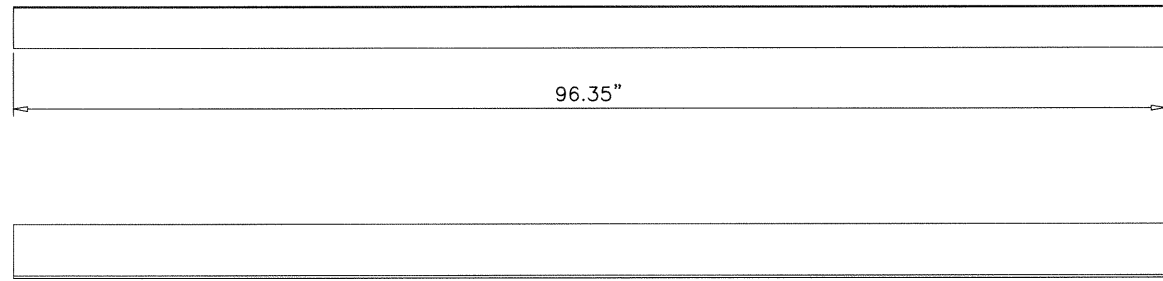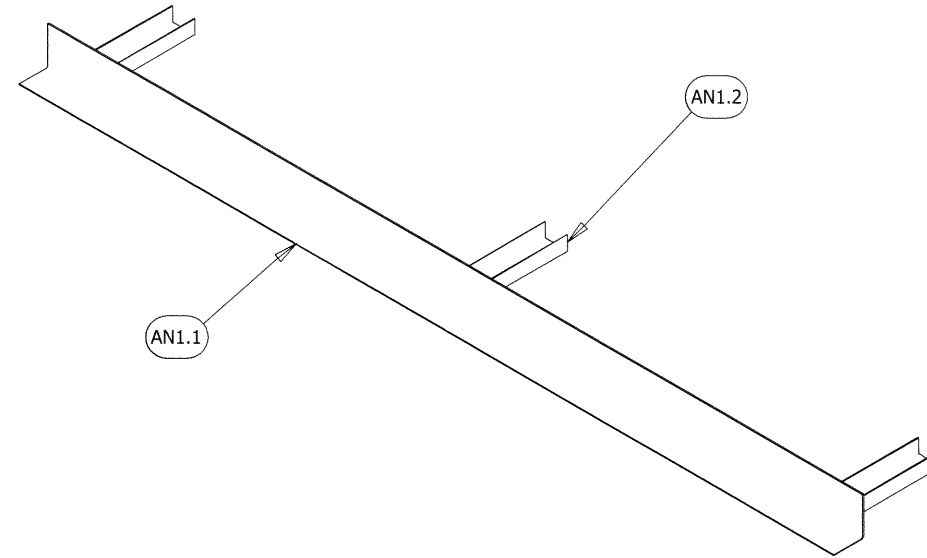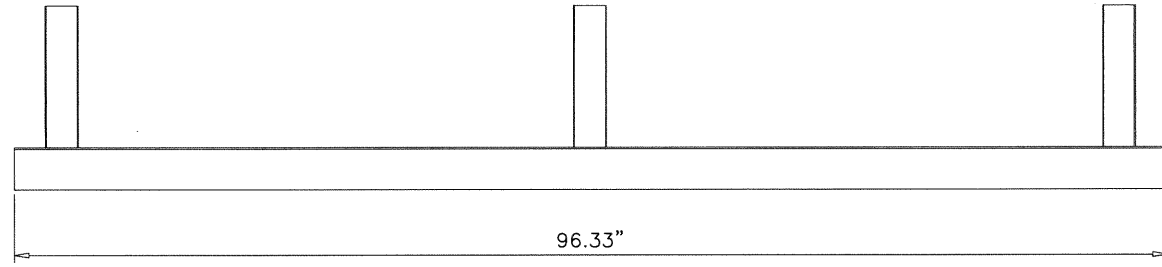

Sealed: 5/27/2021

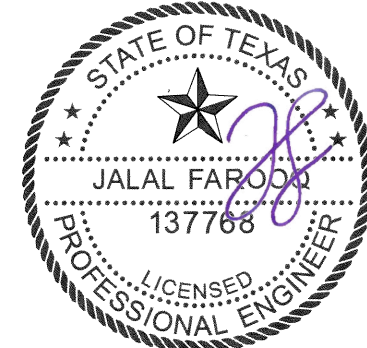


af c
AL-FAROOQ CORPORATION
 ENGINEERS & PRODUCT DEVELOPMENT
 9360 SUNSET DRIVE, SUITE 220
 MIAMI, FLORIDA 33173 (C.A.N. 3588)
 TEL. (305) 264-8100 FAX. (305) 262-6978
 COOLER\20-95T-BUS

WALK-IN COOLER & FREEZER
Barcel USA LLC.
 301 Northpoint Drive, Suite 100
 Coppell, TX 75019
 Phone: (972) 591-2493 Fax: (214) 441-9757




revisions:	no	date	by	description

date: 11-20-20
 scale: 1" = 6"
 dr. by: -
 chk. by:
 drawing no.
20-95T
 sheet 39.1 of 47

PARTS LIST			
ITEM	QTY	PART NUMBER	DESCRIPTION
AF	6	HINGE LEVELER	GALVANIZED SHEET CAL-10

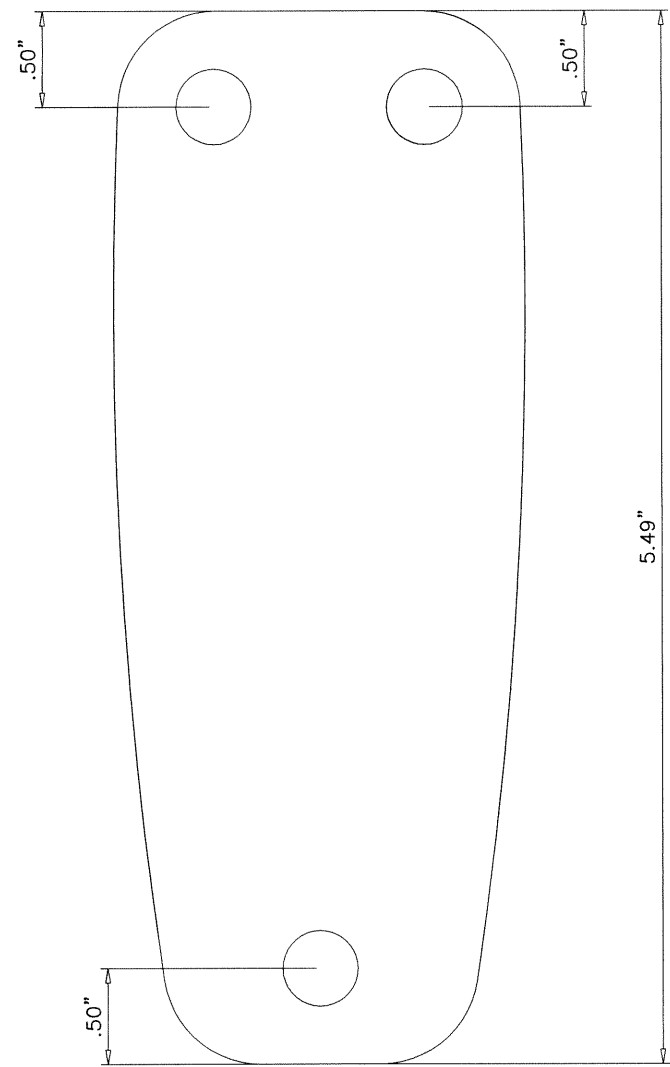

PARTS LIST			
ITEM	QTY	PART NUMBER	DESCRIPTION
AK	1	DOOR THRESHOLD	40"X4" MOLDED ALUMINUM

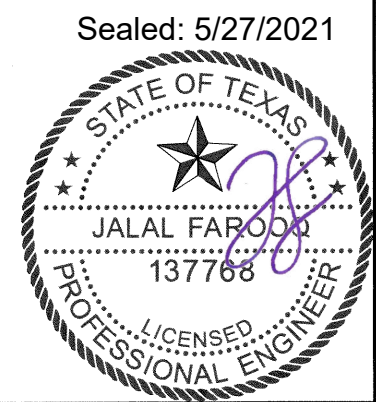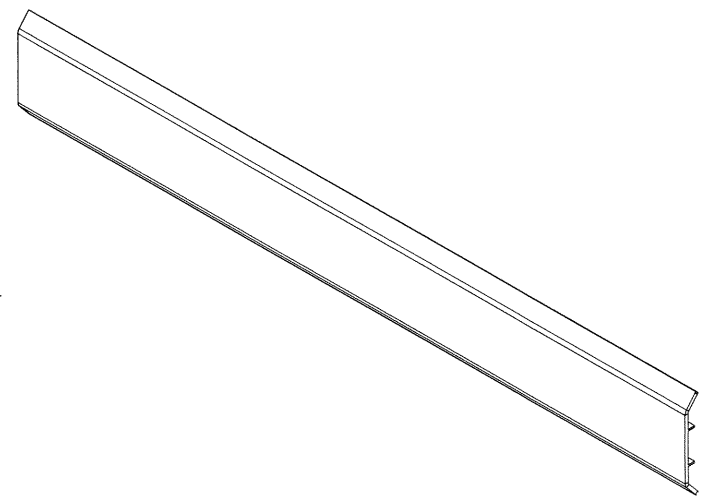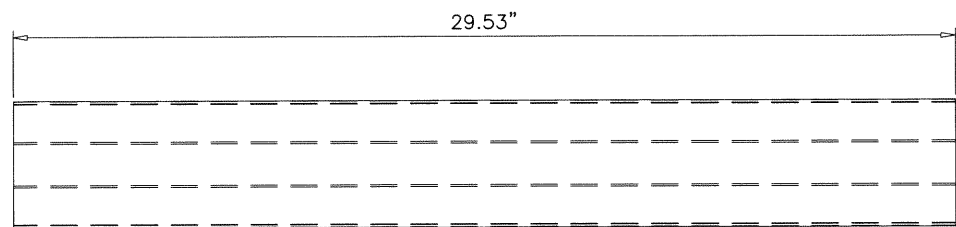


AL-FAROOQ CORPORATION
 ENGINEERS & PRODUCT DEVELOPMENT
 9360 SUNSET DRIVE, SUITE 220
 MIAMI, FLORIDA 33173 (C.A.N. 3538)
 TEL. (305) 264-8100 FAX. (305) 262-6978


WALK-IN COOLER & FREEZER
Barcel USA LLC.
 301 Northpoint Drive, Suite 100
 Coppell, TX 75019
 Phone: (972) 591-2493 Fax: (214) 441-9757

revisions:	no	date	by	description
date:	11-20-20	scale:	FULL	dr. by: -
chk. by:				
drawing no.	20-95T			
sheet	40 of 47			

COOLER\20-95T-BUS

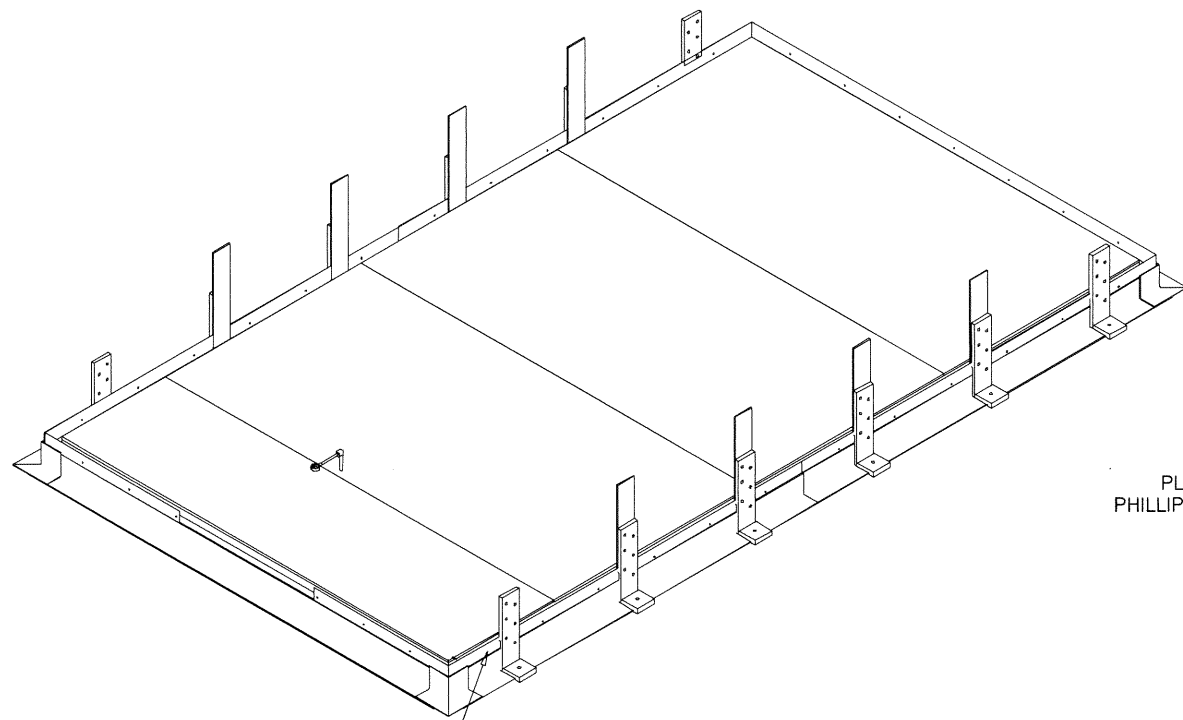


PLACE A #10 X 1" ZINC PLATED
PHILLIPS MODIFIED TRUSS HEAD SELF
DRILLING SCREW

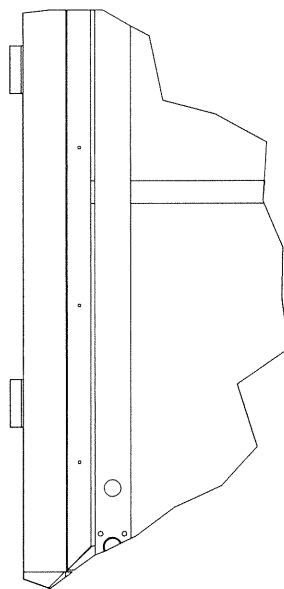


DETAIL FP

PLACE A #10 X 1" ZINC PLATED
PHILLIPS MODIFIED TRUSS HEAD SELF
DRILLING SCREW

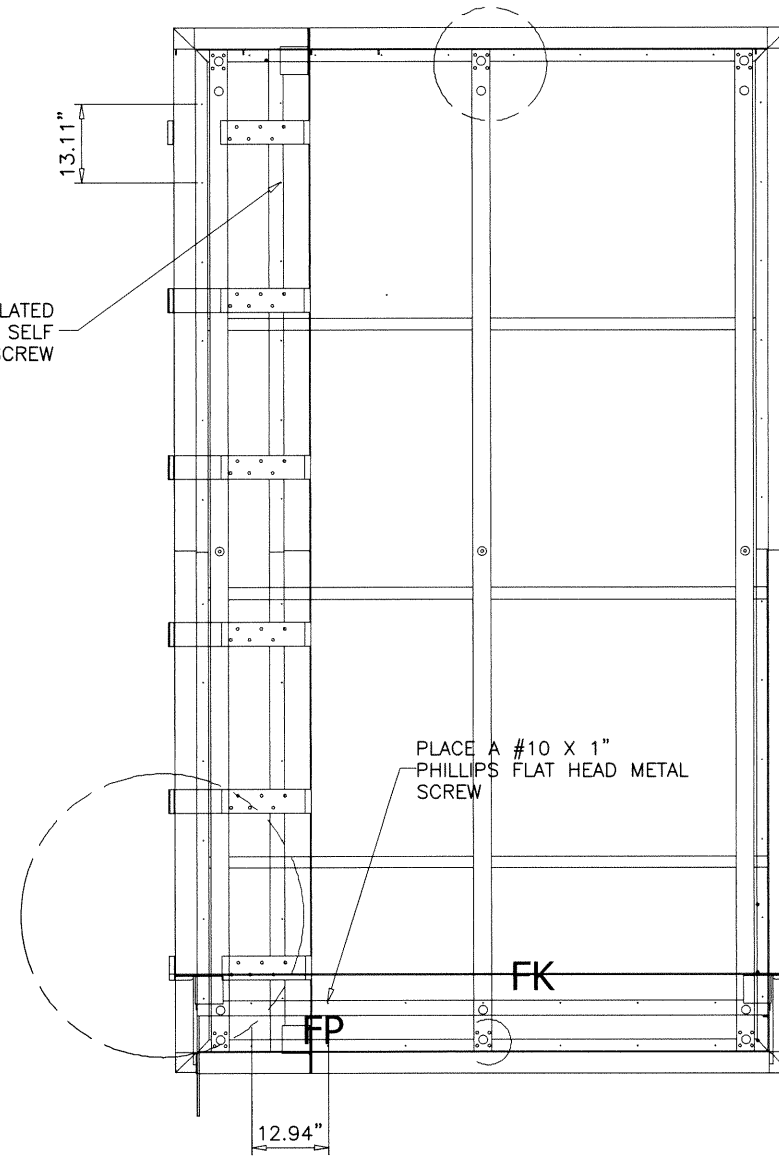

PLACE A #10 X 1" PHILLIPS
FLAT HEAD METAL
SCREW


PLACE A #10 X 1" ZINC PLATED
PHILLIPS MODIFIED TRUSS HEAD SELF
DRILLING SCREW

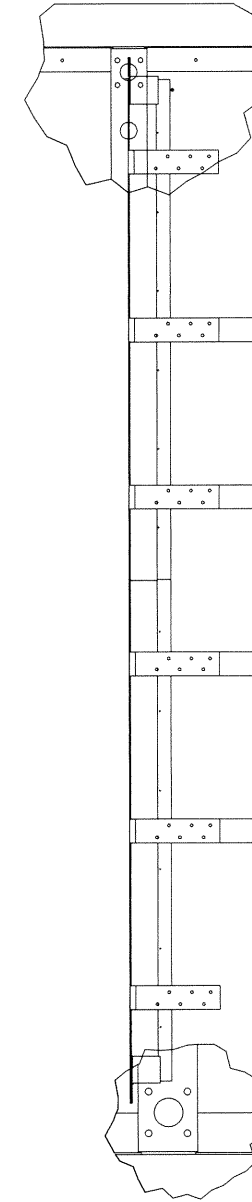

DETAIL FK

DETAIL FL

Sealed: 5/27/2021

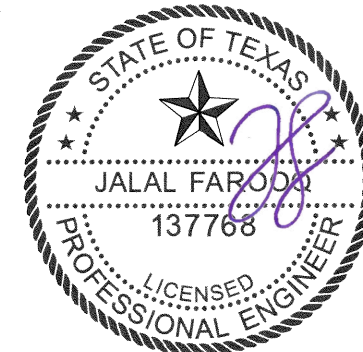

afc
AL-FAROOQ CORPORATION
ENGINEERS & PRODUCT DEVELOPMENT
9360 SUNSET DRIVE, SUITE 220 (C.A.N. 3538)
MIAMI, FLORIDA 33173
TEL. (305) 264-8100 FAX. (305) 262-6978





WALK-IN COOLER & FREEZER
Barcel USA LLC.
301 Northpoint Drive, Suite 100
Coppell, TX 75019
Phone: (972) 591-2493 Fax: (214) 441-9757

revisions:	no	date	by	description

date: 11-20-20
scale: 3/8" = 1'-0"
dr. by: -
chk. by:

drawing no.
20-95T
sheet 41 of 47

COOLER\20-95T-BUS

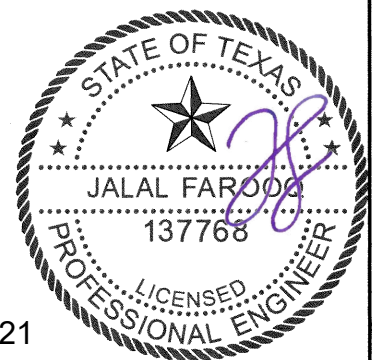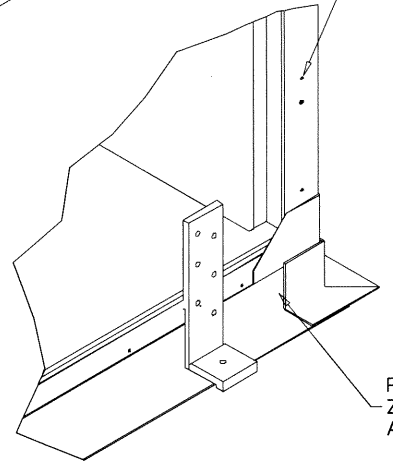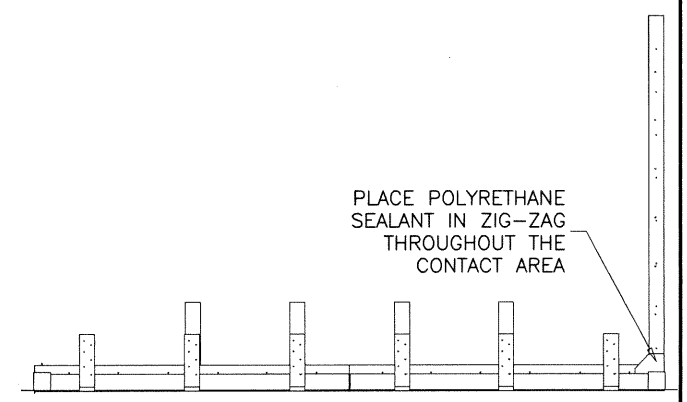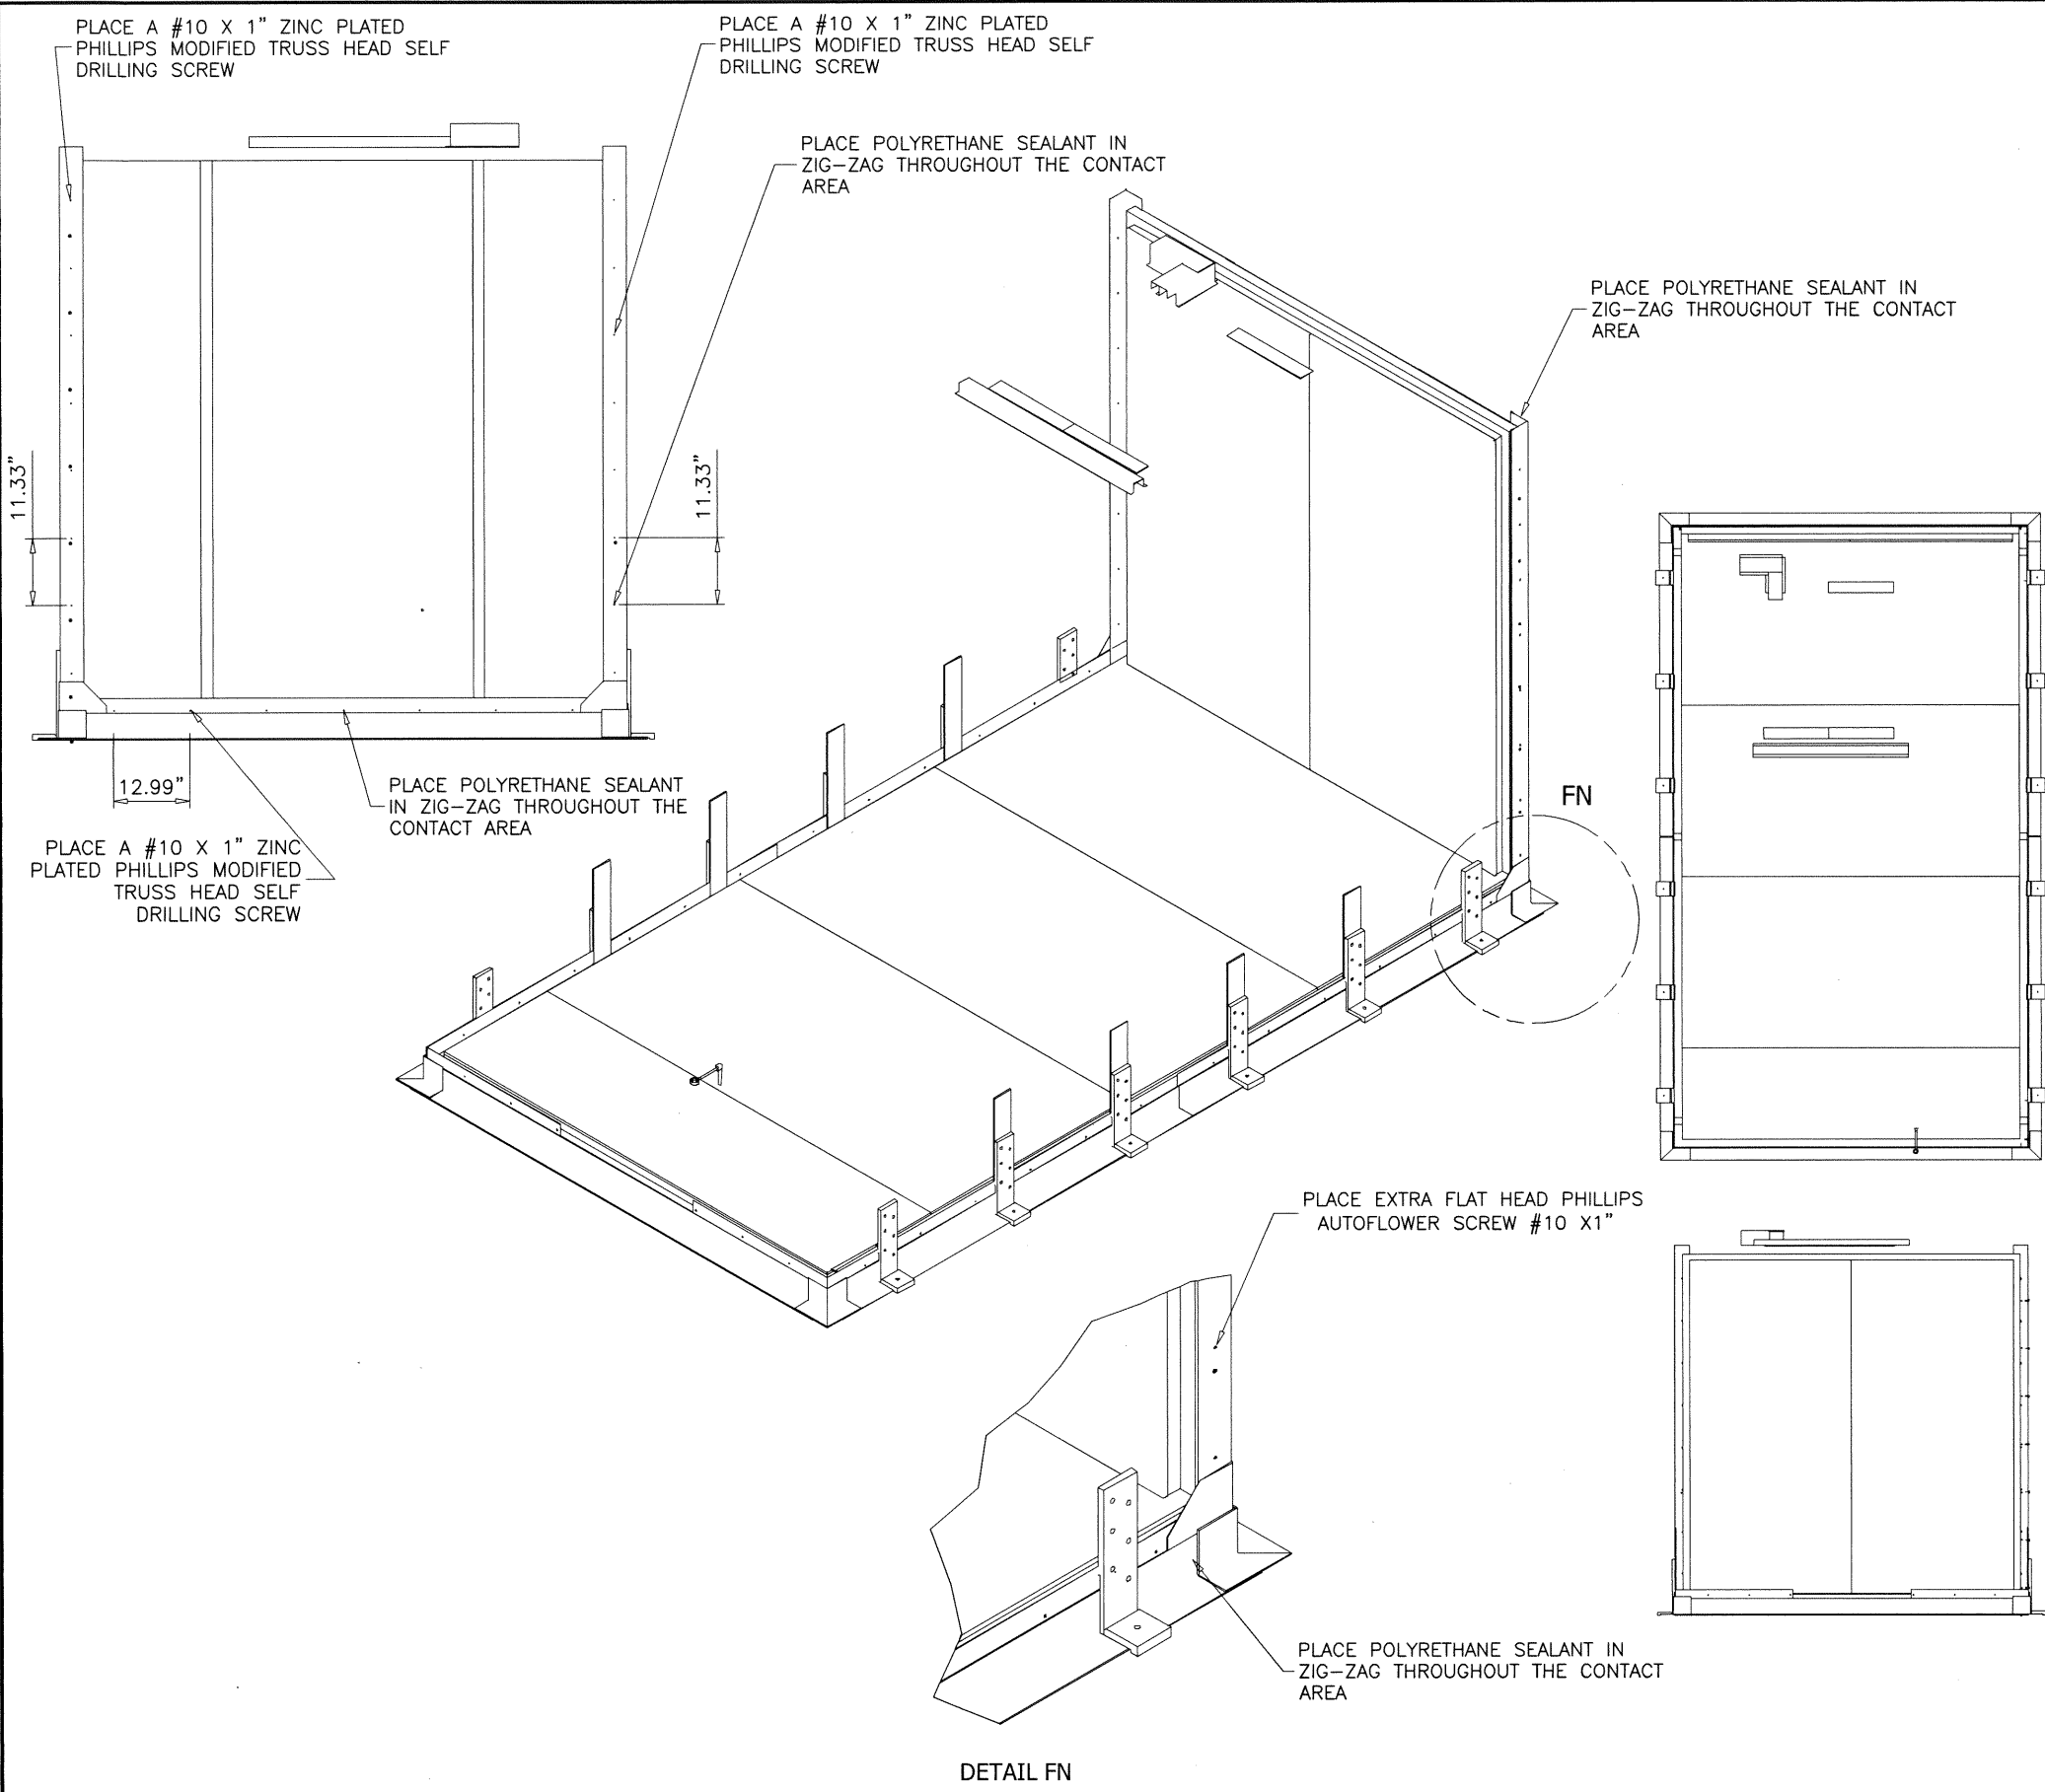

Sealed: 5/27/2021


afc
AL-FAROOQ CORPORATION
 ENGINEERS & PRODUCT DEVELOPMENT
 9360 SUNSET DRIVE, SUITE 220 (C.A.N. 3538)
 MIAMI, FLORIDA 33173
 TEL. (305) 264-8100 FAX. (305) 262-6978
 COOLER\20-95T-BUS

WALK-IN COOLER & FREEZER
Barcel USA LLC.
 301 Northpoint Drive, Suite 100
 Coppell, TX 75019
 Phone: (972) 591-2493 Fax: (214) 441-9757

revisions:	no	date	by	description

date: 11-20-20
 scale: 3/8"=1'-0"
 dr. by: -
 chk. by:

drawing no.
20-95T
 sheet 42 of 47

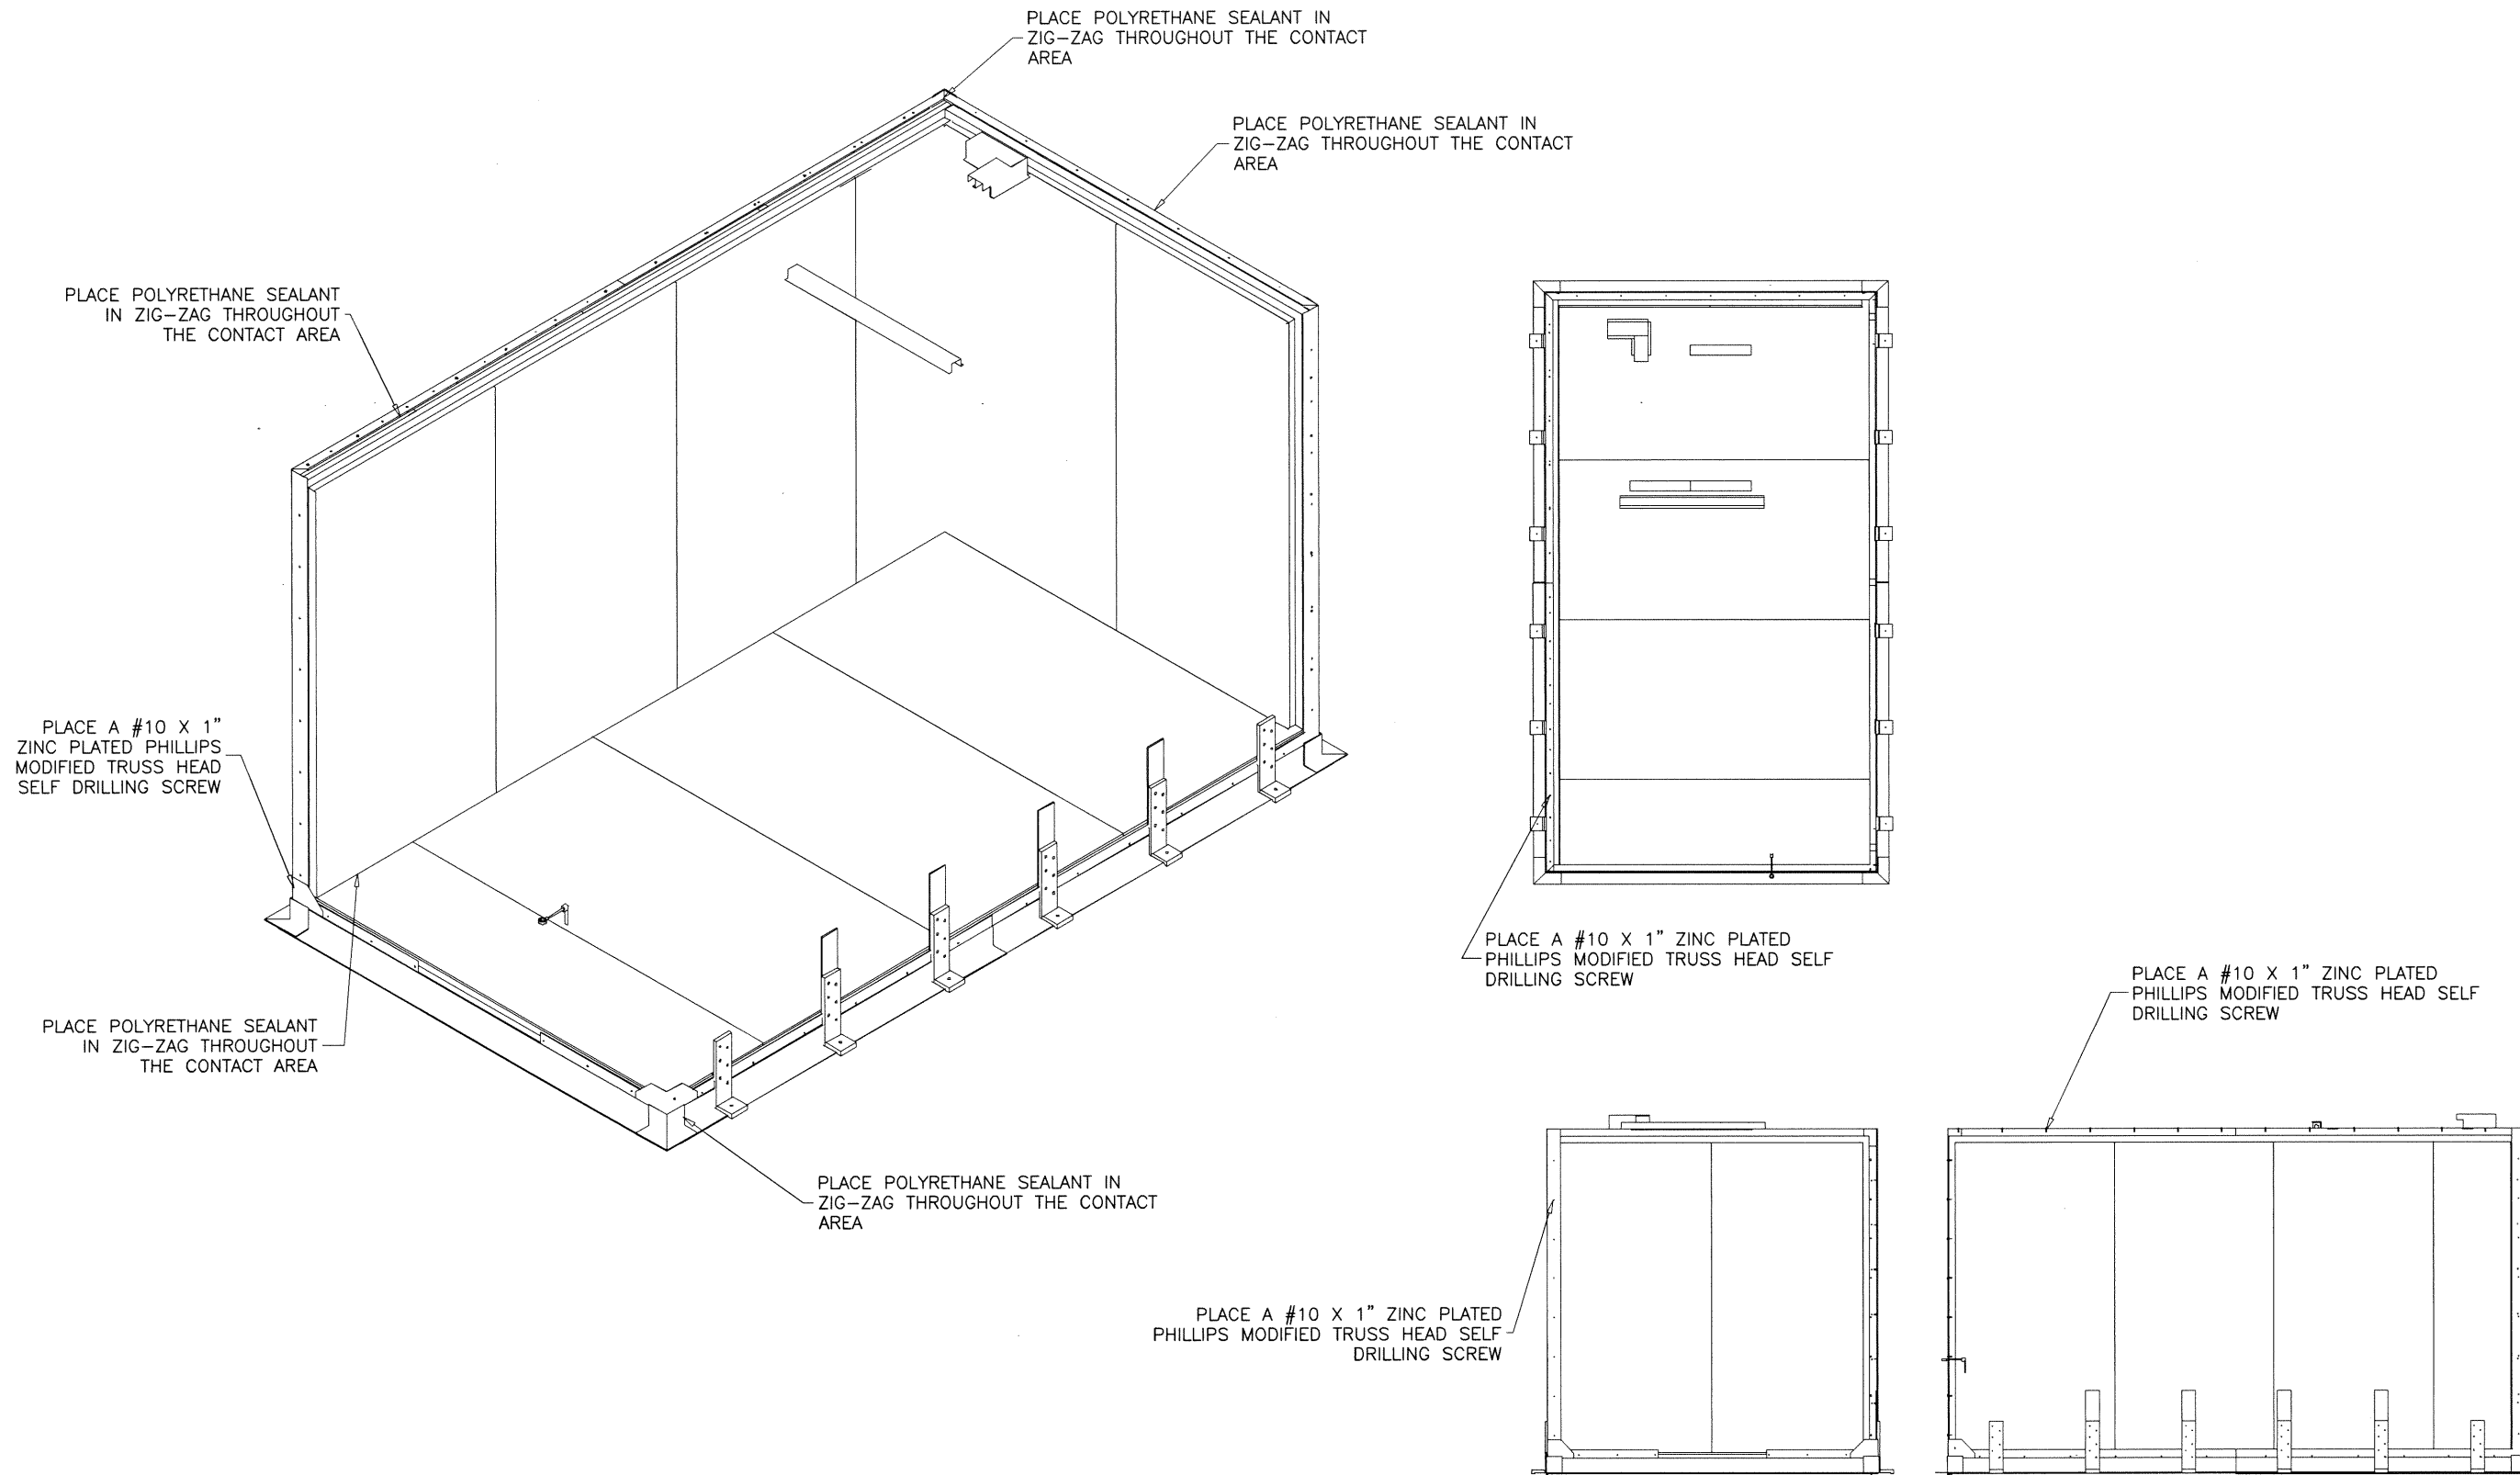


afc
AL-FAROOQ CORPORATION
 ENGINEERS & PRODUCT DEVELOPMENT
 9360 SUNSET DRIVE, SUITE 220
 MIAMI, FLORIDA 33173 (C.A.N. 3538)
 TEL. (305) 264-8100 FAX. (305) 262-6978
 COOLER\20-95T-BUS

WALK-IN COOLER & FREEZER
Barcel USA LLC.
 301 Northpoint Drive, Suite 100
 Coppell, TX 75019
 Phone: (972) 591-2493 Fax: (214) 441-9757


revisions:	no	date	by	description

date: 11-20-20
 scale: 3/8"=1'-0"
 dr. by: -
 chk. by: -

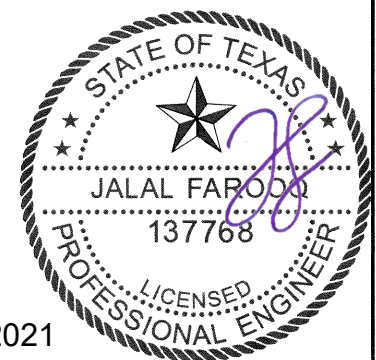

drawing no.
20-95T
 sheet 43 of 47

Sealed: 5/27/2021

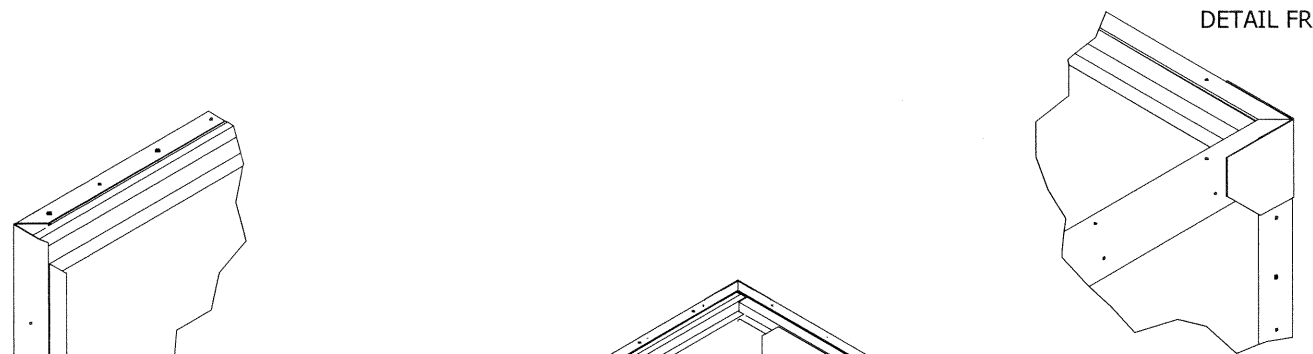

DETAIL FR

FT

FR

PLACE A #10 X 1" ZINC PLATED PHILLIPS MODIFIED TRUSS HEAD SELF DRILLING SCREW



PLACE A #10 X 1" ZINC PLATED PHILLIPS MODIFIED TRUSS HEAD SELF DRILLING SCREW

PLACE POLYURETHANE SEALANT IN ZIG-ZAG THROUGHOUT THE CONTACT AREA



PLACE POLYURETHANE SEALANT IN ZIG-ZAG THROUGHOUT THE CONTACT AREA

PLACE A #10 X 1" ZINC PLATED PHILLIPS MODIFIED TRUSS HEAD SELF DRILLING SCREW


PLACE A #10 X 1" ZINC PLATED PHILLIPS MODIFIED TRUSS HEAD SELF DRILLING SCREW

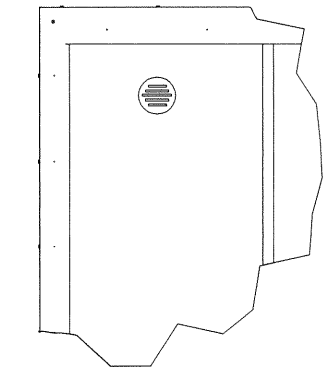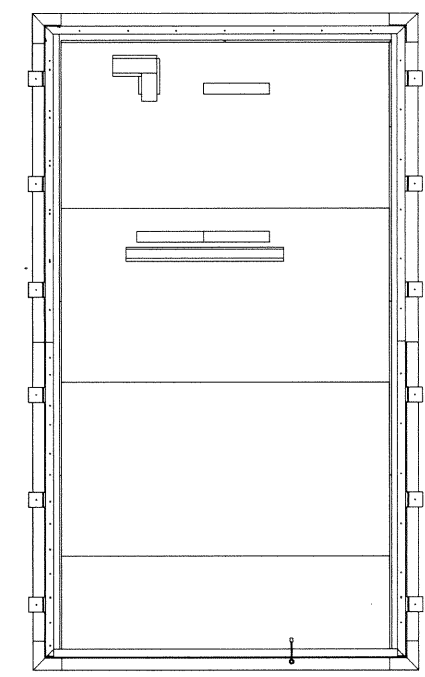

DETAIL FV

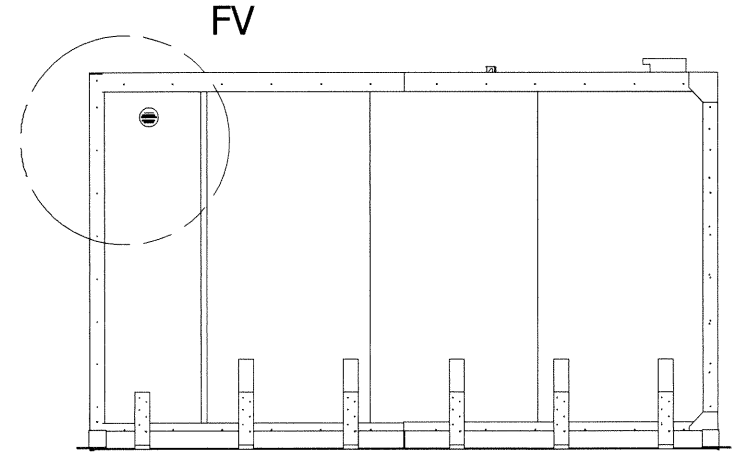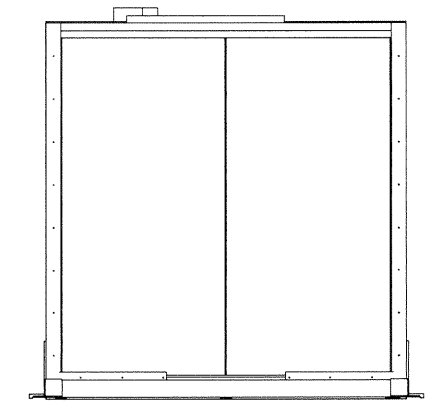

FV

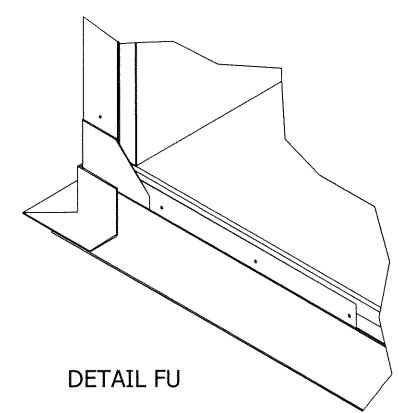


DETAIL FU

afc
AL-FAROOQ CORPORATION
 ENGINEERS & PRODUCT DEVELOPMENT
 9360 SUNSET DRIVE, SUITE 220 (C.A.N. 3538)
 MIAMI, FLORIDA 33173
 TEL. (305) 264-8100 FAX. (305) 262-6978
 COOLER\20-95T-BUS

WALK-IN COOLER & FREEZER
Barcel USA LLC.
 301 Northpoint Drive, Suite 100
 Coppell, TX 75019
 Phone: (972) 591-2493 Fax: (214) 441-9757

no	date	by	description

date: 11-20-20	scale: 3/8"=1'-0"	dr. by: -	chk. by:
----------------	-------------------	-----------	----------

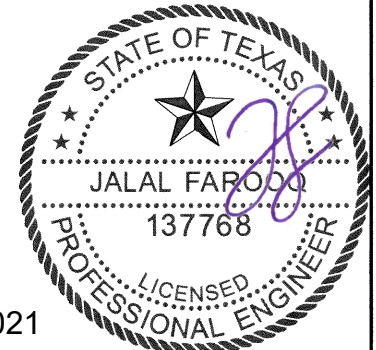

drawing no.	20-95T
sheet	44 of 47

Sealed: 5/27/2021

PLACE A #10 X 1" ZINC PLATED PHILLIPS MODIFIED TRUSS HEAD SELF DRILLING SCREW




PLACE POLYURETHANE SEALANT IN ZIG-ZAG THROUGHOUT THE CONTACT AREA

PLACE A #10 X 1" PHILLIPS FLAT HEAD METAL SCREW



PLACE POLYURETHANE SEALANT IN ZIG-ZAG THROUGHOUT THE CONTACT AREA

PLACE POLYURETHANE SEALANT IN ZIG-ZAG THROUGHOUT THE CONTACT AREA


PLACE POLYURETHANE SEALANT IN ZIG-ZAG THROUGHOUT THE CONTACT AREA

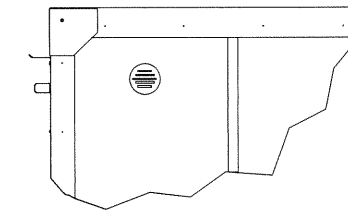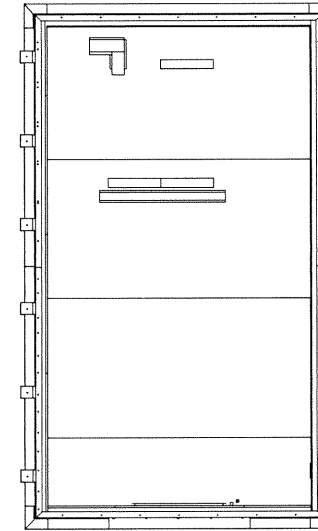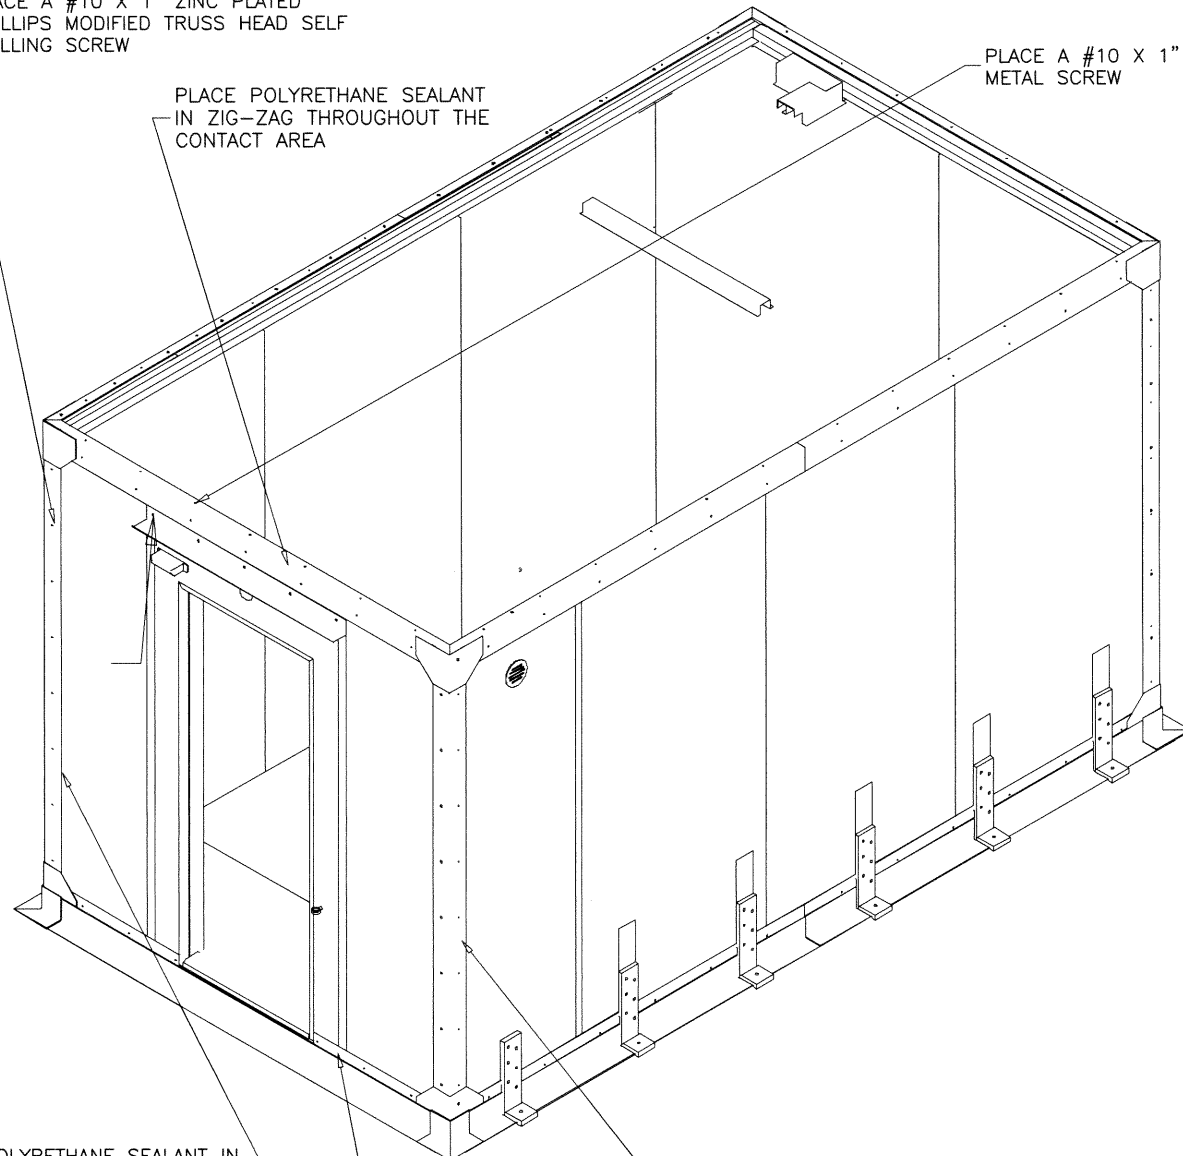

DETAIL FW

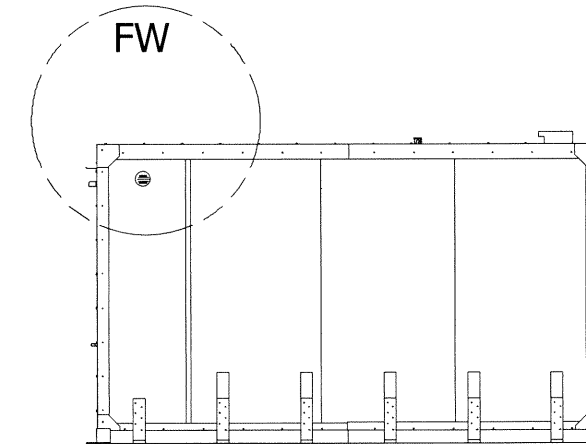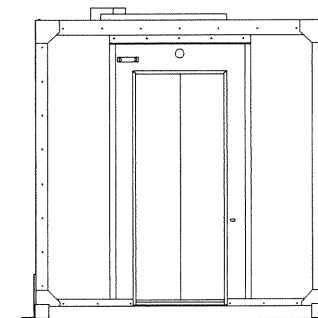

Sealed: 5/27/2021

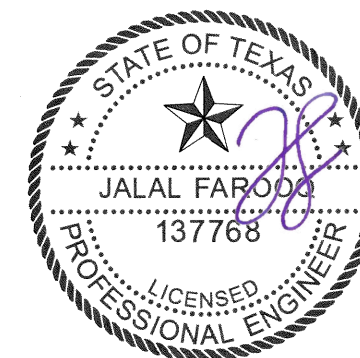








afc
AL-FAROOQ CORPORATION
 ENGINEERS & PRODUCT DEVELOPMENT
 9360 SUNSET DRIVE, SUITE 220 (C.A.N. 3538)
 MIAMI, FLORIDA 33173
 TEL. (305) 264-8100 FAX. (305) 262-6978
 COOLER\20-95T-BUS

WALK-IN COOLER & FREEZER
Barcel USA LLC.
 301 Northpoint Drive, Suite 100
 Coppell, TX 75019
 Phone: (972) 591-2493 Fax: (214) 441-9757


revisions:	no	date	by	description

date: 11-20-20
 scale: 3/8"=1'-0"
 dr. by: -
 chk. by:

drawing no.
20-95T
 sheet 45 of 47

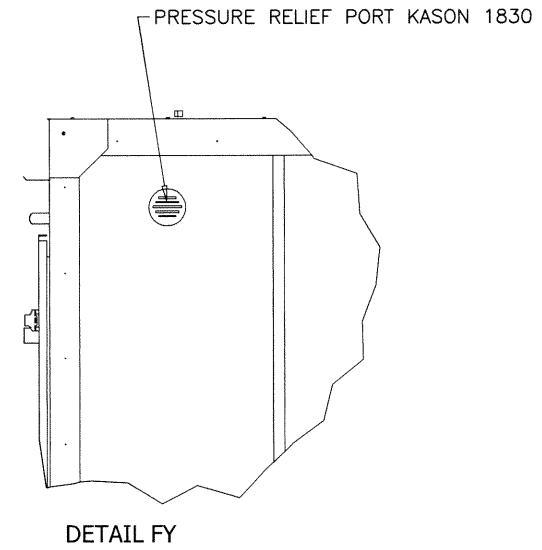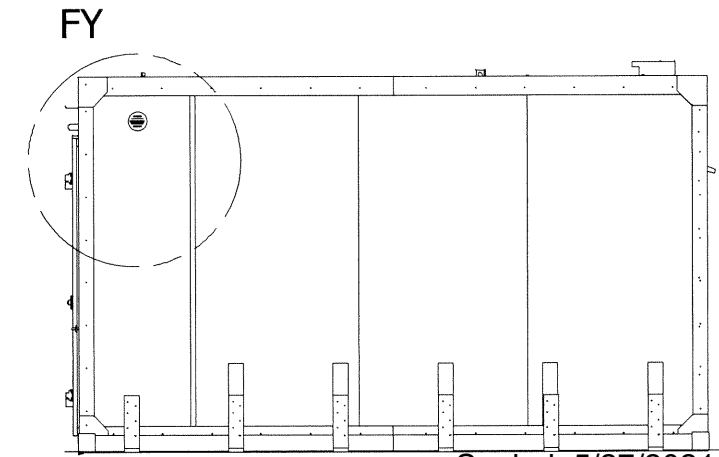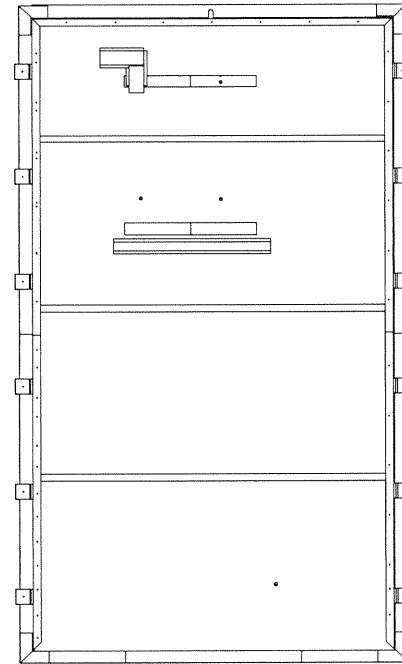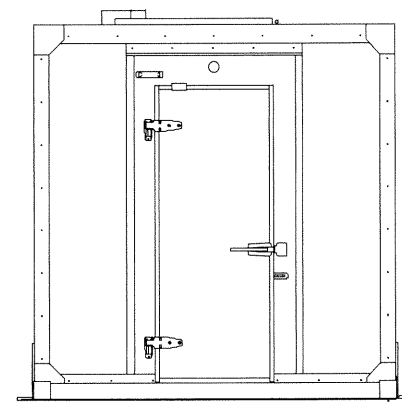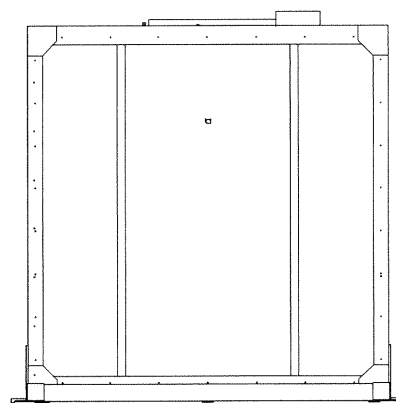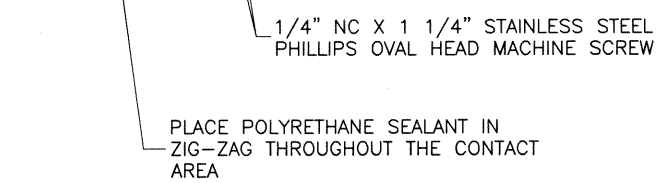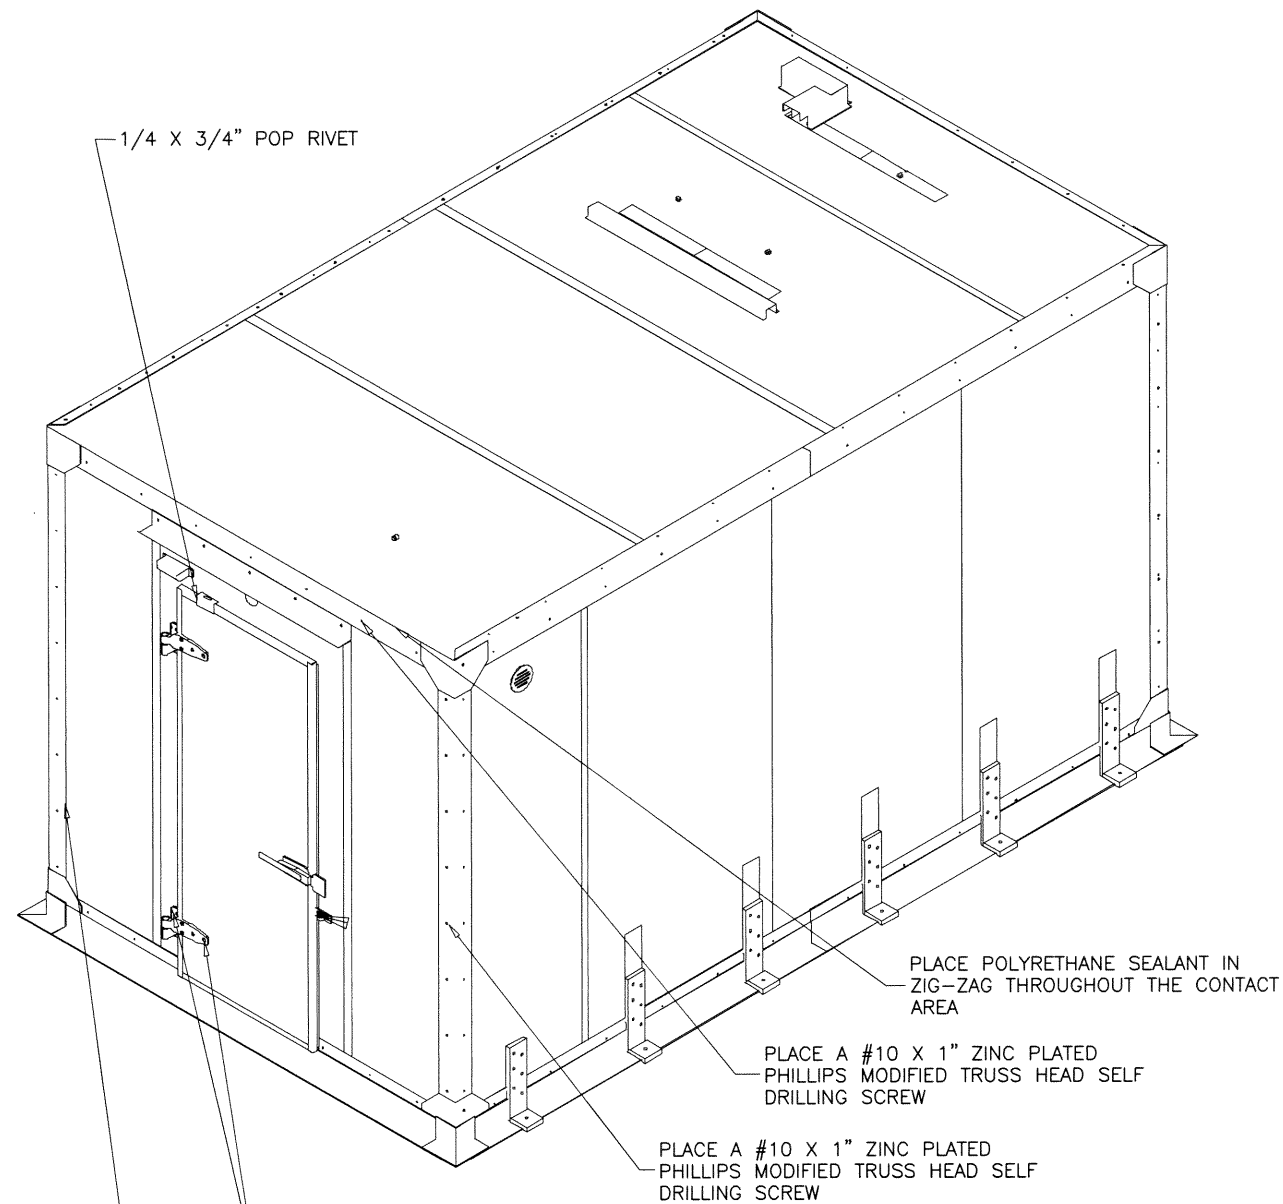

Sealed: 5/27/2021

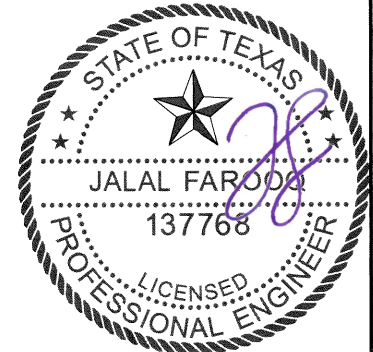

afc
AL-FAROOQ CORPORATION
 ENGINEERS & PRODUCT DEVELOPMENT
 9360 SUNSET DRIVE, SUITE 220 (C.A.N. 3538)
 MIAMI, FLORIDA 33173
 TEL. (305) 264-8100 FAX. (305) 262-6978
 COOLER\20-95T-BUS

WALK-IN COOLER & FREEZER
Barcel USA LLC.
 301 Northpoint Drive, Suite 100
 Coppell, TX 75019
 Phone: (972) 591-2493 Fax: (214) 441-9757

no.	date	description

date: 11-20-20
 scale: 3/8"=1'-0"
 dr. by: -
 chk. by:
 drawing no.
20-95T
 sheet 46 of 47

afc

AL-FAROOQ CORPORATION
ENGINEERS & PRODUCT DEVELOPMENT
9360 SUNSET DRIVE, SUITE 220
MIAMI, FLORIDA 33173 (C.A.N. 3538)
TEL. (305) 264-8100 FAX. (305) 262-6978
COOLER\20-95T-BUS

WALK-IN COOLER & FREEZER

Barcel USA LLC.

301 Northpoint Drive, Suite 100
Coppell, TX 75019
Phone: (972) 591-2493 Fax: (214) 441-9757

revisions:
no date by description

date: 11-20-20
scale: 3/8"=1'-0"

dr. by: -
chk. by:

drawing no.
20-95T

sheet 47 of 47

PLACE A #10 X 1" ZINC PLATED
PHILLIPS MODIFIED TRUSS HEAD SELF
DRILLING SCREW

PLACE A #10 X 1" ZINC PLATED
PHILLIPS MODIFIED TRUSS HEAD SELF
DRILLING SCREW


PLACE A #10 X 1" ZINC PLATED
PHILLIPS MODIFIED TRUSS HEAD SELF
DRILLING SCREW

PLACE A #10 X 1" ZINC PLATED
PHILLIPS MODIFIED TRUSS HEAD SELF
DRILLING SCREW


PLACE A #10 X 1" ZINC PLATED
PHILLIPS MODIFIED TRUSS HEAD SELF
DRILLING SCREW

3/8 NC RIVET NUT


4 3/8 NC X 1 3/4 " HEX CAP HEAD

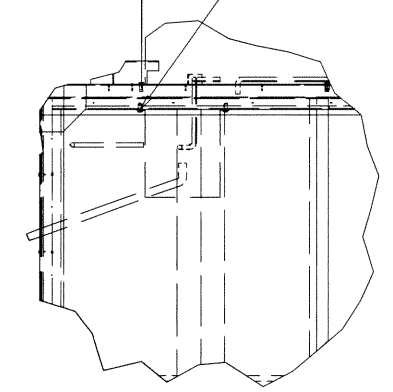

DETAIL GB




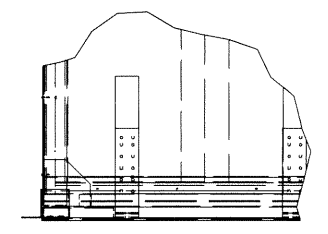


DETAIL GA

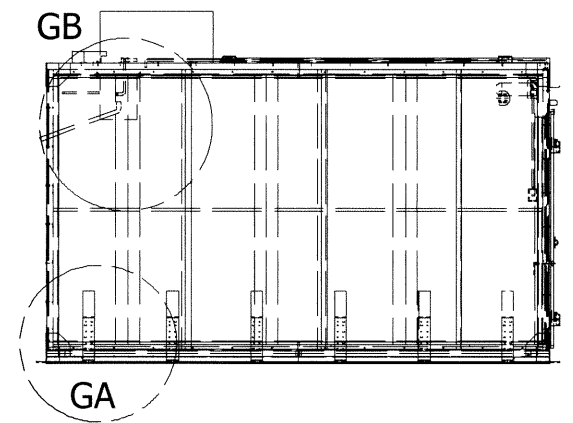

GB

GA

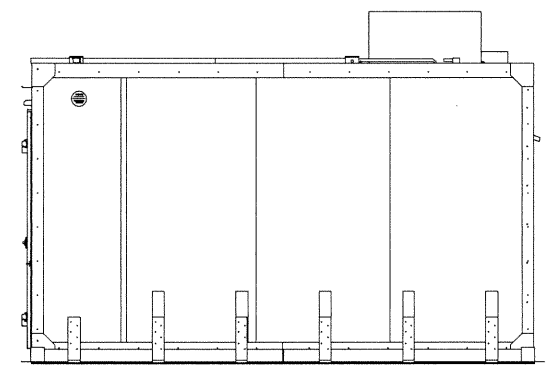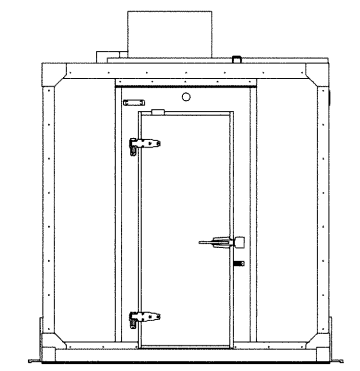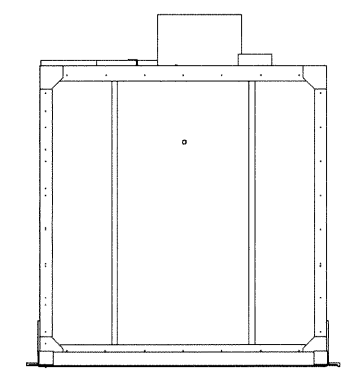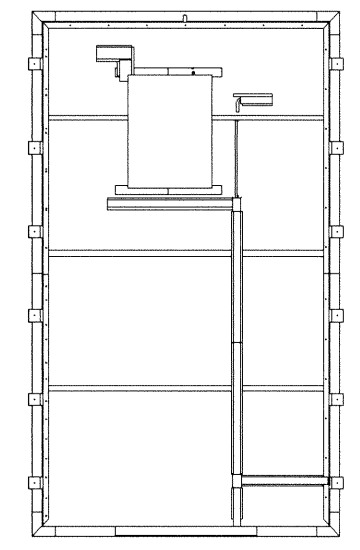

Sealed: 5/27/2021

